
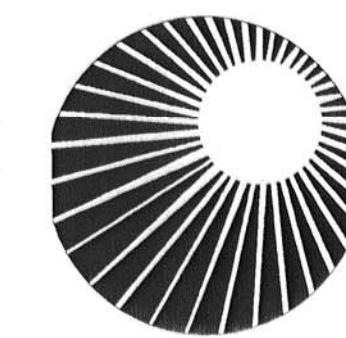
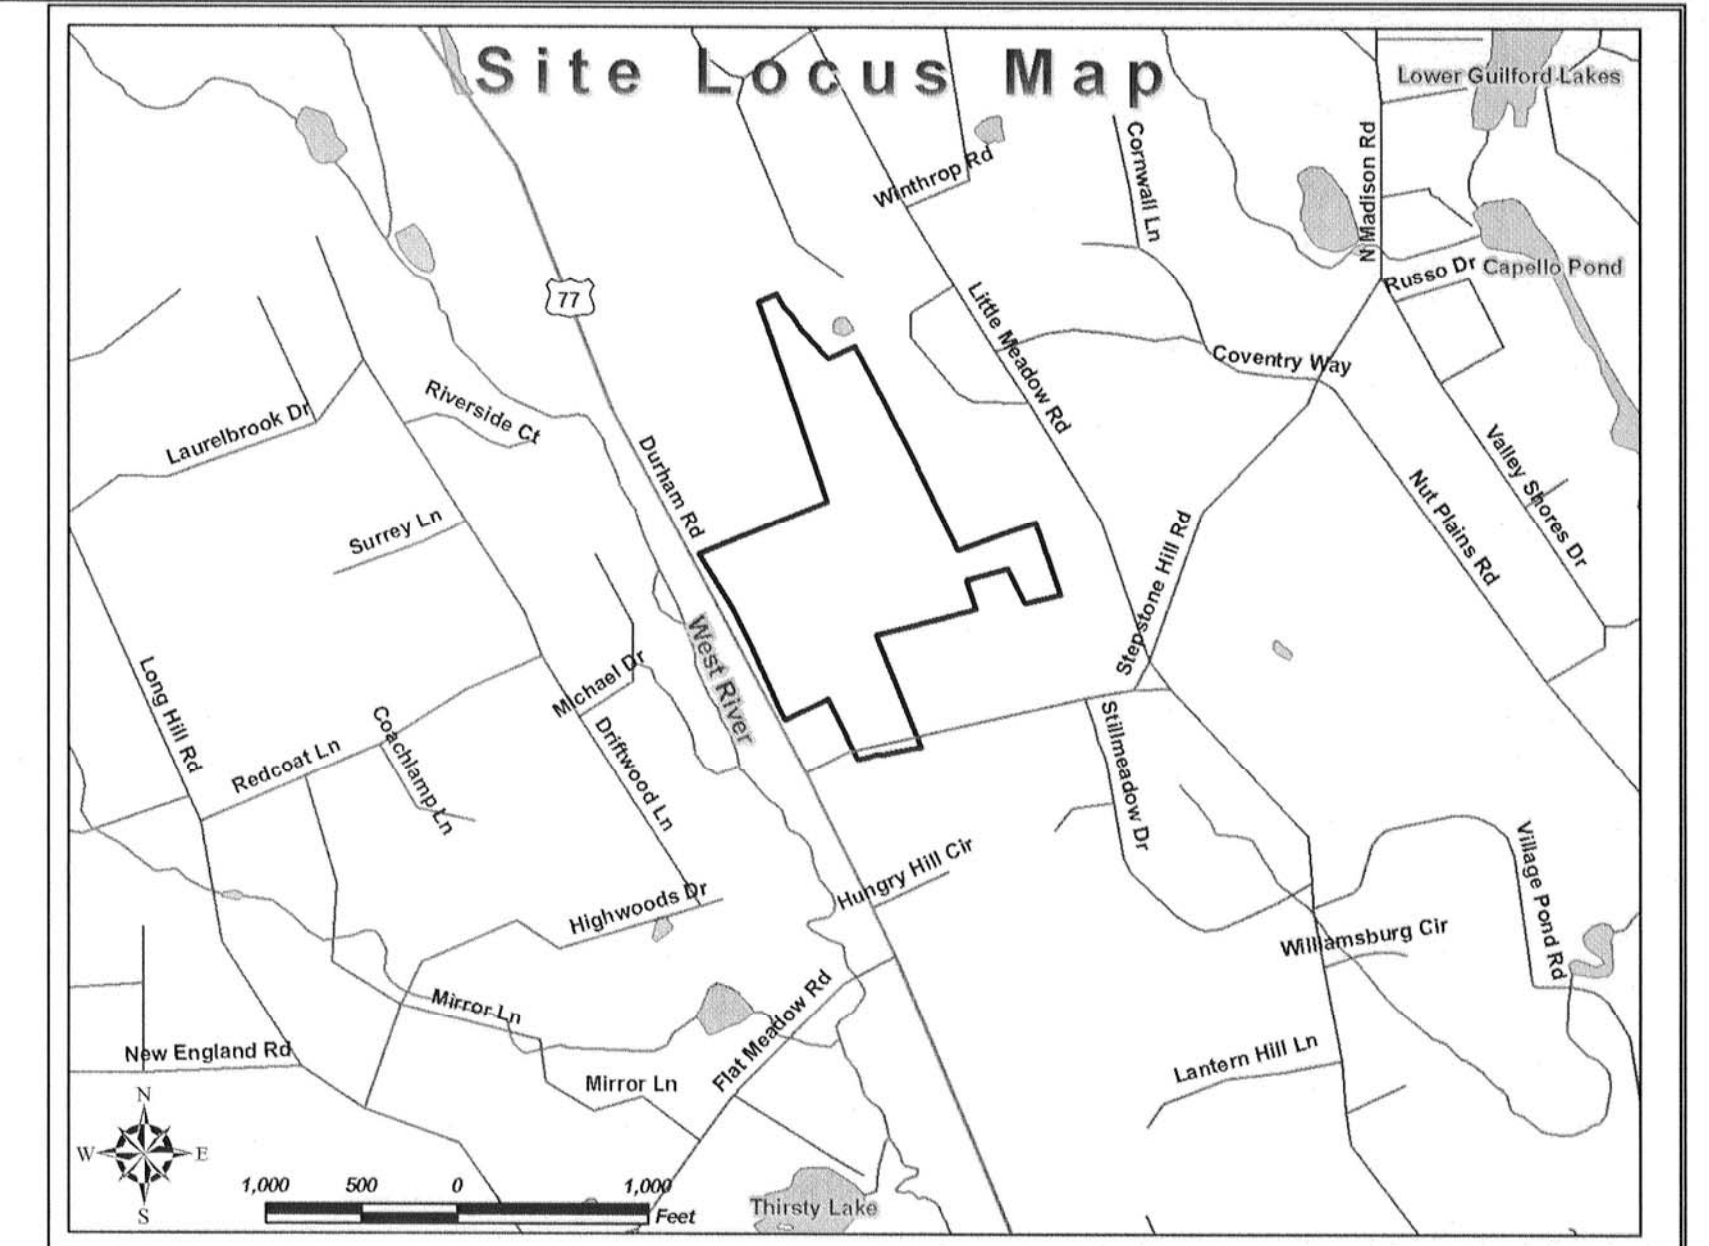




Appendix F

Location Approval Site Plans

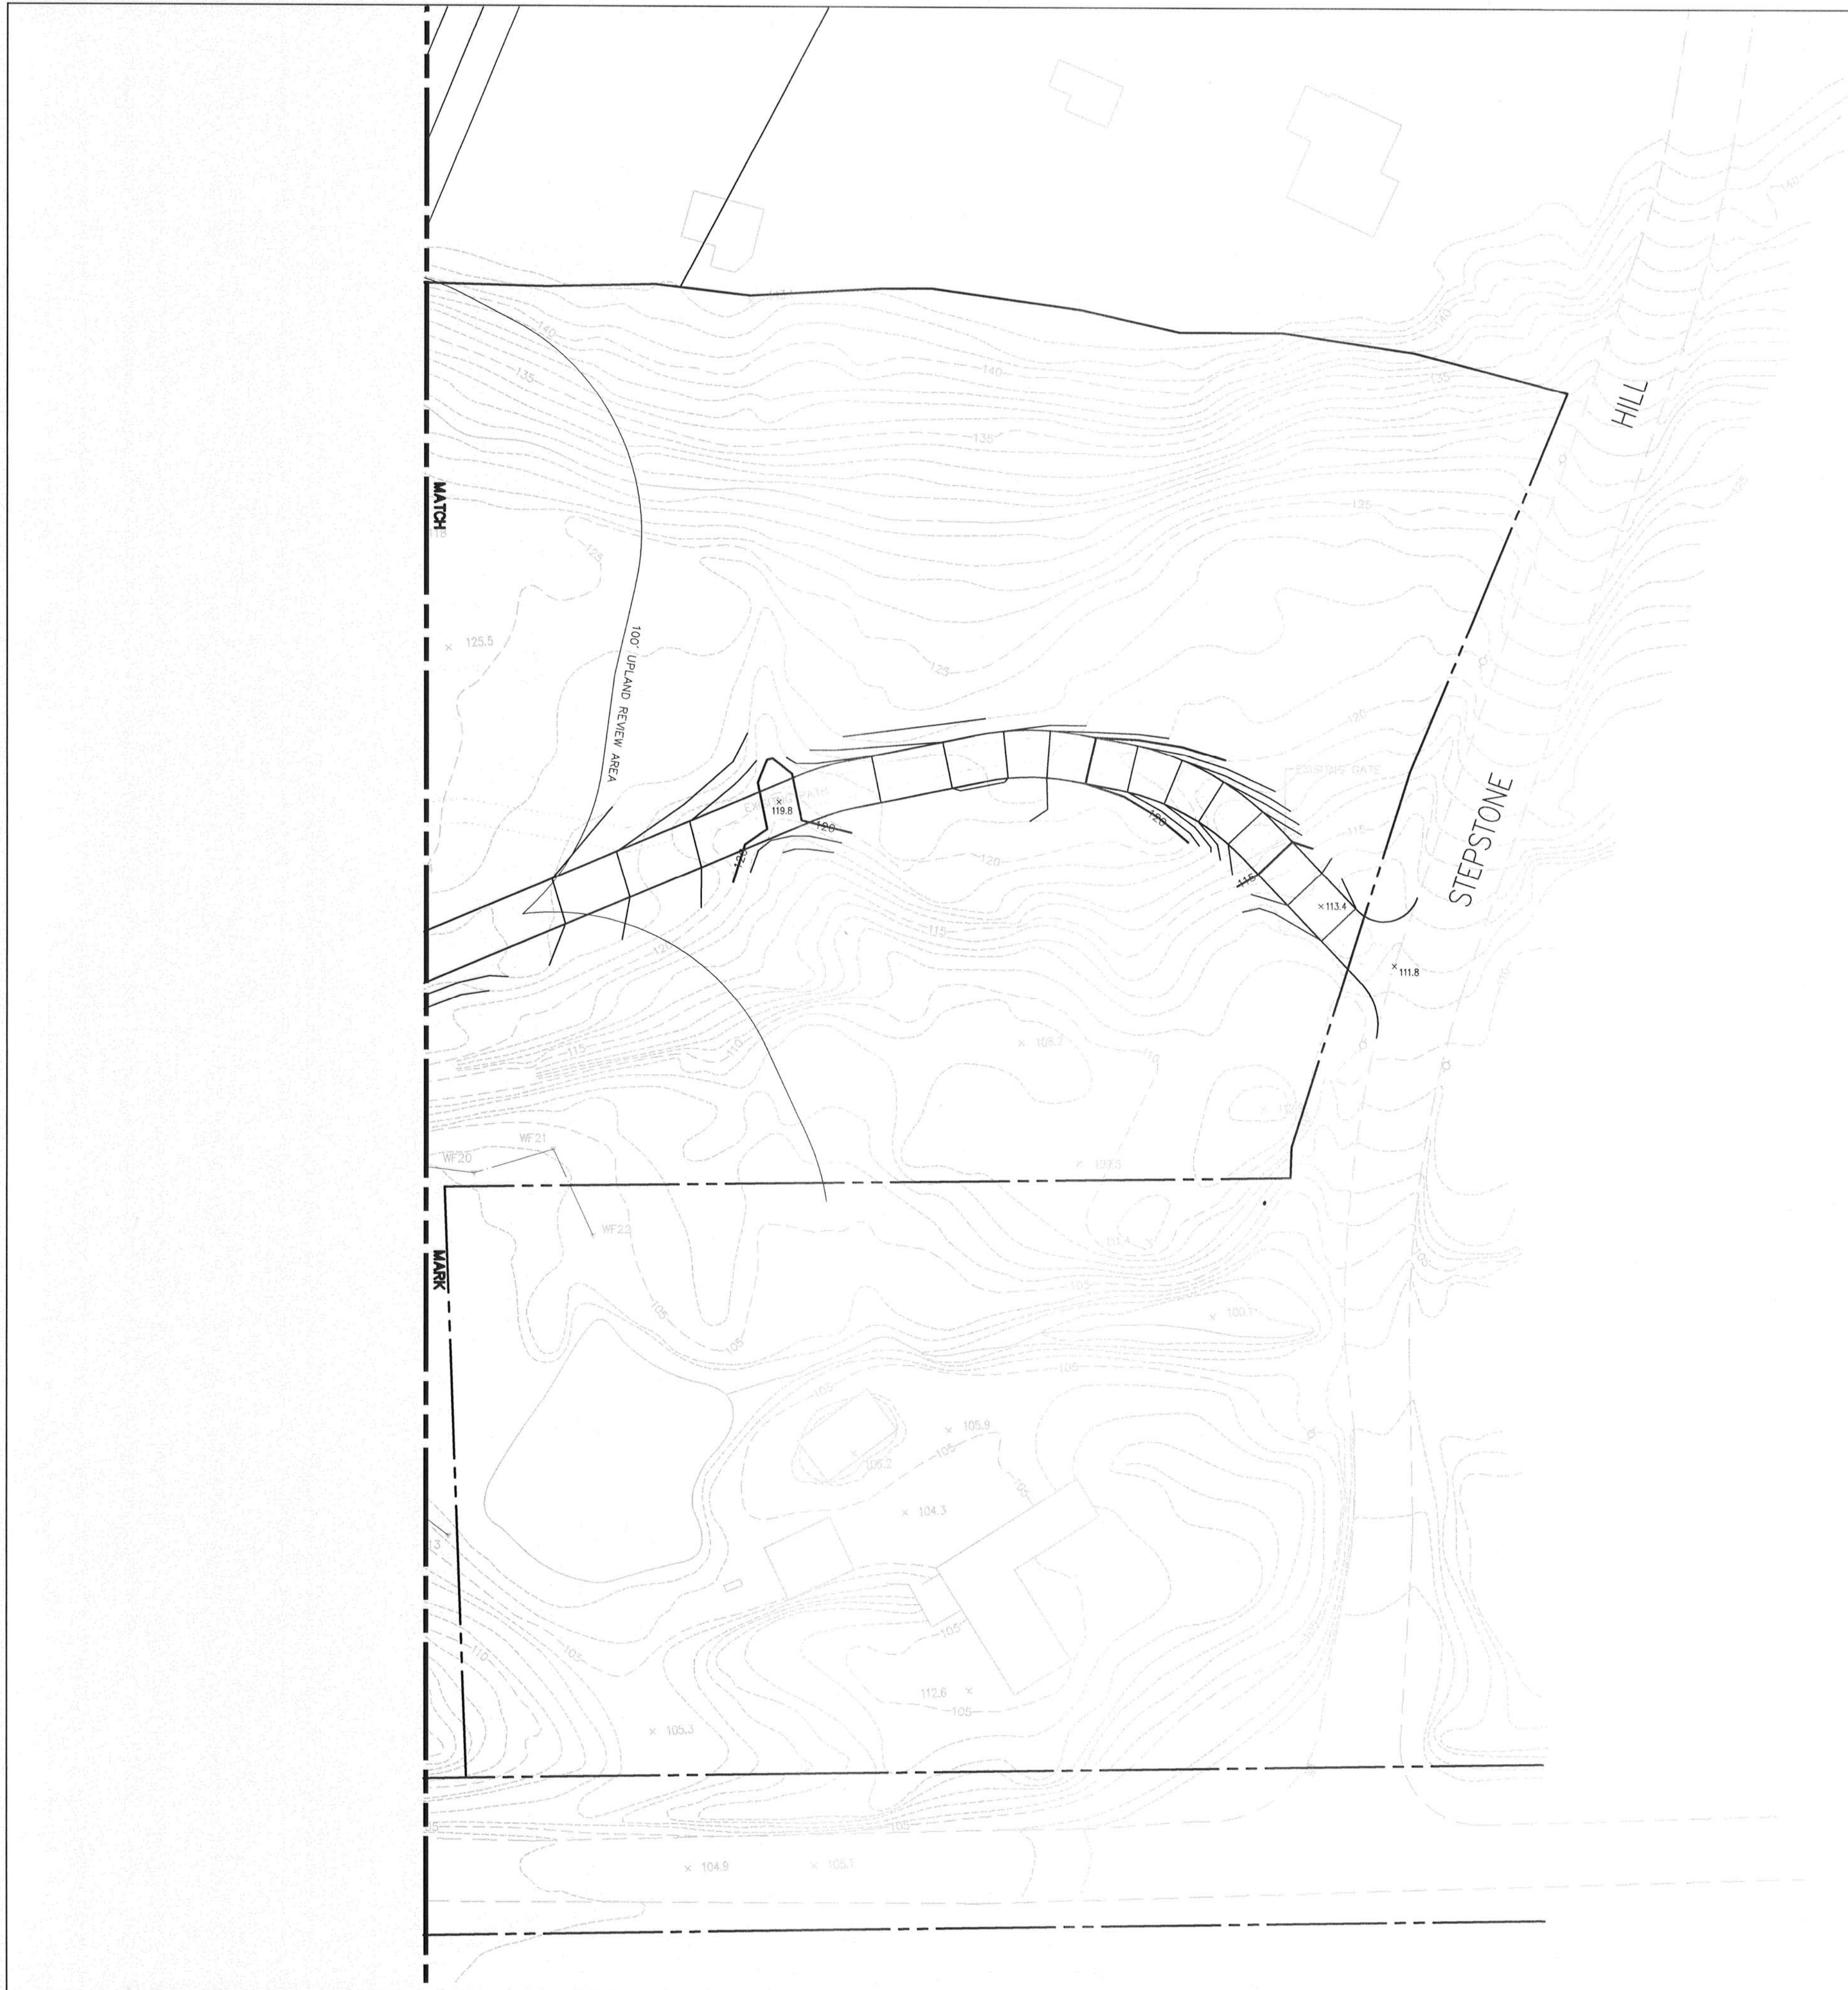

**Connecticut
Light & Power**

The Northeast Utilities System

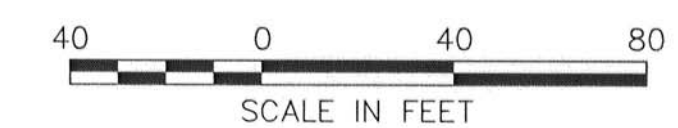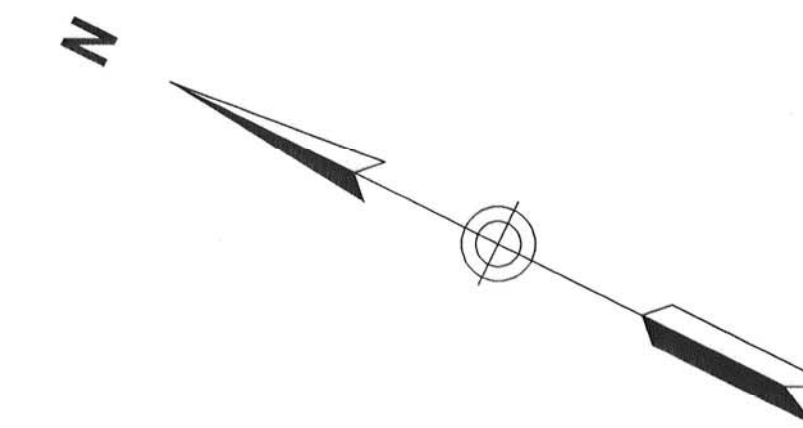

PLANS AND SPECIFICATIONS ARE SUBJECT TO
REVISIONS PENDING FINAL SITING COUNCIL
APPROVAL

PRELIMINARY

CAD
GENERATED
DWG



NORTHEAST UTILITIES SERVICE CO.			
FOR THE CONNECTICUT LIGHT & POWER COMPANY			
TITLE			
Grading & Utility Plan Stepstone Hill Substation Guilford, Connecticut			
BY	VHB	CHKD	APP
DATE	06/26/06	DATE	DATE
SCALE	1" = 40'	DWG. NO.	C-4
MF	NO.	DATE	REVISIONS
BY	CHK	APP	APP