
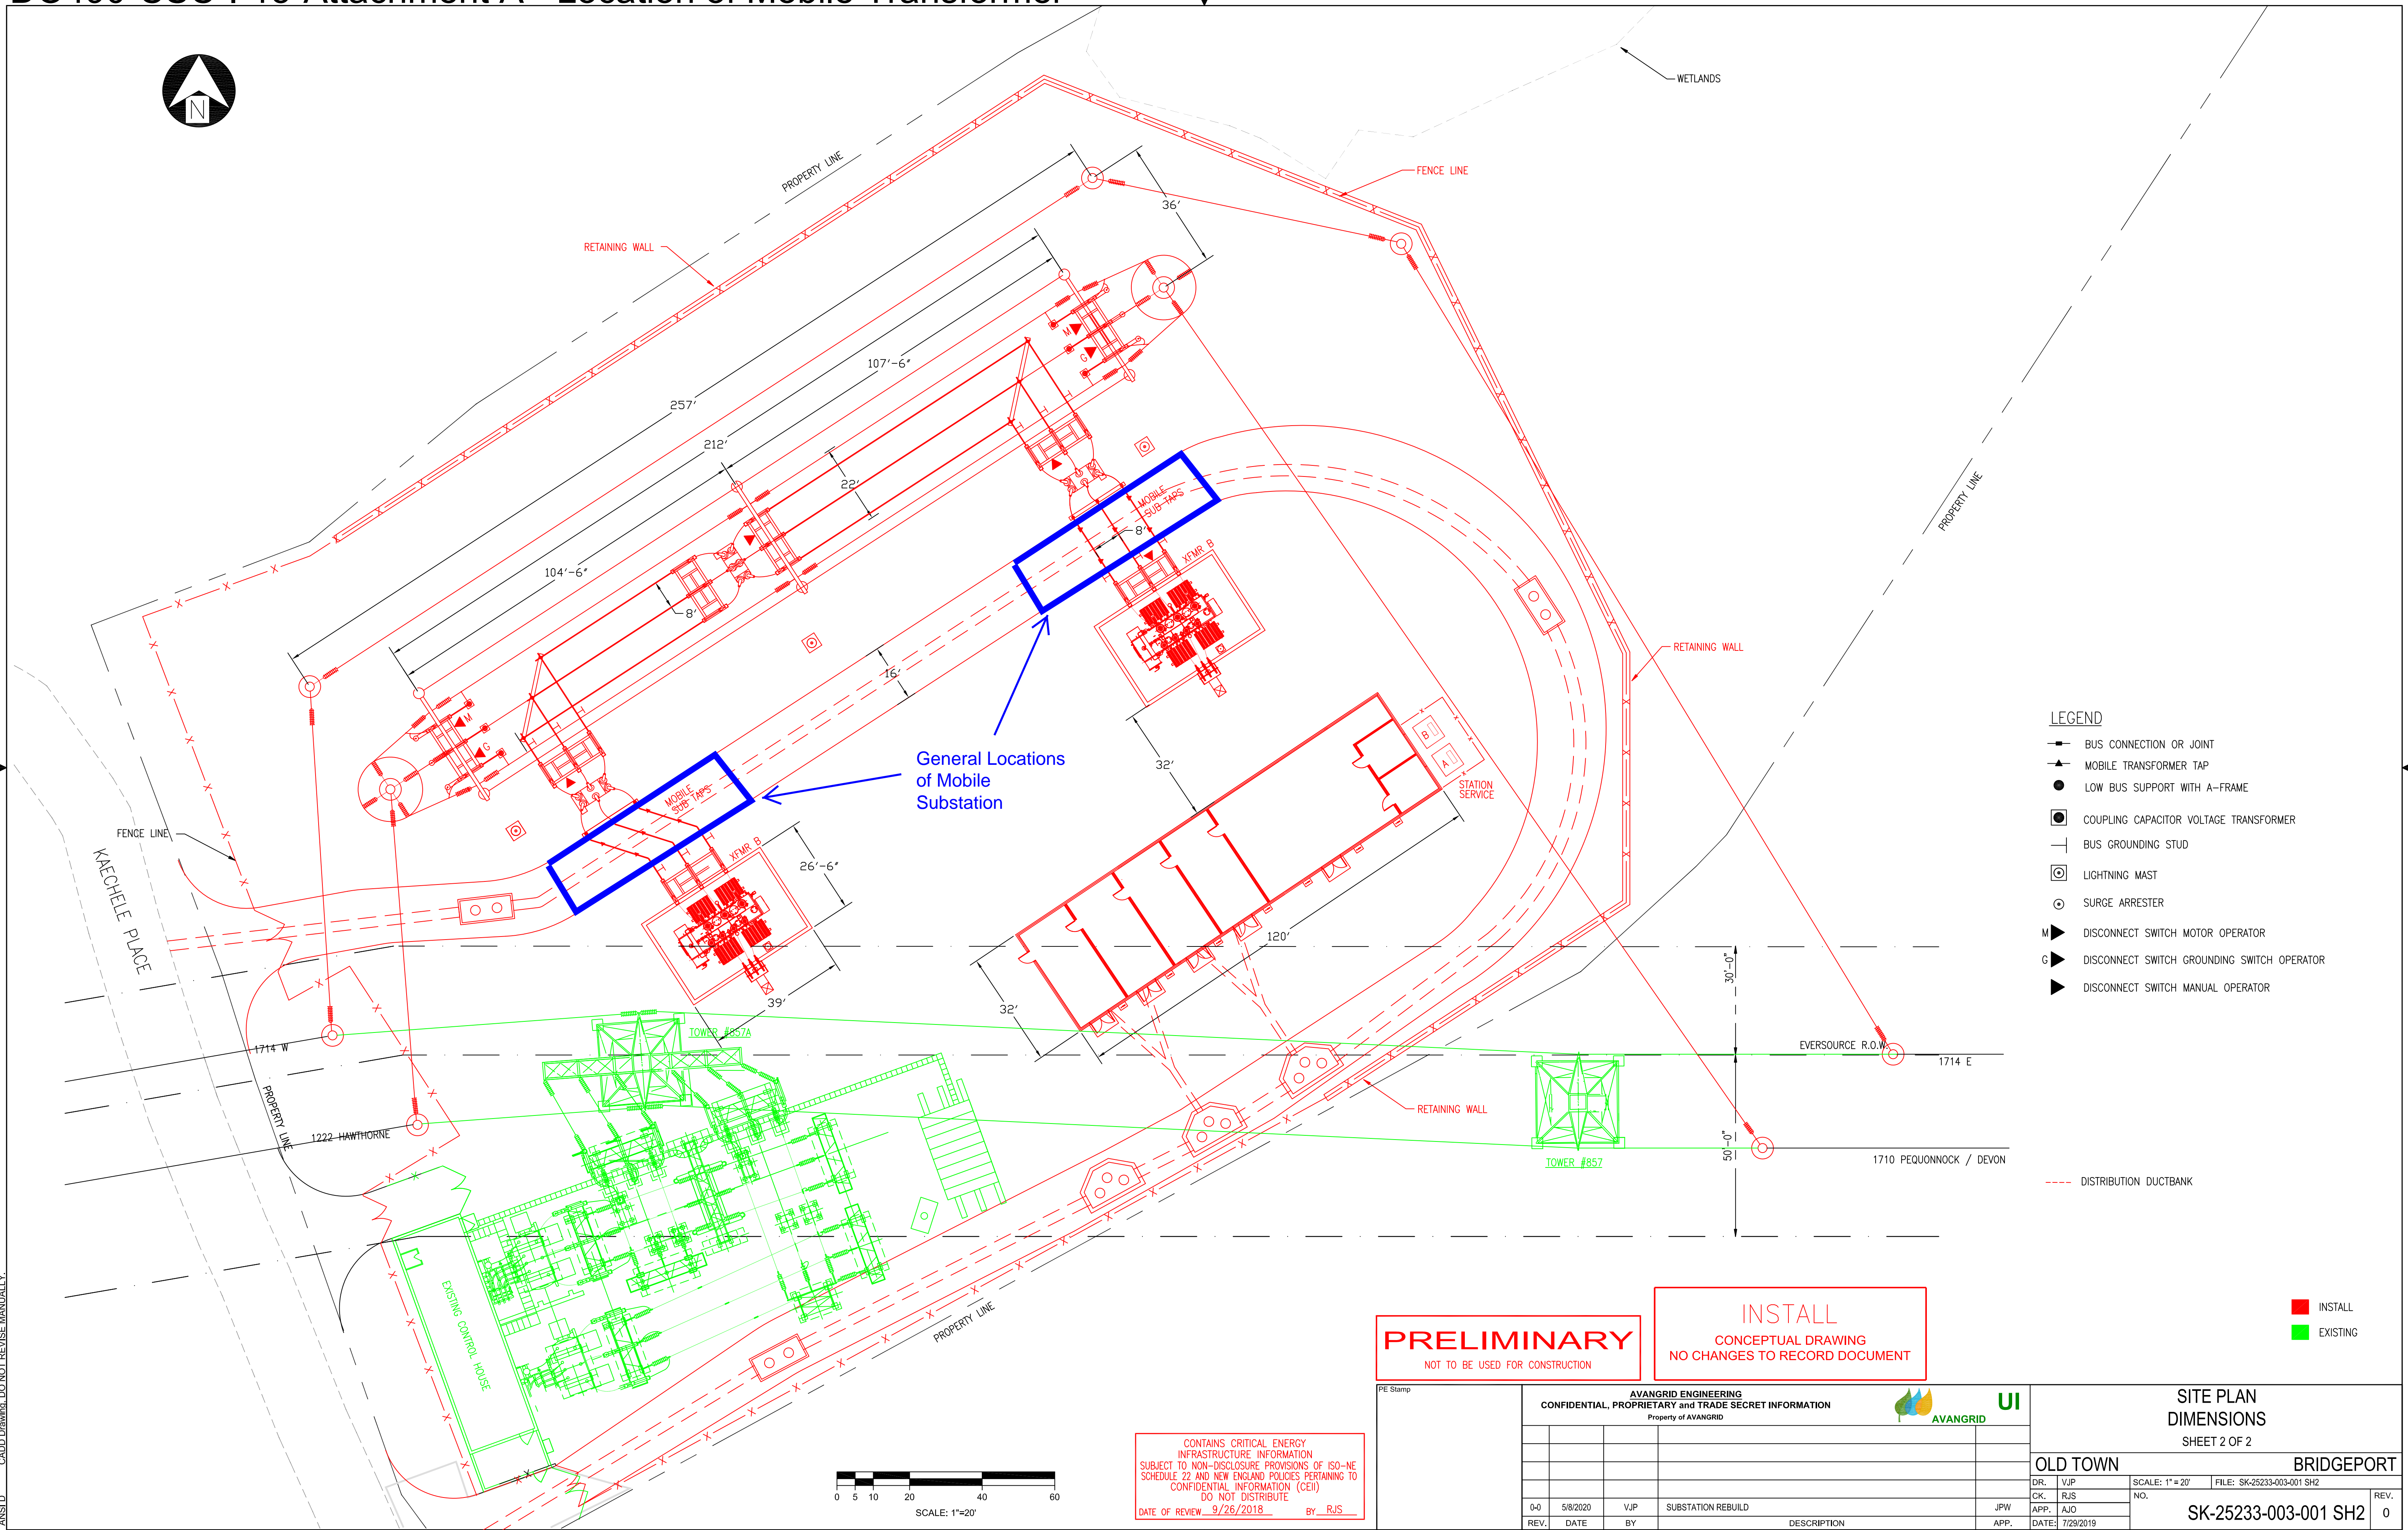


DO490-CSC-I-15-Attachment A - Location of Mobile Transformer

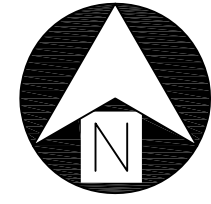

- LEGEND**
- BUS CONNECTION OR JOINT
 - ▲ MOBILE TRANSFORMER TAP
 - LOW BUS SUPPORT WITH A-FRAME
 - ⊗ COUPLING CAPACITOR VOLTAGE TRANSFORMER
 - BUS GROUNDING STUD
 - ⊙ LIGHTNING MAST
 - ⊙ SURGE ARRESTER
 - M ▶ DISCONNECT SWITCH MOTOR OPERATOR
 - G ▶ DISCONNECT SWITCH GROUNDING SWITCH OPERATOR
 - ▶ DISCONNECT SWITCH MANUAL OPERATOR


General Locations of Mobile Substation

PRELIMINARY
NOT TO BE USED FOR CONSTRUCTION

INSTALL
CONCEPTUAL DRAWING
NO CHANGES TO RECORD DOCUMENT

■ INSTALL
■ EXISTING

ANSI D. CAD Drawing. DO NOT REVISE MANUALLY.

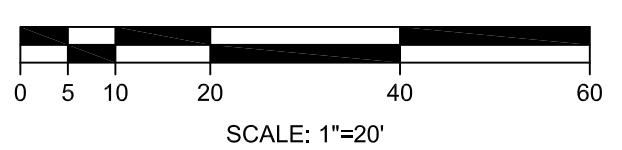

CONTAINS CRITICAL ENERGY INFRASTRUCTURE INFORMATION
SUBJECT TO NON-DISCLOSURE PROVISIONS OF ISO-NE SCHEDULE 22 AND NEW ENGLAND POLICIES PERTAINING TO CONFIDENTIAL INFORMATION (CEI)
DO NOT DISTRIBUTE
DATE OF REVIEW: 9/26/2018 BY: RJS

PE Stamp		AVANGRID ENGINEERING CONFIDENTIAL, PROPRIETARY and TRADE SECRET INFORMATION Property of AVANGRID				UI AVANGRID		SITE PLAN DIMENSIONS SHEET 2 OF 2	
						OLD TOWN		BRIDGEPORT	
						DR. VJP CK. RJS APP. AJO		SCALE: 1" = 20' FILE: SK-25233-003-001 SH2	
						NO.		REV.	
						SK-25233-003-001 SH2		0	
						DATE: 7/29/2019			
						DESCRIPTION			