


WASHINGTON AVE

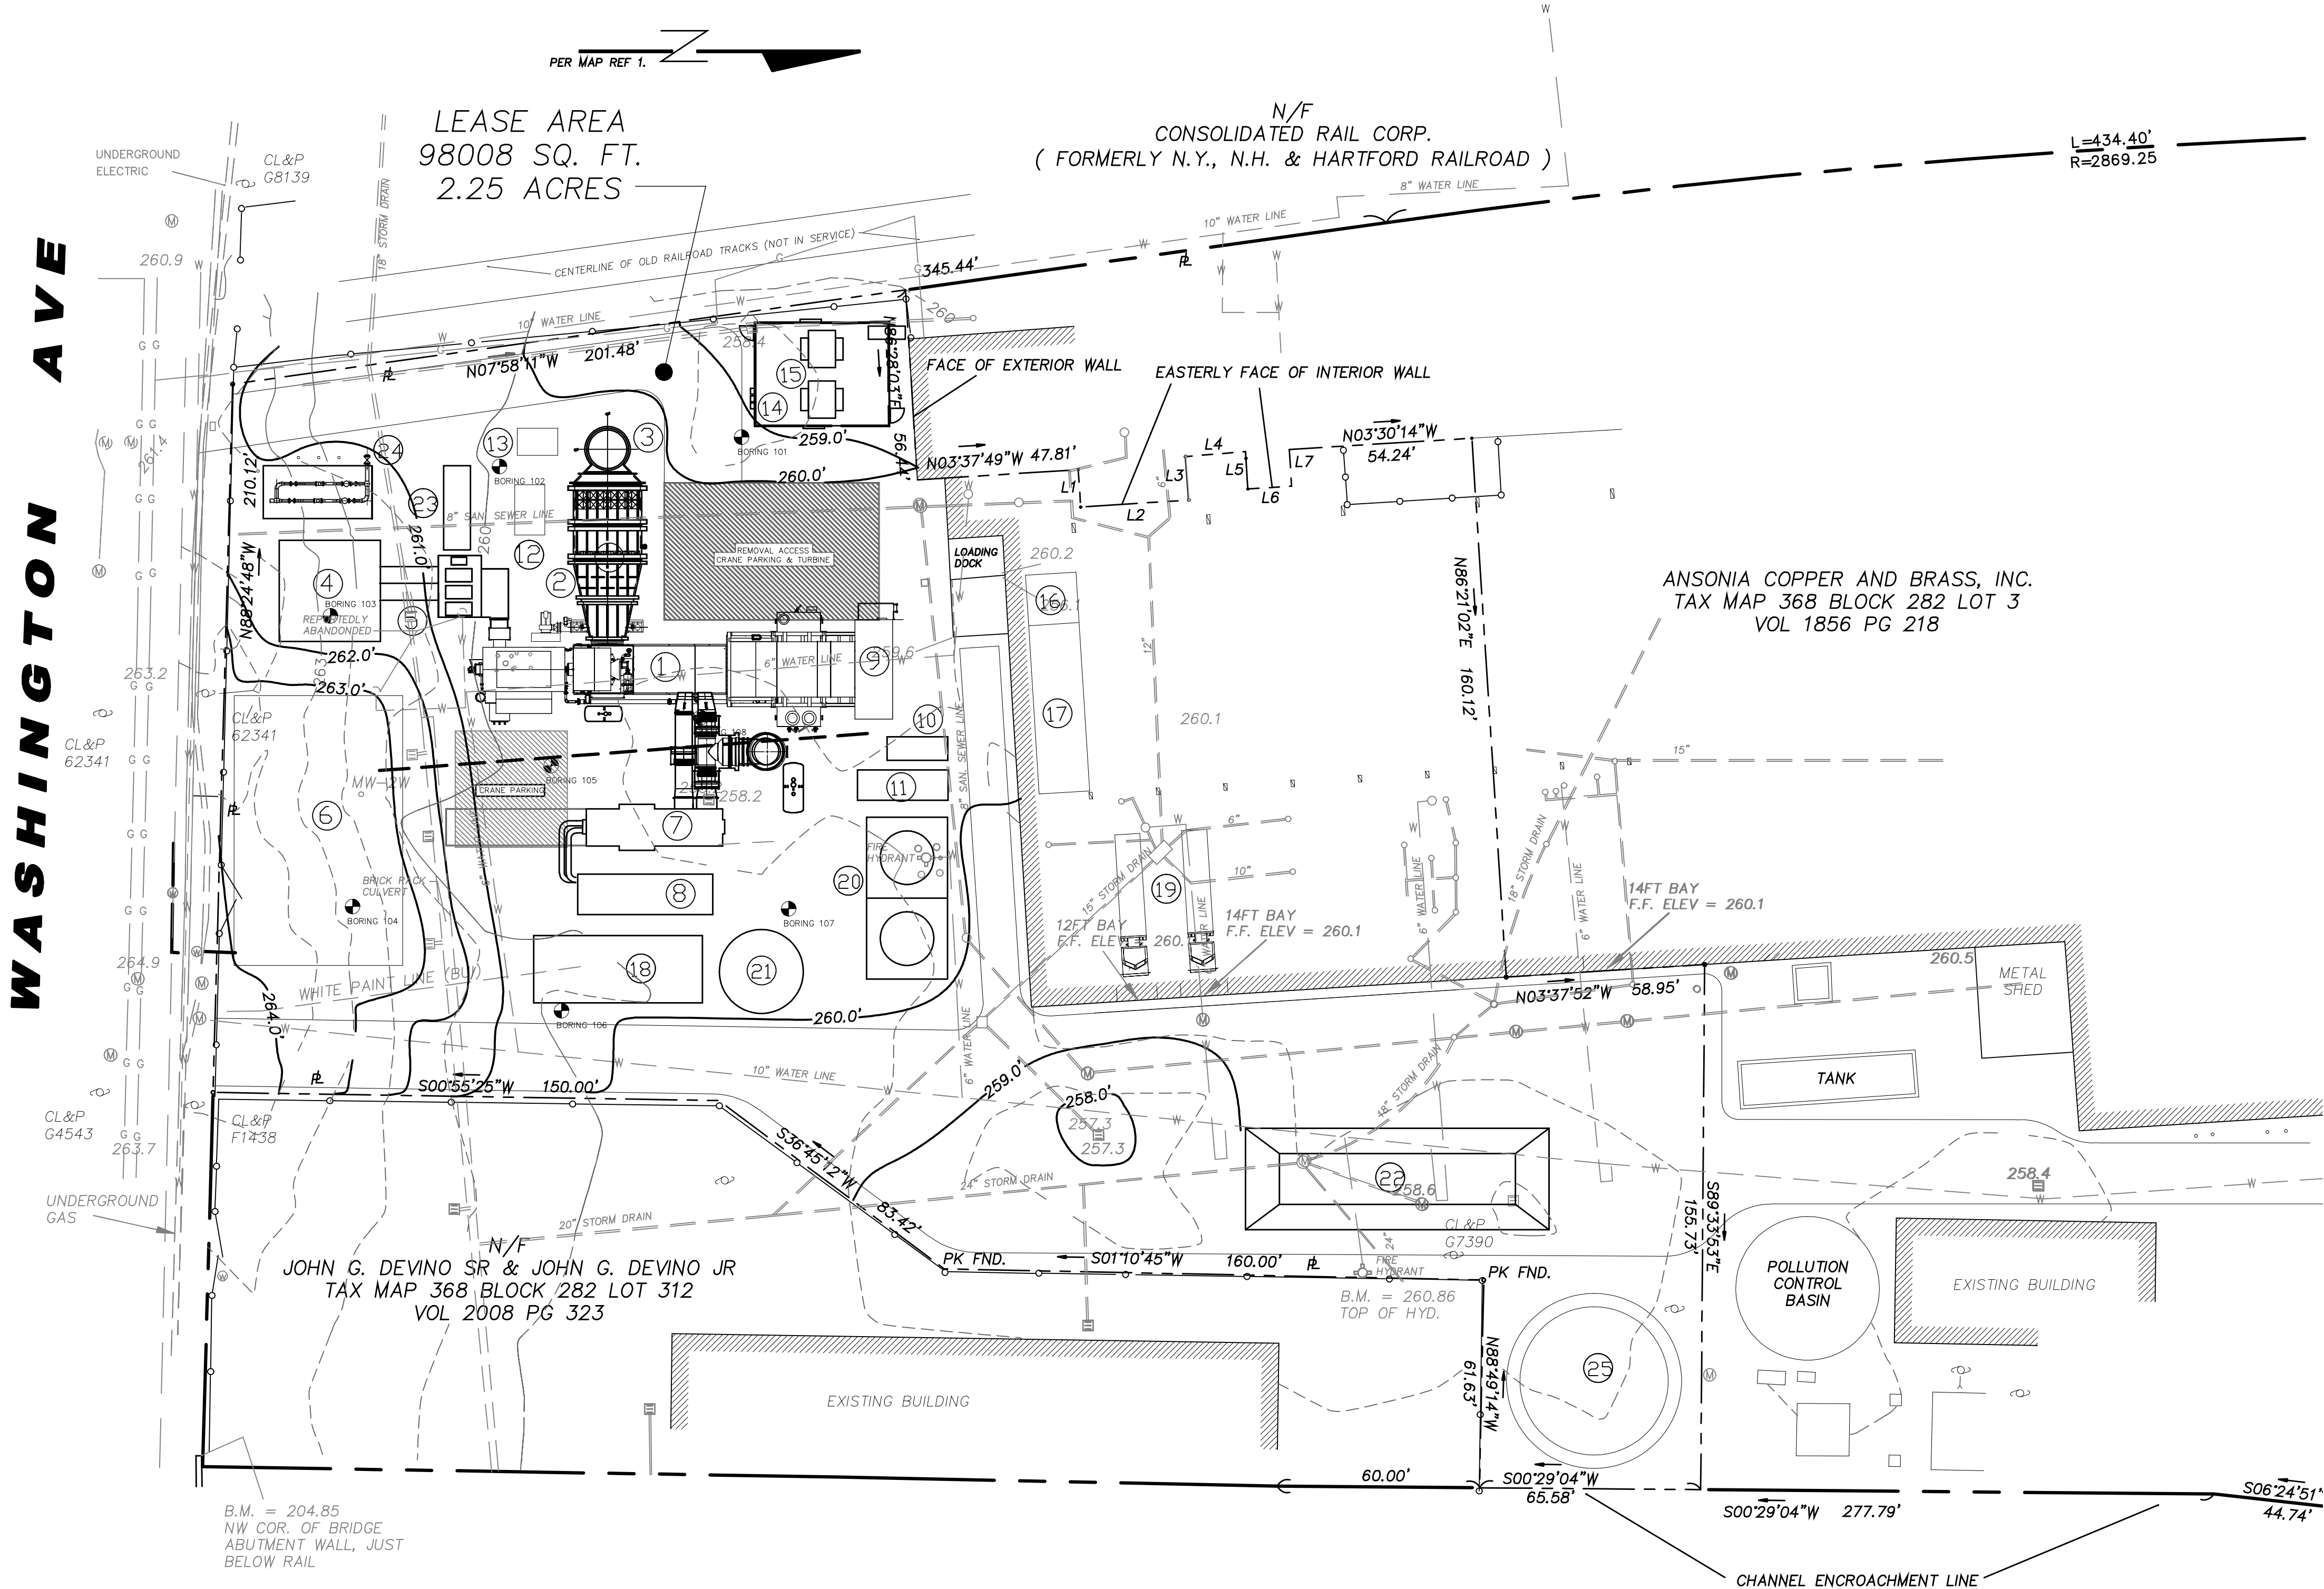

LEGEND

| NO. | DESCRIPTION                                 | NO. | DESCRIPTION                             |
|-----|---------------------------------------------|-----|-----------------------------------------|
| 1.  | LMS100 CTG WITH AIR TO WATER HEAT EXCHANGER | 16. | CONTROL ROOM/ADMINISTRATION AREA        |
| 2.  | SCR/CO REACTOR                              | 17. | POWER CONTROL MODULE                    |
| 3.  | STACK WITH SILENCER                         | 18. | AMMONIA STORAGE TANK                    |
| 4.  | GENERATOR STEP-UP TRANSFORMER               | 19. | DEMIN TRAILER AREA                      |
| 5.  | BUS DUCT                                    | 20. | COOLING TOWER                           |
| 6.  | SWITCHYARD                                  | 21. | DEMIN WATER STORAGE TANK (200,000 GALS) |
| 7.  | LMS100 INTERCOOLER HEAT EXCHANGER           | 22. | FUEL OIL/AMMONIA UNLOADING AREA         |
| 8.  | WATER PUMP SKID                             | 23. | AIR COMPRESSOR                          |
| 9.  | LMS100 CTG AIR INLET                        | 24. | GAS FUEL METERING STATION               |
| 10. | GAS FUEL HEATER/CONDITIONING SKID           | 25. | FUEL OIL STORAGE TANK (364,000 GALS)    |
| 11. | FUEL OIL FILTER SKID                        |     |                                         |
| 12. | SCR AMMONIA INJECTION SKID                  |     |                                         |
| 13. | CEMS BUILDING                               |     |                                         |
| 14. | GAS COMPRESSOR BUILDING                     |     |                                         |
| 15. | GAS COMPRESSOR COOLER, ON TOP OF BLDG       |     |                                         |

LEGEND

- UTILITY POLE
- STEEL COLUMN
- FIRE HYDRANT
- CATCH BASIN
- MANHOLE
- WATER VALVE
- CHAINLINK FENCE
- PROPERTY LINE
- SPOT ELEVATION

| LINE TABLE |        |             |
|------------|--------|-------------|
| LINE       | LENGTH | BEARING     |
| L1         | 11.13  | N86°14'22"E |
| L2         | 32.07  | N03°45'38"W |
| L3         | 12.93  | S85°35'09"W |
| L4         | 17.89  | N04°43'42"W |
| L5         | 11.11  | N86°21'42"E |
| L6         | 13.01  | N03°40'37"W |
| L7         | 10.91  | S86°19'23"W |

NAUGATUCK RIVER

1 PROPOSED OVERALL SITE PLAN  
SCALE: 1"=60'-0"

CONTRACTOR SHALL VERIFY ALL CONDITIONS ON JOB SITE & NOTIFY PROJECT ENGINEER OF ANY VARIATIONS FROM DIMENSIONS SHOWN ON THESE DRAWINGS BEFORE PROCEEDING WITH ANY CONSTRUCTION.

|   |          |    |     |     |                               |
|---|----------|----|-----|-----|-------------------------------|
| A | 9/11/07  | LL | WRS | WRS | PRELIMINARY GRADING PLAN VIEW |
| B | 09/18/07 | SD | WRS | WRS | PRELIMINARY GRADING PLAN VIEW |

| REV | DATE | BY | CHK | APPR | ISSUED FOR |
|-----|------|----|-----|------|------------|
|-----|------|----|-----|------|------------|

NOTICE  
The data in this document incorporates proprietary rights of SIGMA ENERGY SOLUTIONS.  
Any party accepting this document does so in confidence and agrees that it shall not be duplicated in whole or part, nor disclosed to others without the consent of SIGMA ENERGY SOLUTIONS.

|                          |
|--------------------------|
| PRELIMINARY GRADING PLAN |
| REVISIONS PER M.J.F.     |

| REVISION DESCRIPTION |
|----------------------|
|----------------------|

PROJECT ENGINEER

MIKE FARRARO

ENGINEER

W.R. SCHLUMPF

DATE 09/11/07

SCALE AS NOTED

DRAWN L.L.

CHECKED W.R. SCHLUMPF

APPROVED W.R. SCHLUMPF

APPROVED

LILL & DIFAZIO CONSTRUCTORS LLC  
711 Grand Blvd., DEER PARK, NEW YORK 11729



One Huntington Quadrangle Suite 4509  
Melville, NY, 11747



ONE CORPORATE CENTER  
20 CHURCH STREET, HARTFORD, CT 06103

WATERBURY GENERATION LLC  
WATERBURY, CT  
SITE GRADING AND DRAINAGE PLAN

ORIGINAL SIZE: 24"x36"  
PROJECT NO. 55107

DOCUMENT ID.

C-102

SHEET 1 OF 1

