


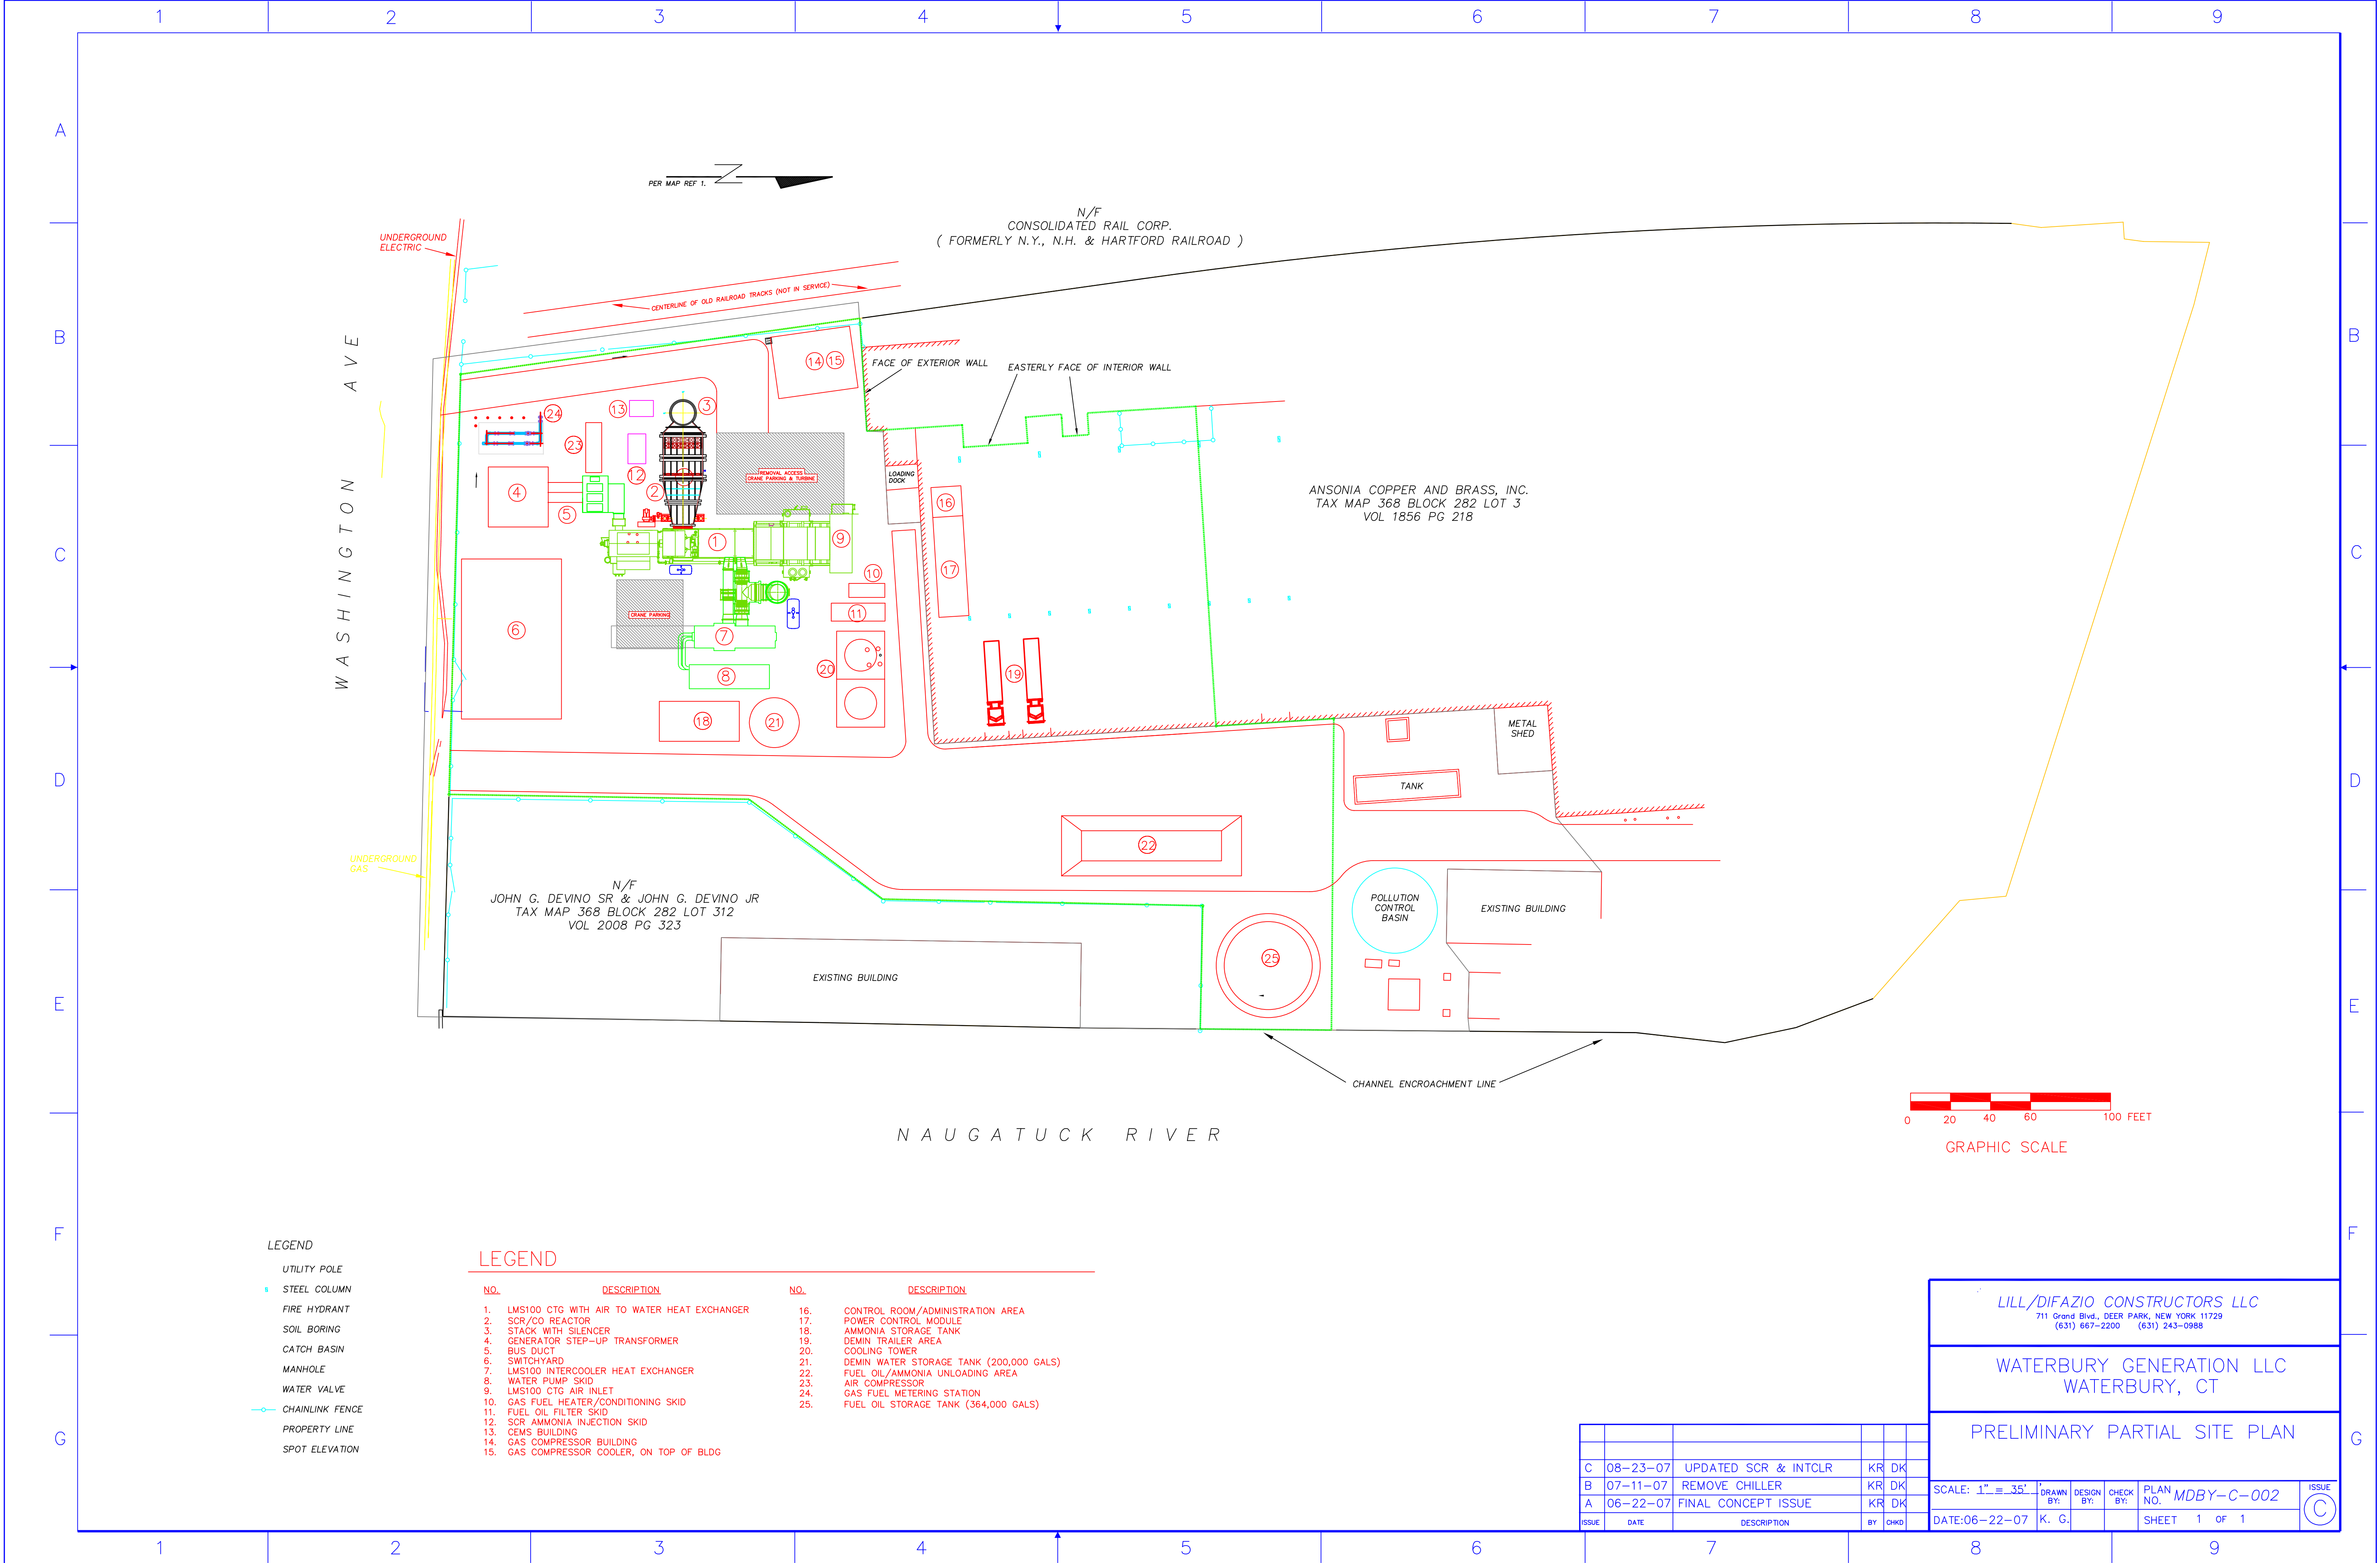

LEGEND

- UTILITY POLE
- STEEL COLUMN
- FIRE HYDRANT
- SOIL BORING
- CATCH BASIN
- MANHOLE
- WATER VALVE
- CHAINLINK FENCE
- PROPERTY LINE
- SPOT ELEVATION

LEGEND

NO.	DESCRIPTION	NO.	DESCRIPTION
1.	LMS100 CTG WITH AIR TO WATER HEAT EXCHANGER	16.	CONTROL ROOM/ADMINISTRATION AREA
2.	SCR/CO REACTOR	17.	POWER CONTROL MODULE
3.	STACK WITH SILENCER	18.	AMMONIA STORAGE TANK
4.	GENERATOR STEP-UP TRANSFORMER	19.	DEMIN TRAILER AREA
5.	BUS DUCT	20.	COOLING TOWER
6.	SWITCHYARD	21.	DEMIN WATER STORAGE TANK (200,000 GALS)
7.	LMS100 INTERCOOLER HEAT EXCHANGER	22.	FUEL OIL/AMMONIA UNLOADING AREA
8.	WATER PUMP SKID	23.	AIR COMPRESSOR
9.	LMS100 CTG AIR INLET	24.	GAS FUEL METERING STATION
10.	GAS FUEL HEATER/CONDITIONING SKID	25.	FUEL OIL STORAGE TANK (364,000 GALS)
11.	FUEL OIL FILTER SKID		
12.	SCR AMMONIA INJECTION SKID		
13.	CEMS BUILDING		
14.	GAS COMPRESSOR BUILDING		
15.	GAS COMPRESSOR COOLER, ON TOP OF BLDG		

ISSUE	DATE	DESCRIPTION	BY	CHKD
C	08-23-07	UPDATED SCR & INTCLR	KR	DK
B	07-11-07	REMOVE CHILLER	KR	DK
A	06-22-07	FINAL CONCEPT ISSUE	KR	DK

LILL/DIFAZIO CONSTRUCTORS LLC 711 Grand Blvd., DEER PARK, NEW YORK 11729 (631) 667-2200 (631) 243-0988					
WATERBURY GENERATION LLC WATERBURY, CT					
PRELIMINARY PARTIAL SITE PLAN					
SCALE: 1" = 35'	DRAWN BY: K. G.	DESIGN BY:	CHECK BY:	PLAN NO. MDY-C-002	ISSUE
DATE: 06-22-07				SHEET 1 OF 1	C