

THOMAS J. REGAN
Direct Dial: (860) 509-6522
tregan@brownrudnick.com




CityPlace I
185 Asylum
Street
Hartford
Connecticut
06103
tel 860.509.6500
fax 860.509.6501

Via Hand Delivery

November 11, 2010

Daniel F. Caruso, Chairman
Connecticut Siting Council
10 Franklin Square
New Britain, CT 06051

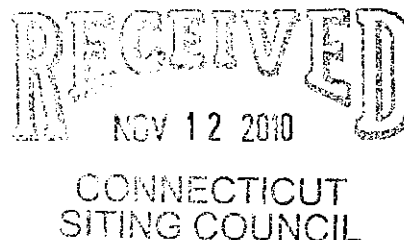

**RE: Clear Wireless, LLC – Tower Sharing Application
2189 Black Rock Turnpike in Fairfield
Modified Site Plan**

Dear Mr. Caruso:

Clear Wireless, LLC ("Clearwire") filed its Tower Sharing Application to locate its installation on the existing flagpole located at 2189 Black Rock Turnpike in Fairfield with the Connecticut Siting Council ("Council") on August 31, 2010. In response to concerns raised by the Council and its staff Clearwire has revised its proposed installation. On behalf of Clearwire, enclosed please find 21 copies of the modified site plan, dated November 9, 2010.

Clearwire proposes to conceal its antennas on the flagpole behind a shroud in order to decrease the visual effect of its installation. Clearwire proposes modify its original shroud design by reducing its size. The size of the original shroud was 10-feet by 5-feet (10' by 5'), and Clearwire proposes to reduce the shroud design to 5 feet by 3 feet, 8 inches (5' by 3' 8"). The reduced size of the modified shroud will be achieved by removing three (3) of Clearwire's proposed dishes from its original design. The modified design decreases the visual effect of Clearwire's installation.

If you have any questions, please feel free to contact me.

Very truly yours,

BROWN RUDNICK LLP

By: Thomas J. Regan
Thomas J. Regan

Enclosures

cc w/encl: Ken Flatto, First Selectman, Town of Fairfield
Joe Devonshuk, Planning Director, Town of Fairfield

40278939 v1 - 025064/0017

clearwire

4400 CARILLON POINT
KIRKLAND, WA 98033

TRANSCEND WIRELESS, LLC
10 INDUSTRIAL AVENUE
MAHWAH, NJ 07430

A&E FIRM

NES CORPORATION A/E

500 ENTERPRISE DRIVE, SUITE 3B
ROCKY HILL, CONNECTICUT
1-(860)-529-8882

11/09/10	REVISED	UES PJS ICA
09/24/10	REVISED	UES PJS ICA
09/18/10	REVISED	BAL PJS ICA
09/10/10	REVISED	KAP JCF ICA
09/03/10	REVISED	KAP JCF ICA
08/19/09	FINAL	PO JCF ICA
10/07/09	REVIEW	PO JCF ICA
NO.	DATE	REVISIONS
DESIGNED BY:	PJS	CHK:APP'D
NOT TO SCALE	DESIGNED BY:	PO
	DRAWN BY:	PO

A&E SEAL

FAIRFIELD 2
CT-BDR0066
2189 BLACK ROCK
TURNPIKE
FAIRFIELD, CT
06430

PROJECT NO.

TW3-008
36924371

DRAWING NAME

SC-1

DATE


11/09/10

SHEET NO.

REV

1 OF 2

4

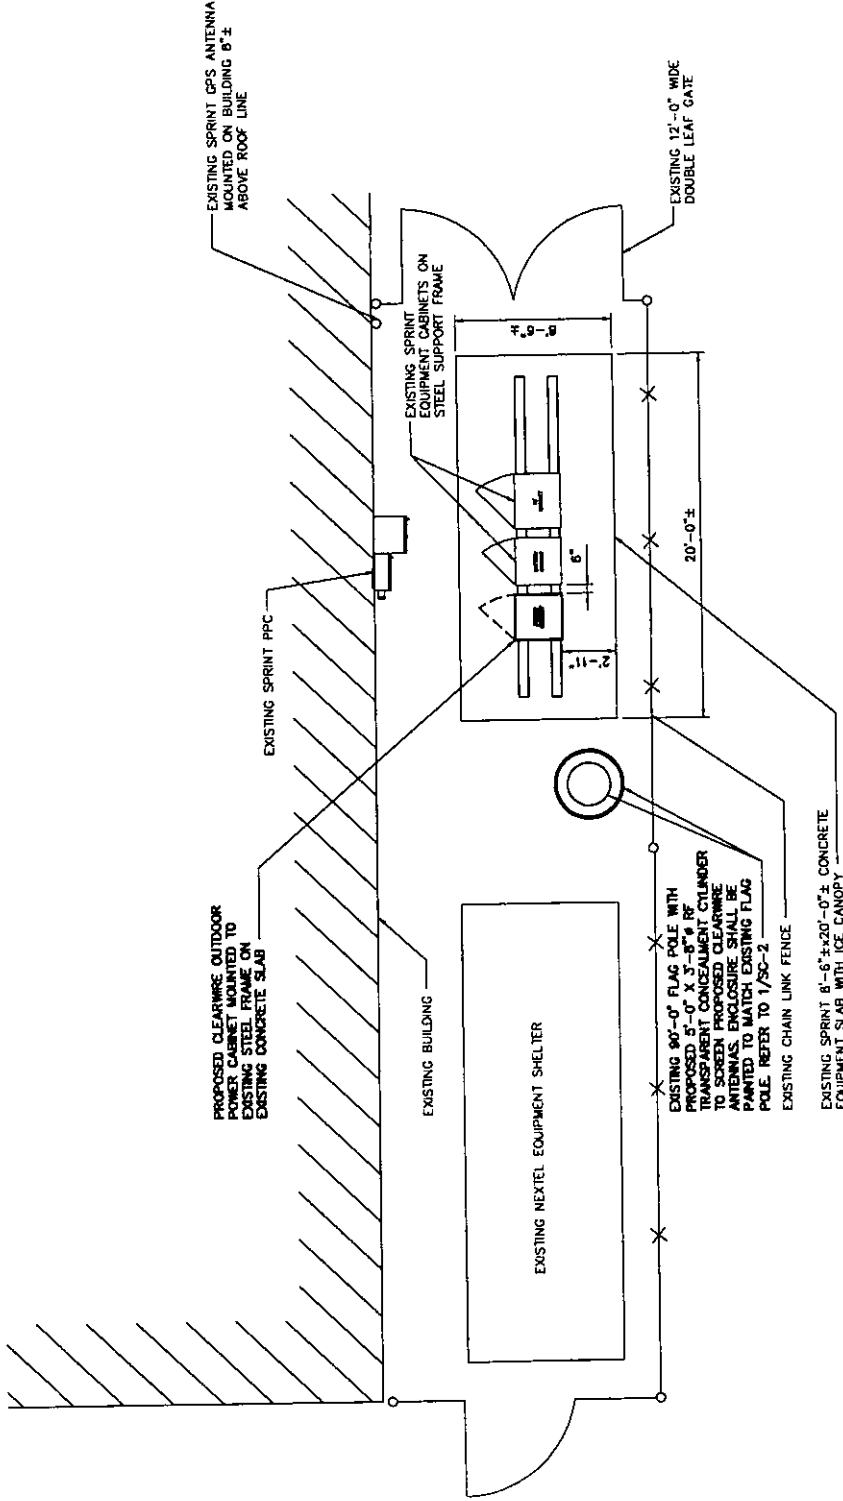

1
SC-1

COMPOUND PLAN

SCALE: 1" = 10'-0"

1400 CARILLON POINT
KIRKLAND, WA 98033

TRANSCEND WIRELESS, LLC
10 INDUSTRIAL AVENUE
MAHWAH, NJ 07430

AGE FIRM

MRS. COMPTON ALES


500 ENTERPRISE DRIVE, SUITE 3B
ROCKY HILL, CONNECTICUT
1-(860)-529-8882

NO.	DATE	REVISIONS	BY	CHK	APP'D
NOT TO SCALE	DESIGNED BY: PJS	DRAWN BY: PD			
1	11/09/10	REVISED	JES	PJS	ICA
2	08/24/10	REVISED	JES	PJS	ICA
3	6/16/10	REVISED	BAL	PJS	ICA
4	5/18/10	REVISED	KAP	JCF	ICA
5	2/20/10	REVISED	KAP	JCF	ICA
6	10/19/09	FINAL	KAP	JCF	ICA
7	10/01/09	REVIEW	NO	JCF	ICA

WAF SEAL

FAIRFIELD 2
CT-BDR0066
2189 BLACK ROCK
TURNPIKE
FAIRFIELD, CT
06430

PROJECT NO.	DRAWING NAME	DATE	SHEET NO.	REV
TW3-008	SC-2	11/09/10	2 OF 2	4
35924371				

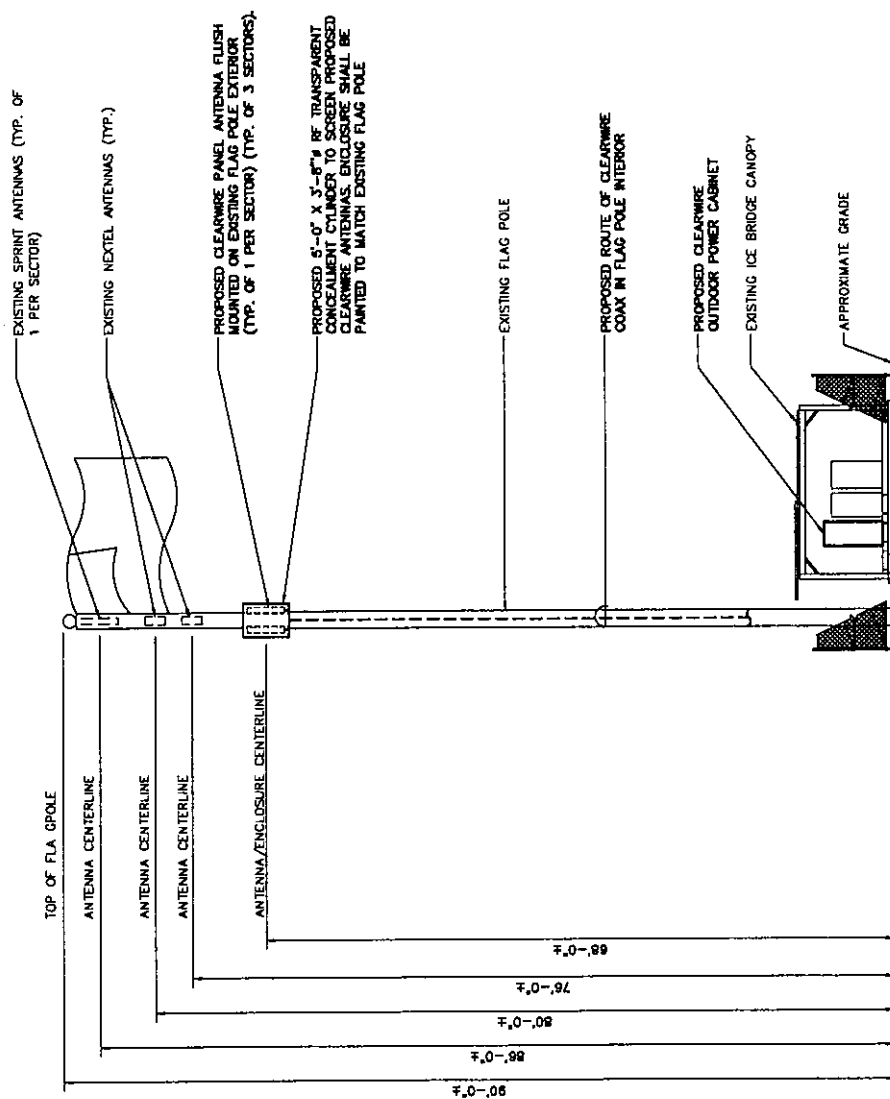

1 FLAGPOLE ELEVATION
SC-2 SCALE: 1" = 20'-0"