

STATE OF CONNECTICUT DEPARTMENT OF HOUSING

Community Development Block Grant
Disaster Recovery Program
Project: B-13-DS-09-001

Merritt Construction Services, Inc.
1177 High Ridge Road
Stamford, Connecticut 06905

Applicant Number 1260
35 Harbor View Avenue
Norwalk, Connecticut 06854

CODES:

THE DESIGN AND CONSTRUCTION DOCUMENTS PROVIDED WERE PREPARED IN ACCORDANCE WITH THE FOLLOWING CODES:
THE 2009 INTERNATIONAL RESIDENTIAL CODE AS MODIFIED BY:
2009 AND 2013 AMENDMENT TO THE STATE OF CONNECTICUT BUILDING CODE
2009 INTERNATIONAL ENERGY CONSERVATION CODE
2011 AMENDMENT TO THE 2009 INTERNATIONAL ENERGY CODE
2008 CONNECTICUT STATE FIRE SAFETY CODE AND
2009 AMENDMENT TO THE CONNECTICUT FIFE SAFETY CODE
2003 INTERNATIONAL PLUMBING CODE
2003 INTERNATIONAL MECHANICAL CODE
2011 NATIONAL ELECTRICAL CODE

DRAWING LIST:

T-1.0	TITLE SHEET
SE-1	SITE PLAN
ZLS	ZONING LOCATION SURVEY
A-1.0	FOUNDATION & FIRST FLOOR PLAN
A-2.0	SECOND FLOOR PLAN
A-3.0	ELEVATIONS
A-4.0	ELEVATIONS
S0	GENERAL STRUCTURAL NOTES
S1	STRUCTURAL FLOOR PLANS
S2	STRUCTURAL DETAILS
DE-1.0	ELECTRICAL DEMOLITION PLAN
DM-1.0	MECHANICAL DEMOLITION PLAN
DP-1.0	PLUMBING DEMOLITION PLAN
E-1.0	ELECTRICAL PLAN
E-2.0	ELECTRICAL NOTES
M-1.0	MECHANICAL PLAN
P-1.0	PLUMBING PLAN

NOT FOR
CONSTRUCTION

Revisions	Date
Review	11.11.14
Norwalk P&Z	12.15.14
Submittal	
Bid Set	01.20.15
Bid Set	03.03.15
Bid Set	04.16.15




© ARIS CRIST AIA 2015.
THIS TECHNICAL DRAWING AND THE
ARCHITECTURAL WORK DEPICTED ARE
COPYRIGHTED BY
ARIS CRIST AIA

Aris Crist Architects
34 East Putnam Avenue
Greenwich, Connecticut 06830
203 661 0661

APPLICANT No. 1260	TITLE
35 HARBOR VIEW AVENUE NORWALK CT, 06854	

Drawn	
L.F.O.	Checked
Date	
10.27.14	Scale
AS NOTED	Job Number
Sheet	
T-1.0	

DISTRICT: 5
BLOCK: 85C
LOT: 85
ZONE: B RES.

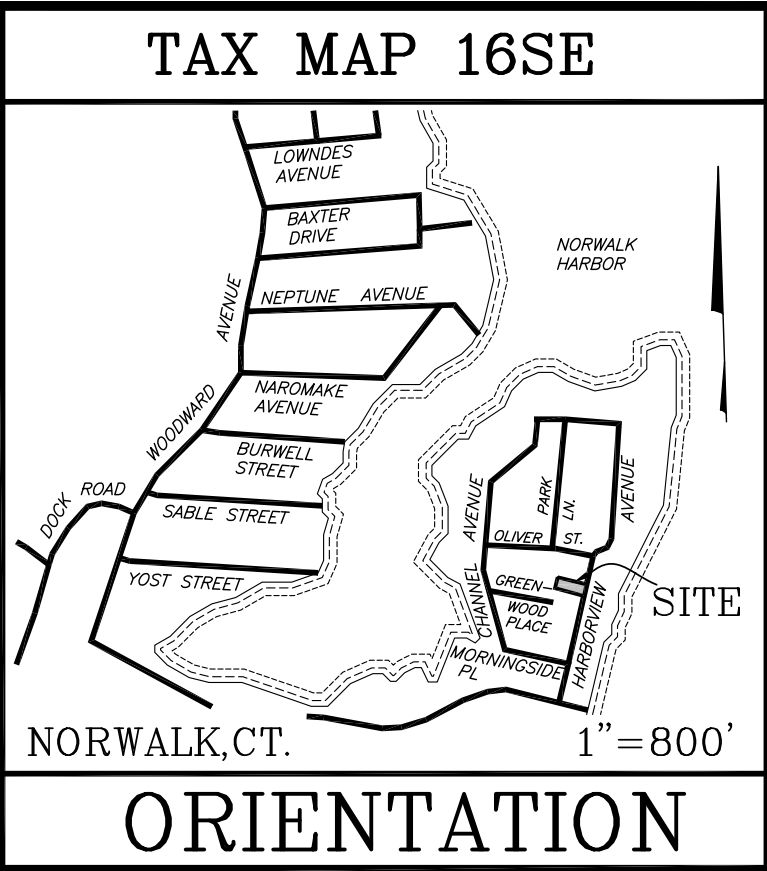


NOTES:

1. This survey has been prepared in accordance with Sections 20-300b-1 thru 20-300b-20 of the Regulations of Connecticut State Agencies and the Standards for Surveys and Maps in the State of Connecticut as adopted by the Connecticut Association of Land Surveyors, Inc. as an zoning Location Survey the Boundary Determination Category of which is a Resurvey conforming to Horizontal Accuracy Class A-2 and Vertical Accuracy Class V-2 intended to be used for verification of zoning compliance with respect to the location of improvements depicted hereon.
2. Total area of the surveyed parcel = 4,000 SF or 0.0918 Acres
3. Building Area = 694 SF or 17.4%
4. Reference is made to Maps Lot 13 and the southerly 5' of Lot 14 on Map 252 and to Map 255 of Norwalk Land Records (NLR).
5. Reference is made to Deed found in Volume 2797 at Page 208 N.L.R.
6. Reference is made to restrictions found in Vol. 118, Pg. 727 N.L.R.
7. Owner of record is Allison A. Allen.
CT Department of Housing Community Development Block Grant - Disaster Recovery Applicant #1260
8. Elevations depicted hereon are based on North American Vertical Datum of 1988 (NAVD-88).
9. Reference is made to benchmark CGS 456.
10. Reference is made to FEMA Flood Insurance Rate Map Panel No. 533 of 626, Map No. 09001C0533G, Map Revised July 8, 2013. Subject Parcel lies within Special Flood Hazard Area Zone AE (EL 13). 500 year flood elevation calculated to be 16.25 pursuant to FEMA Technical Fact Sheet No. 1.6.
11. Reference is made to Board of Appeals, application for variation of building zone regulations dated October 7, 1947.

ZONING LOCATION SURVEY
DEPICTING
PROPOSED IMPEOVMMWNTS
#35 HARBOR VIEW AVENUE
NORWALK, CONNECTICUT
PREPARED FOR
MERRITT CONSTRUCTION
SERVICES, INC.

7886_ZLS.dwg

JOB NO.:	7886-1	DATE:	12/17/2014
DRAWN BY:	CJV/BDH/KAJ	CHECKED BY:	
SCALE:	1" = 10'		

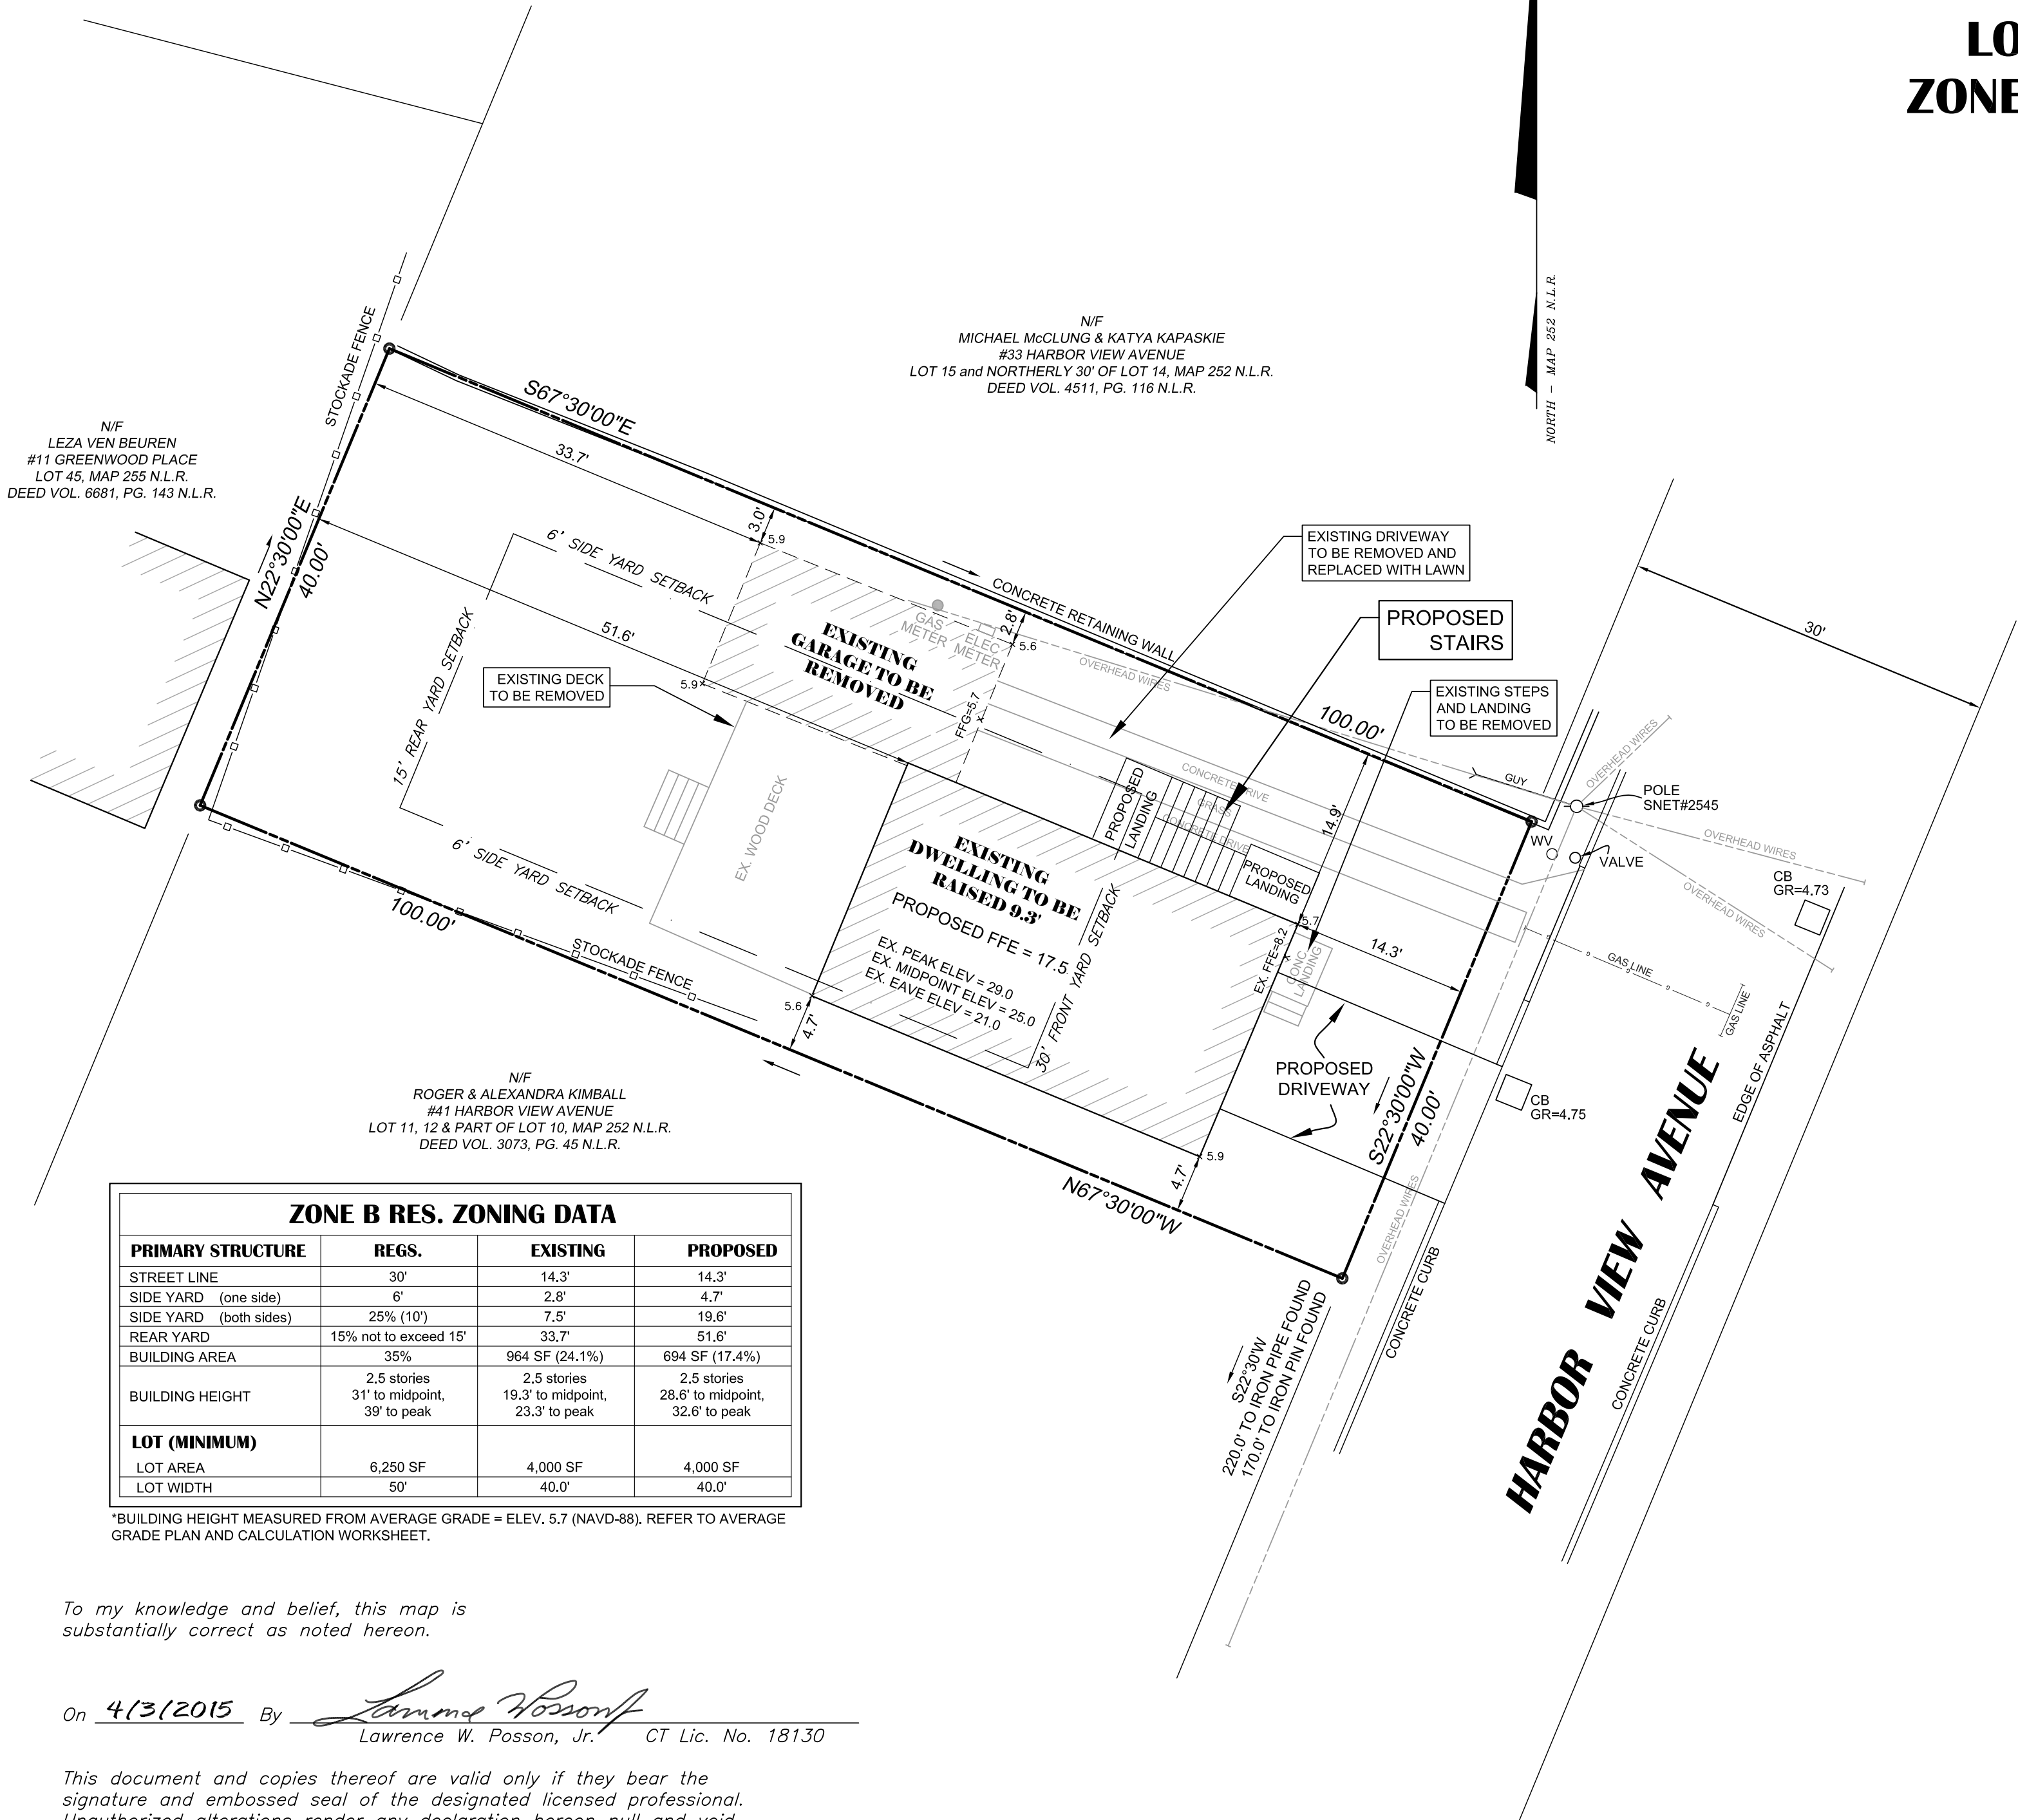


ZONE B RES. ZONING DATA			
PRIMARY STRUCTURE	REGS.	EXISTING	PROPOSED
STREET LINE	30'	14.3'	14.3'
SIDE YARD (one side)	6'	2.8'	4.7'
SIDE YARD (both sides)	25% (10')	7.5'	19.6'
REAR YARD	15% not to exceed 15'	33.7'	51.6'
BUILDING AREA	35%	964 SF (24.1%)	694 SF (17.4%)
BUILDING HEIGHT	2.5 stories 31' to midpoint, 39' to peak	2.5 stories 19.3' to midpoint, 23.3' to peak	2.5 stories 28.6' to midpoint, 32.6' to peak
LOT (MINIMUM)			
LOT AREA	6,250 SF	4,000 SF	4,000 SF
LOT WIDTH	50'	40.0'	40.0'

*BUILDING HEIGHT MEASURED FROM AVERAGE GRADE = ELEV. 5.7 (NAVD-88). REFER TO AVERAGE GRADE PLAN AND CALCULATION WORKSHEET.

To my knowledge and belief, this map is substantially correct as noted hereon.

On 4/3/2015 By Lawrence W. Posson, Jr. CT Lic. No. 18130

This document and copies thereof are valid only if they bear the signature and embossed seal of the designated licensed professional. Unauthorized alterations render any declaration hereon null and void.

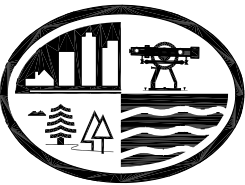


Redniss & Mead


ENGINEERS · SURVEYORS · PLANNERS · WWW.REDNISSMEAD.COM
ESTABLISHED 1957 22 FIRST STREET · STAMFORD, CONNECTICUT 06905 · 203-327-0500

REVISED 4/3/2015: REMOVED DECK


PAINT SPECS:
SHERWIN WILLIAMS PRO MAR 400
CEILINGS, 1 COAT PRIMER, CEILING WHITE 2 COAT, FLAT
WALLS, 1 COAT PRIMER , 2 COATS BONE WHITE FLAT
TRIM & DOORS, 1 COAT PRIMER, BRITE WHITE SEMI GLOSS, 2 COATS

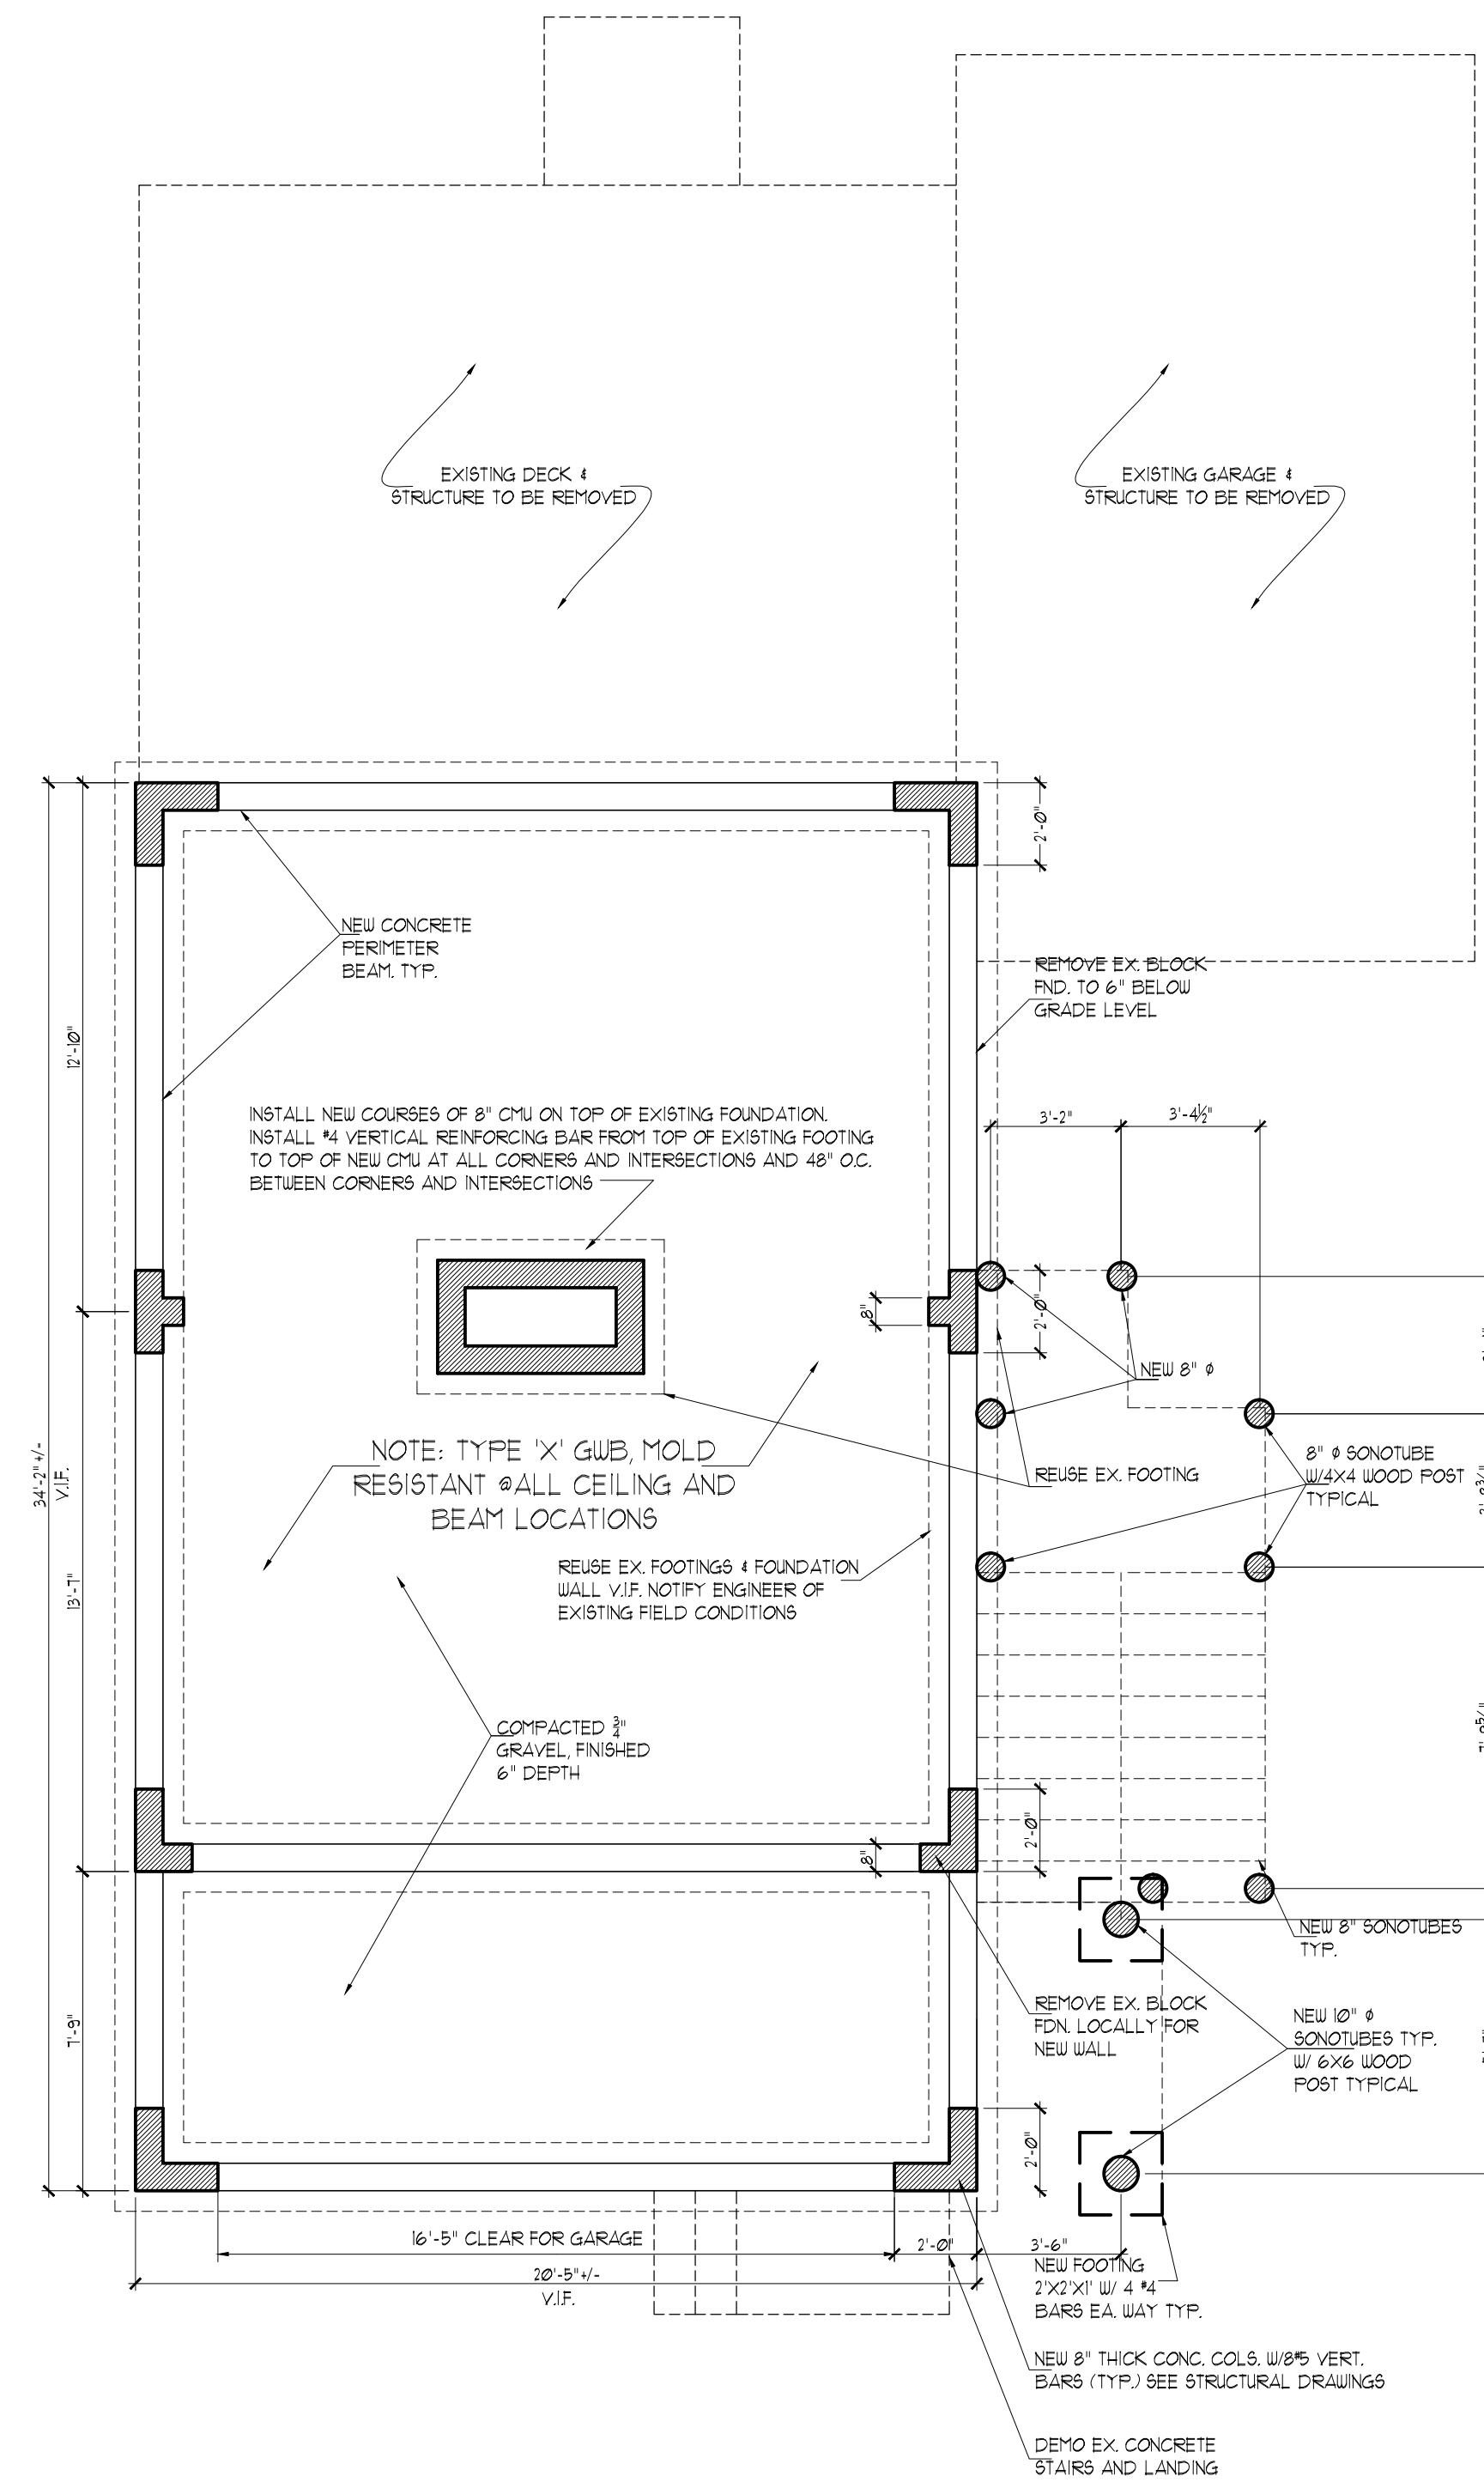


FOUNDATION PLAN
SCALE: 1/4"=1'-0"

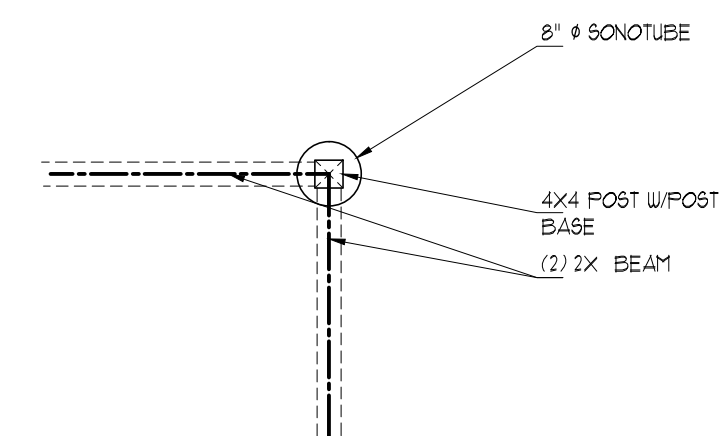

TYPICAL DETAIL
@ 8" Ø SONOTUBE
SCALE: $\frac{1}{2}" = 1'-0"$

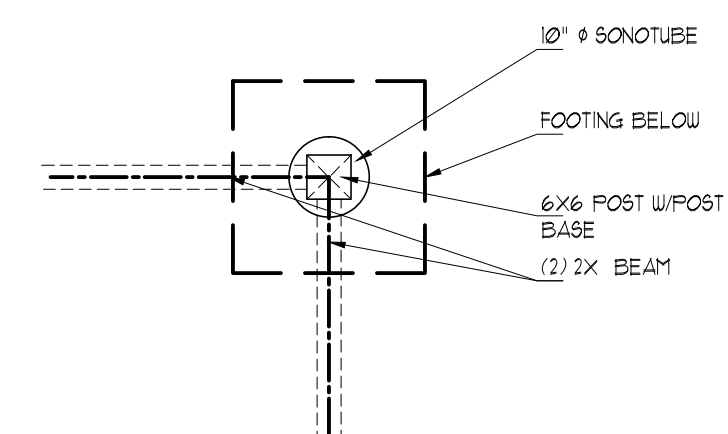

TYPICAL DETAIL
@ 10" Ø SONOTUBE
SCALE: $\frac{1}{2}"=1'-0"$

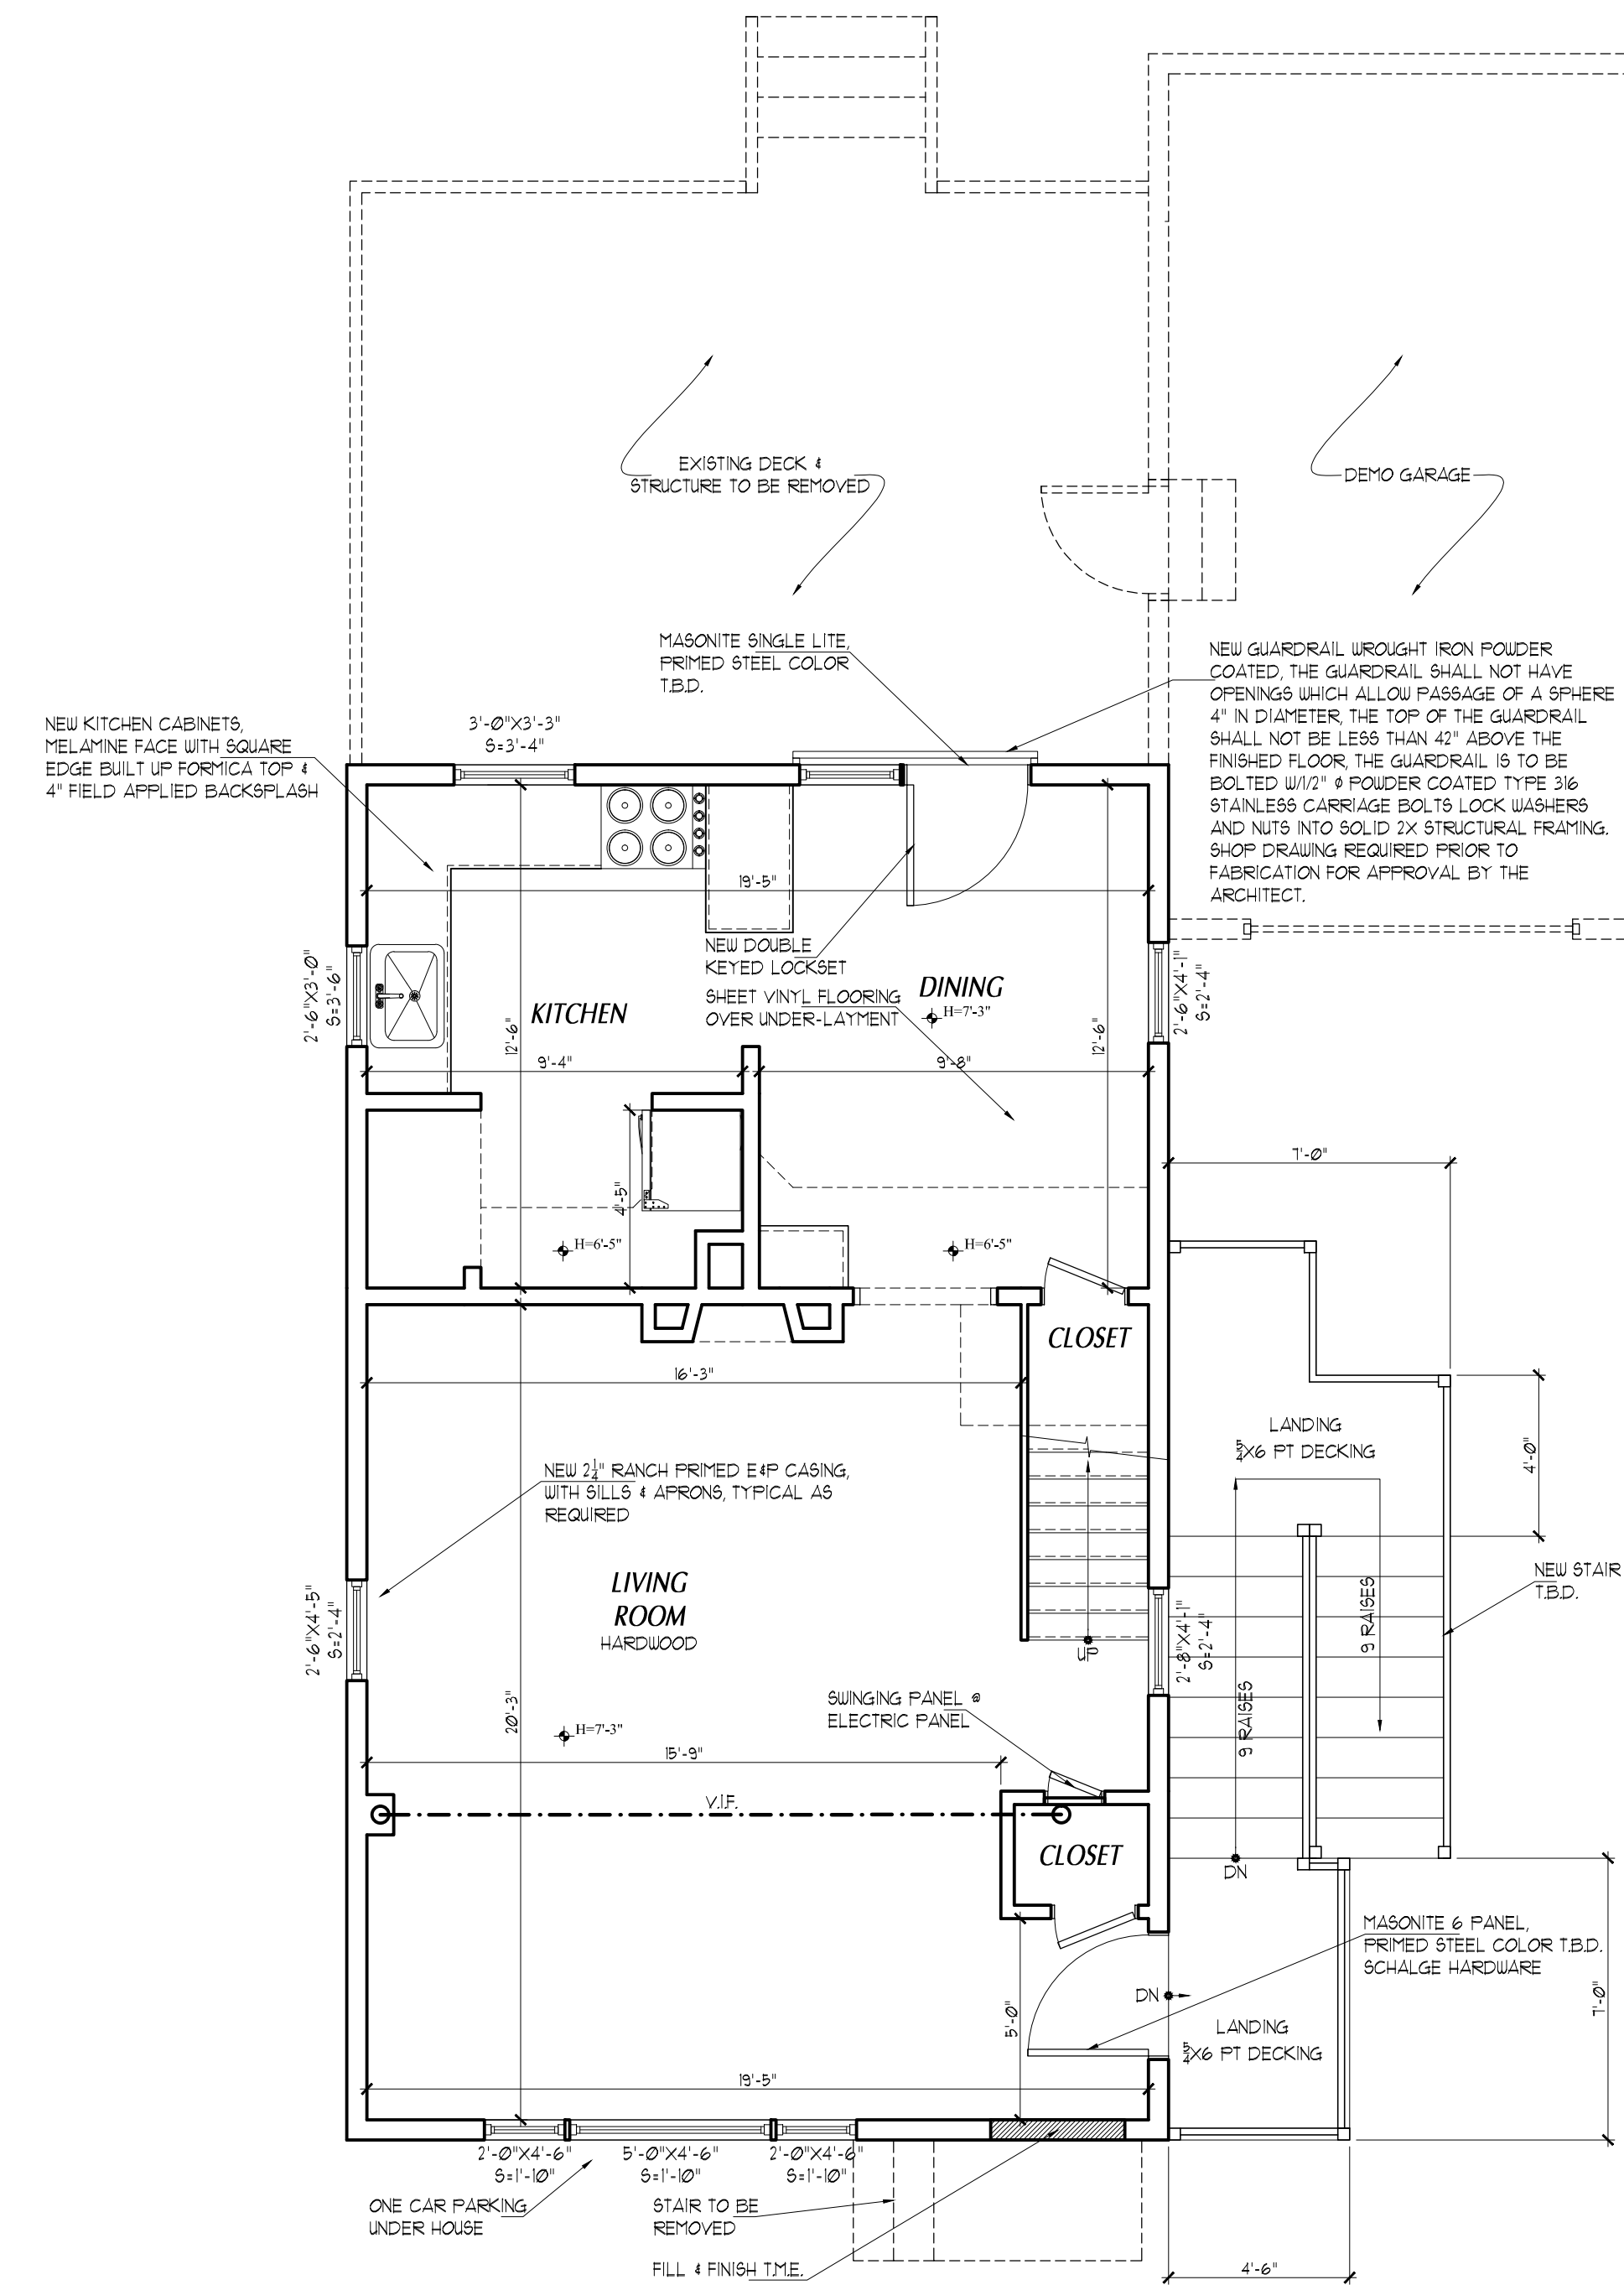

FIRST FLOOR PLAN
SCALE: 1/4"=1'-0"

Revisions	Date
Review	11.11.14
Norwalk P&Z Submittal	12.15.14
Bid Set	01.20.15
Bid Set	03.03.15
Bid Set	04.16.15

© ARIS CRIST AIA 2015.
THIS TECHNICAL DRAWING AND THE
ARCHITECTURAL WORK DEPICTED ARE
COPYRIGHTED BY
ARIS CRIST AIA

Aris Crist Architects

34 East Putnam Avenue
Greenwich, Connecticut 06830
203 661 0661

APPLICANT No. 1260


35 HARBOR VIEW AVENUE
NORWALK CT, 06854

Drawn
L.F.O.
Checked
Date
10.27.14
Scale
AS NOTED
Job Number
Sheet


**NOT FOR
CONSTRUCTION**

A-1.0

PAINT SPECS:
SHERWIN WILLIAMS PRO MAR 400
CEILINGS, 1 COAT PRIMER, CEILING WHITE 2 COAT, FLAT
WALLS, 1 COAT PRIMER , 2 COATS BONE WHITE FLAT
TRIM & DOORS, 1 COAT PRIMER, BRITE WHITE SEMI GLOSS, 2 COATS

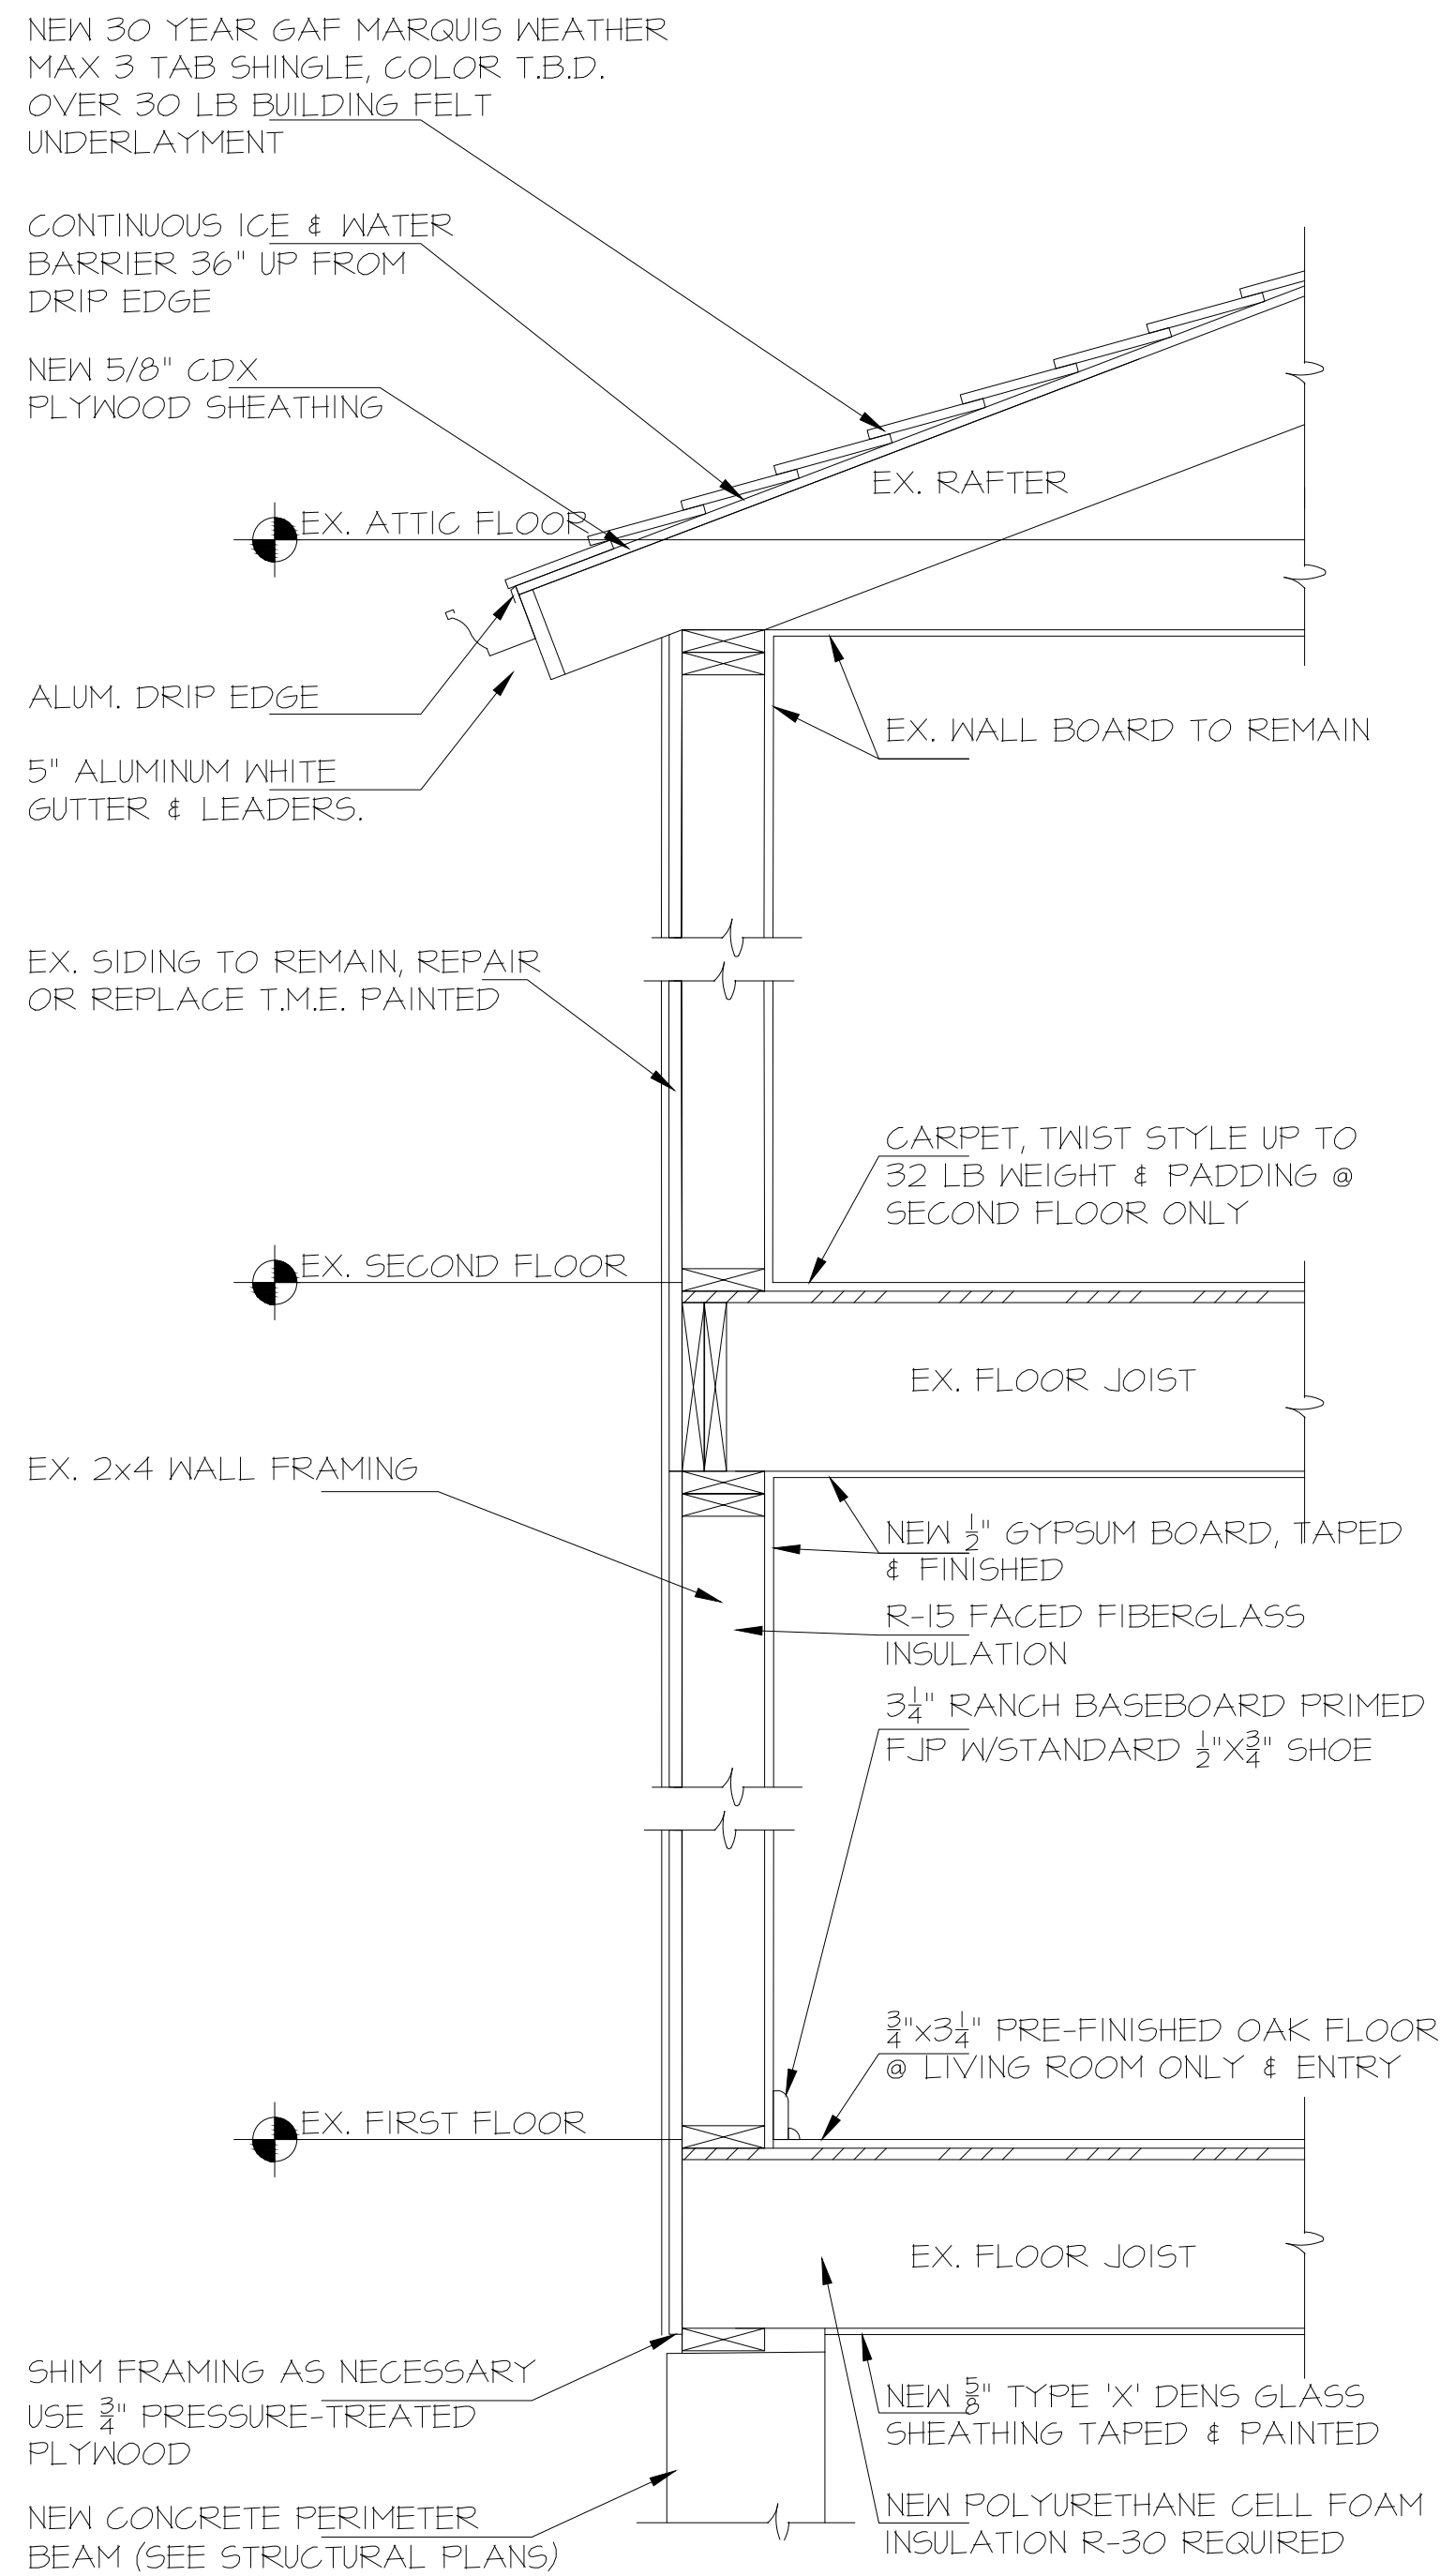

TYPICAL WALL SECTION
NOT TO SCALE

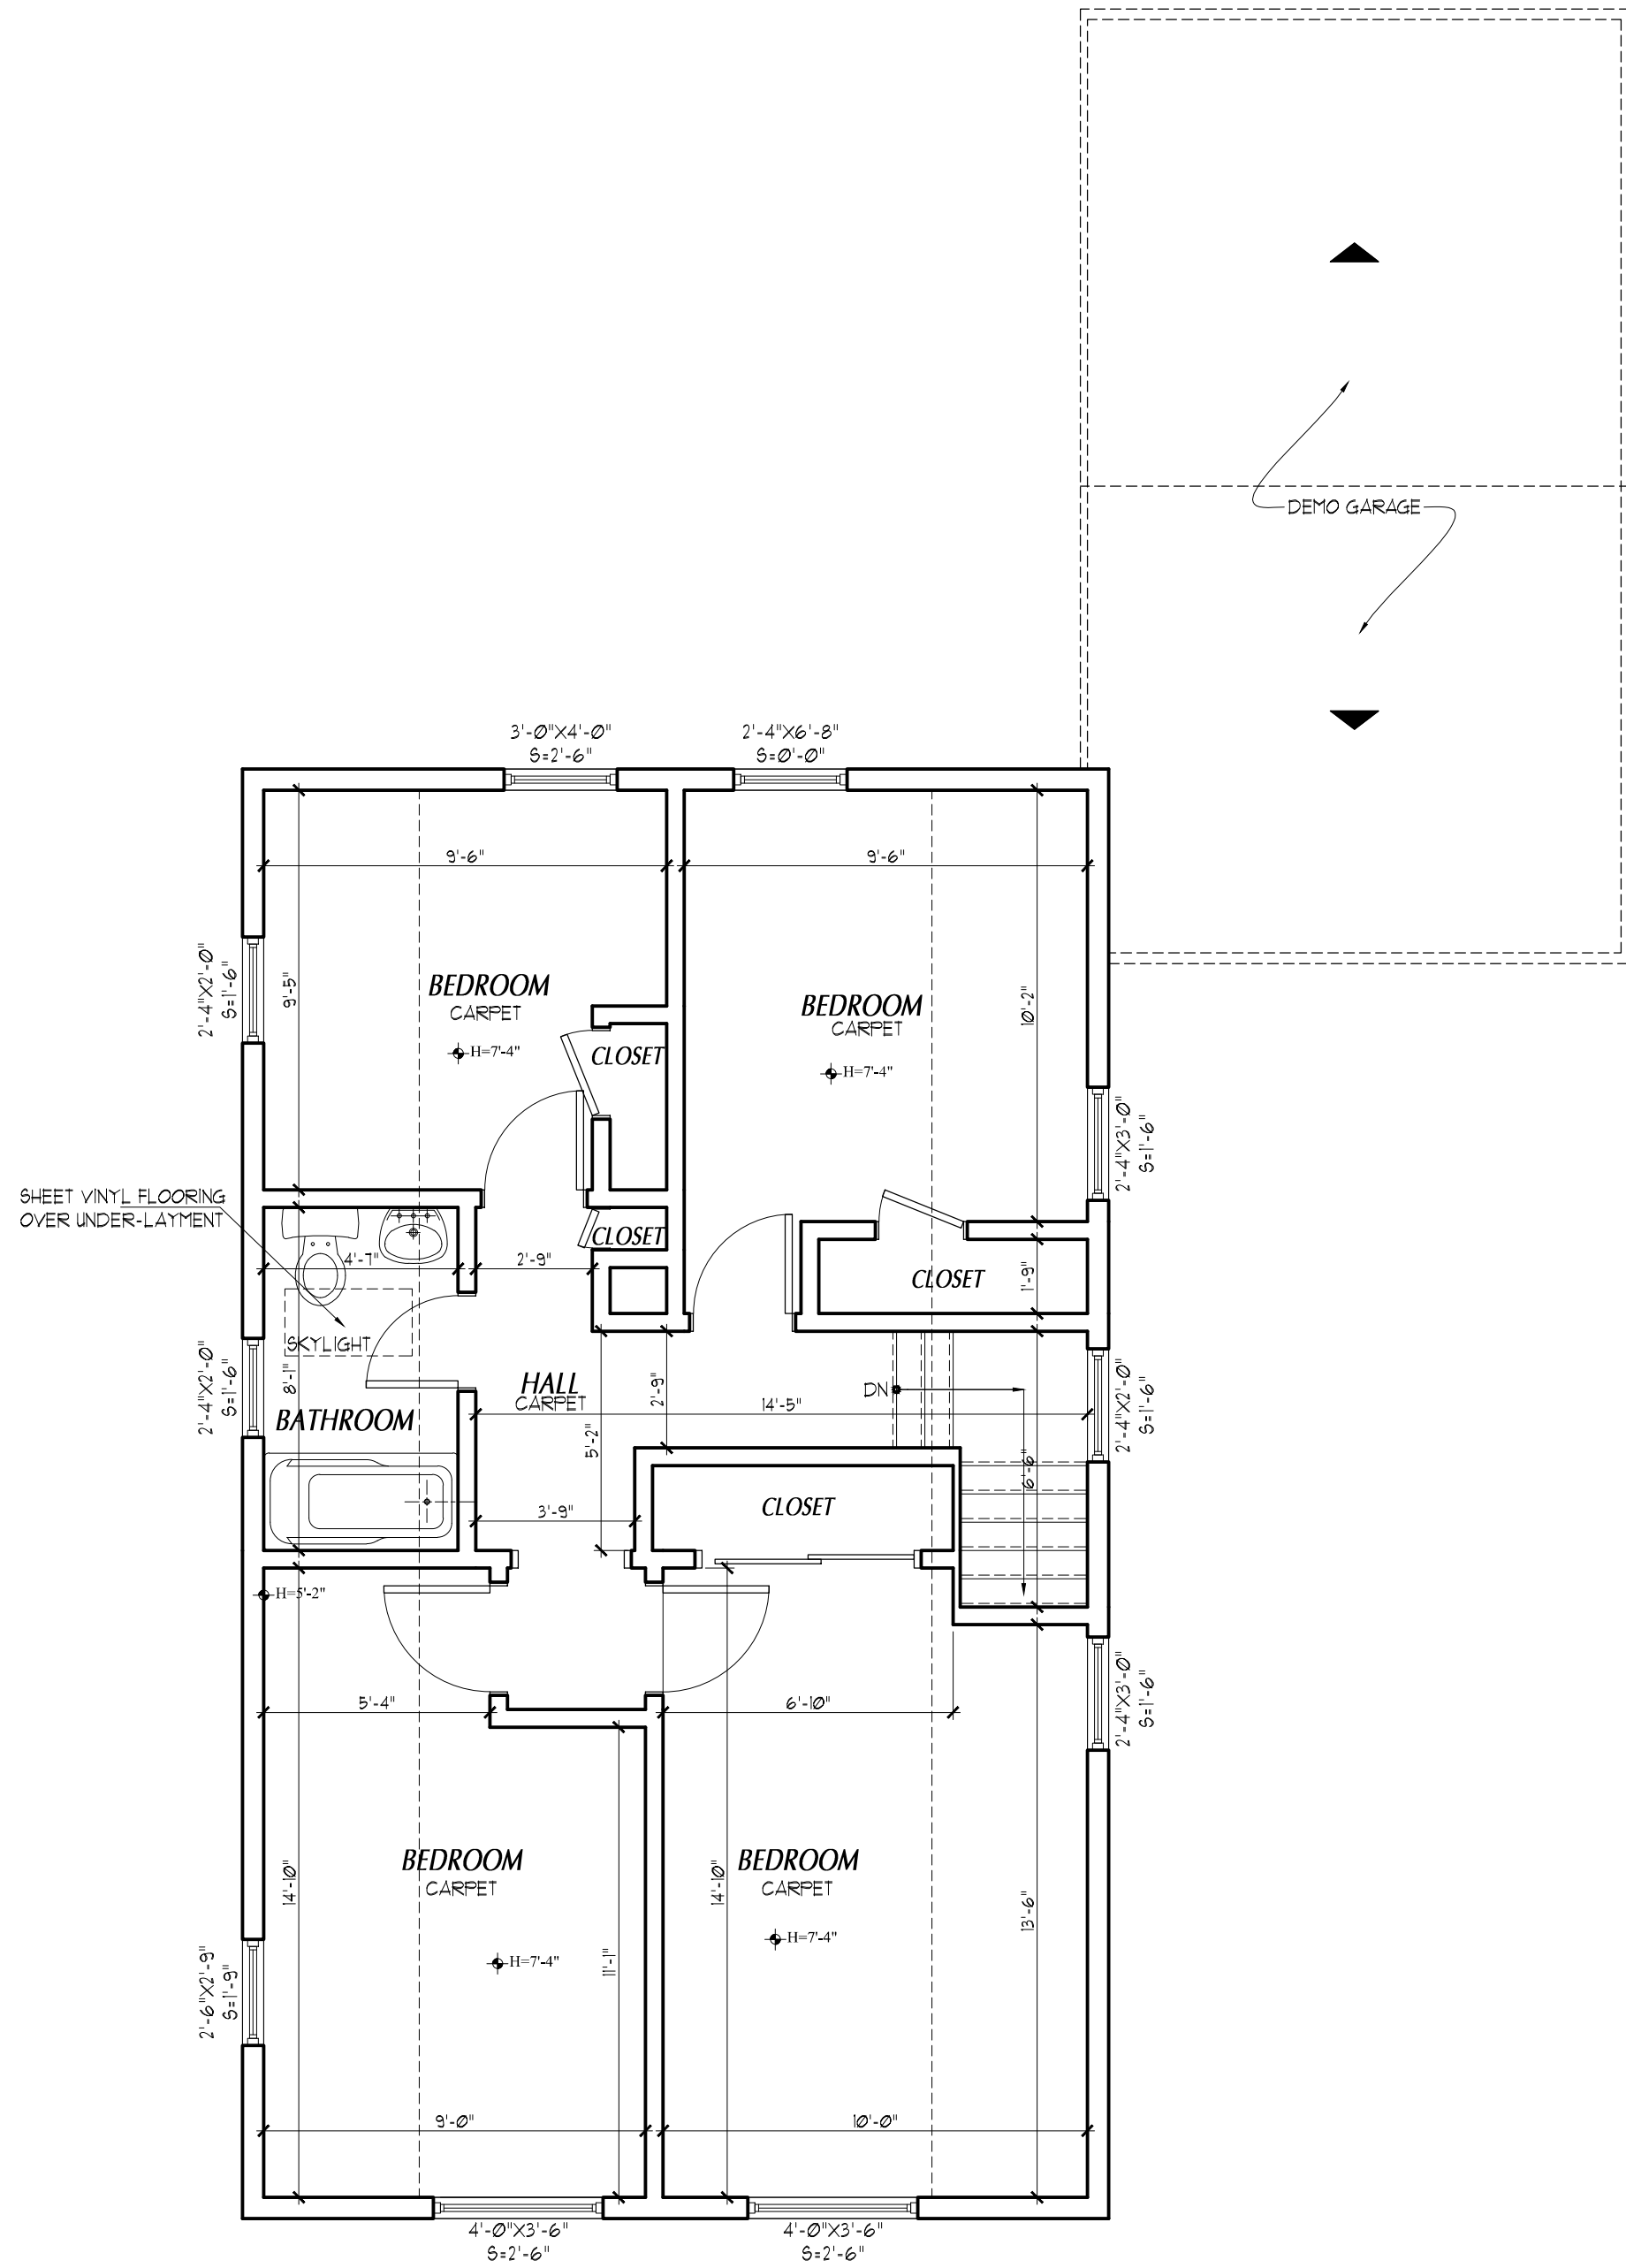

EXISTING SECOND FLOOR PLAN
SCALE: 1/4"=1'-0"

NOT FOR
CONSTRUCTION

Revisions	Date
Review	11.11.14
Norwalk P&Z	12.15.14
Submittal	
Bid Set	01.20.15
Bid Set	03.03.15
Bid Set	04.16.15

© ARIS CRIST AIA 2015.
THIS TECHNICAL DRAWING AND THE
ARCHITECTURAL WORK DEPICTED ARE
COPYRIGHTED BY
ARIS CRIST AIA

Aris Crist Architects

34 East Putnam Avenue
Greenwich, Connecticut 06830
203 661 0661

APPLICANT No. 1260

35 HARBOR VIEW AVENUE
NORWALK CT, 06854

SECOND FLOOR PLAN & WALL SECTION

Drawn
L.F.O.
Checked
Date
06.09.14
Scale
AS NOTED
Job Number
Sheet

A-2.0

Revisions	Date
Review	11.11.14
Norwalk P&Z	12.15.14
Submittal	
Bid Set	01.20.15
Bid Set	03.03.15
Bid Set	04.16.15

© ARIS CRIST AIA 2015.
THIS TECHNICAL DRAWING AND THE
ARCHITECTURAL WORK DEPICTED ARE
COPYRIGHTED BY
ARIS CRIST AIA

Aris Crist Architects
34 East Putnam Avenue
Greenwich, Connecticut 06830
203 661 0661


APPLICANT No. 1260

35 HARBOR VIEW AVENUE
NORWALK CT, 06854

ELEVATIONS


Drawn
L.F.O.
Checked
Date
10.27.14
Scale
AS NOTED
Job Number
Sheet

A-3.0

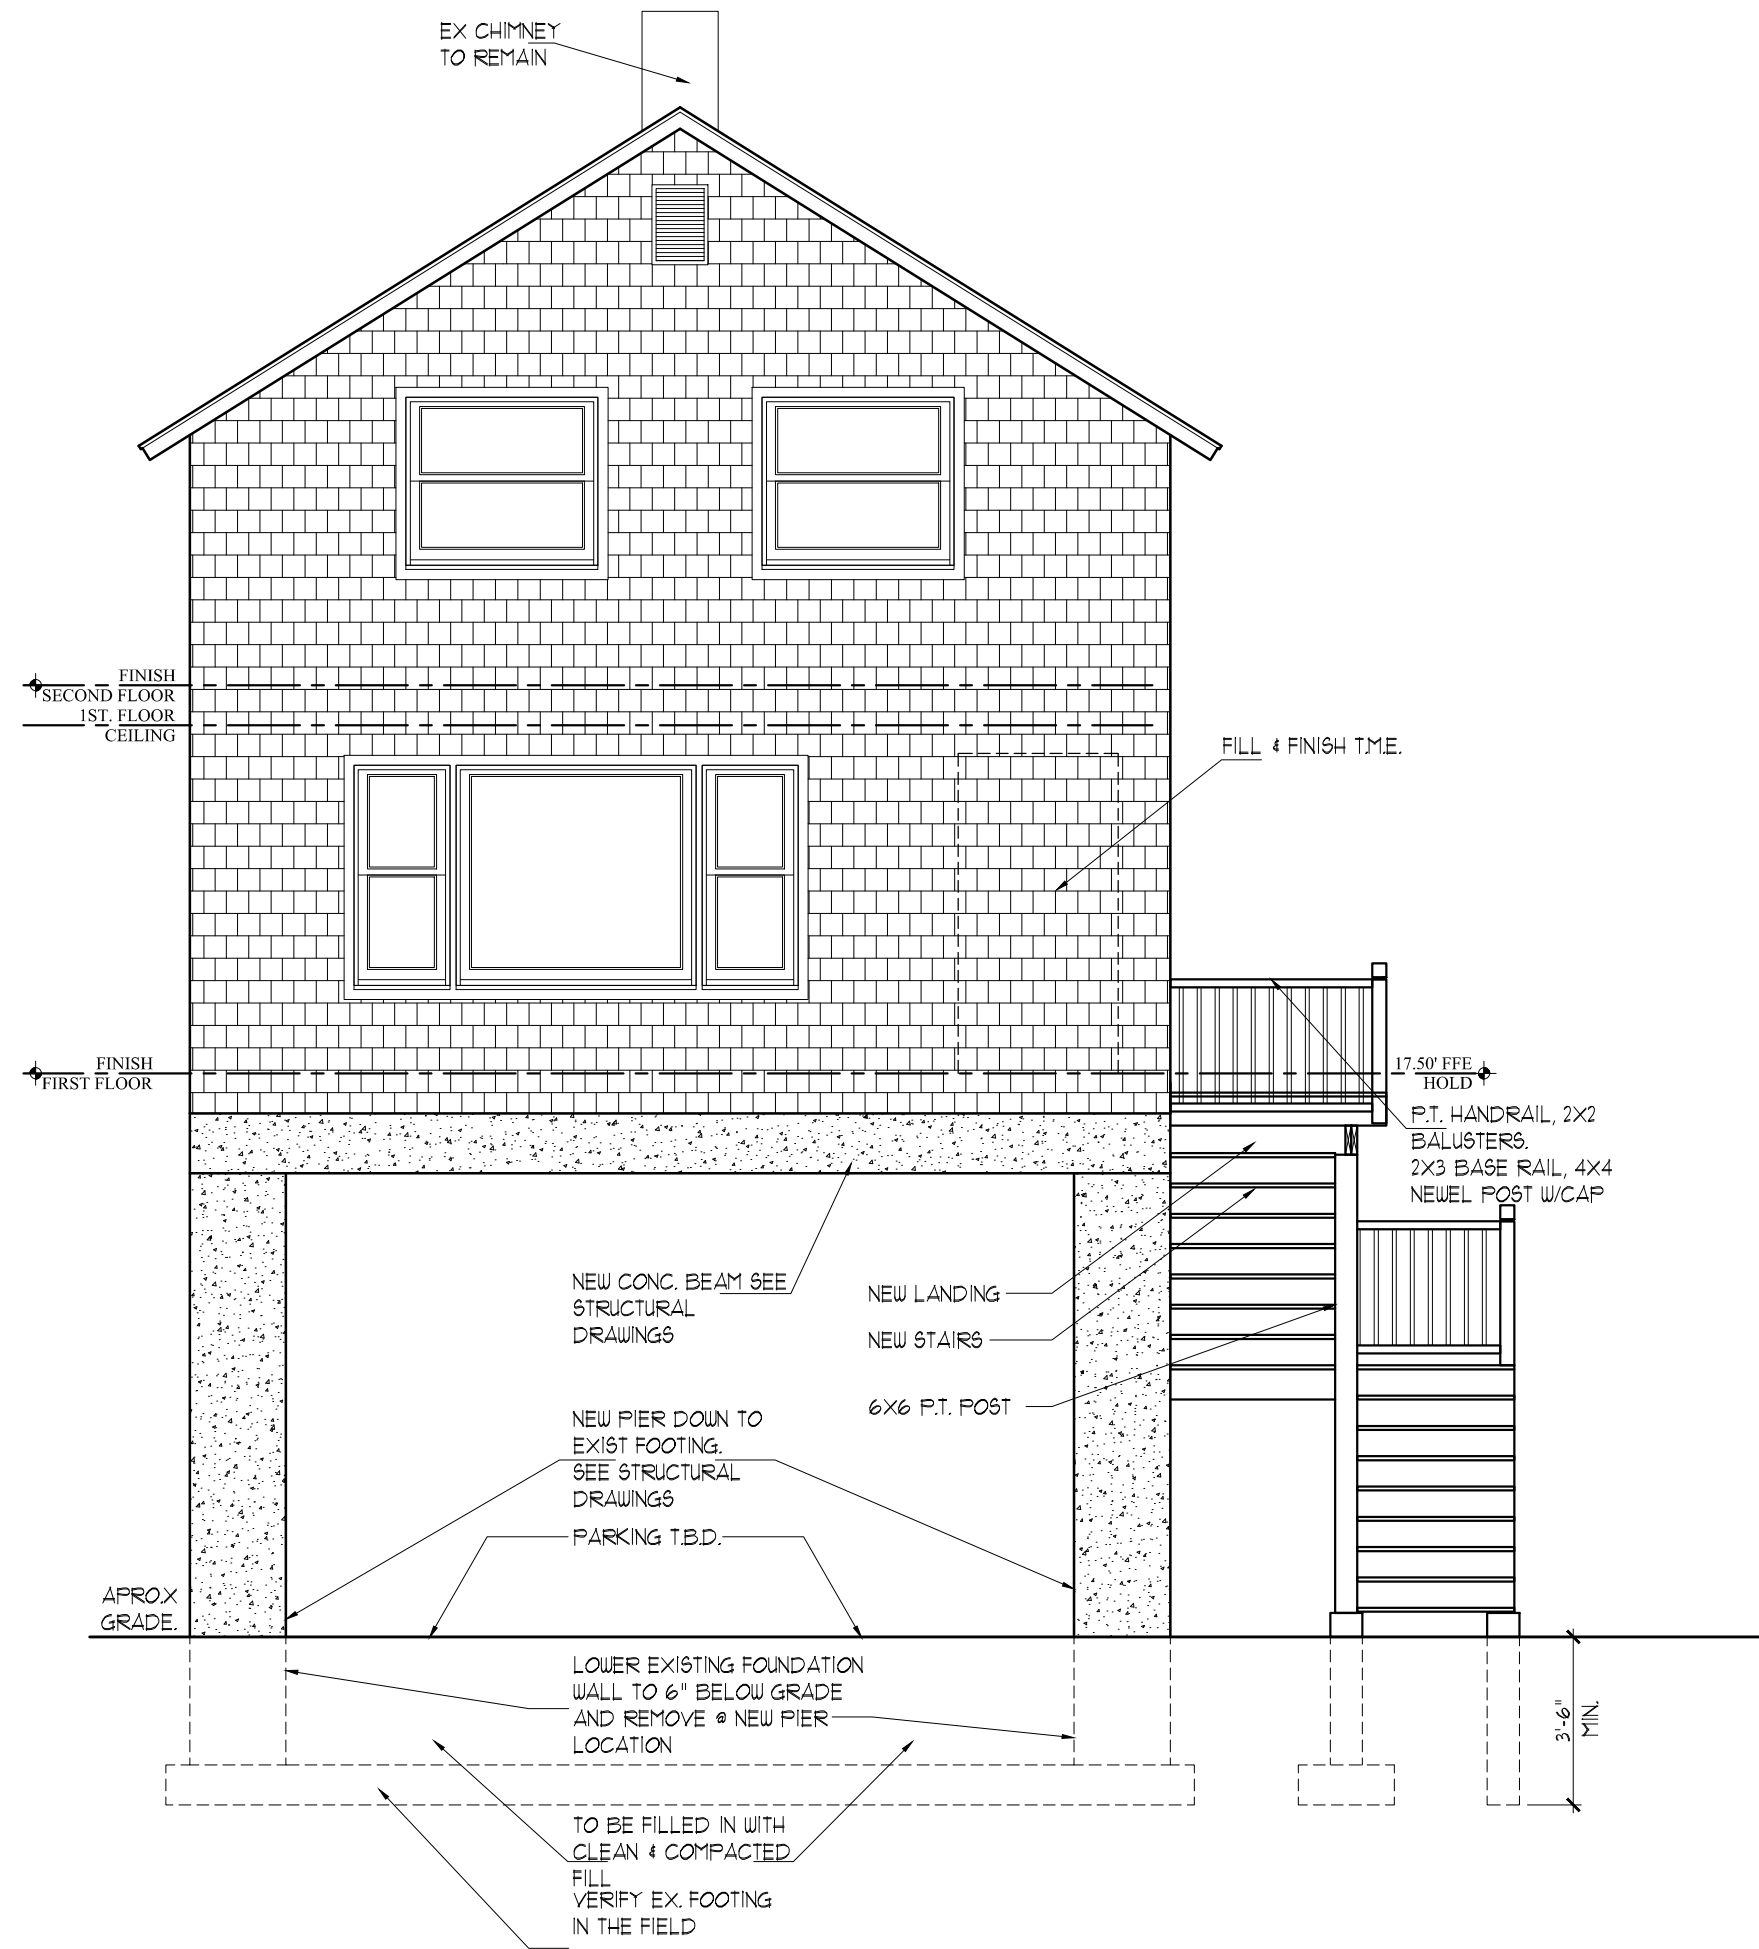

FRONT ELEVATION

SCALE: 1/4"=1'-0"

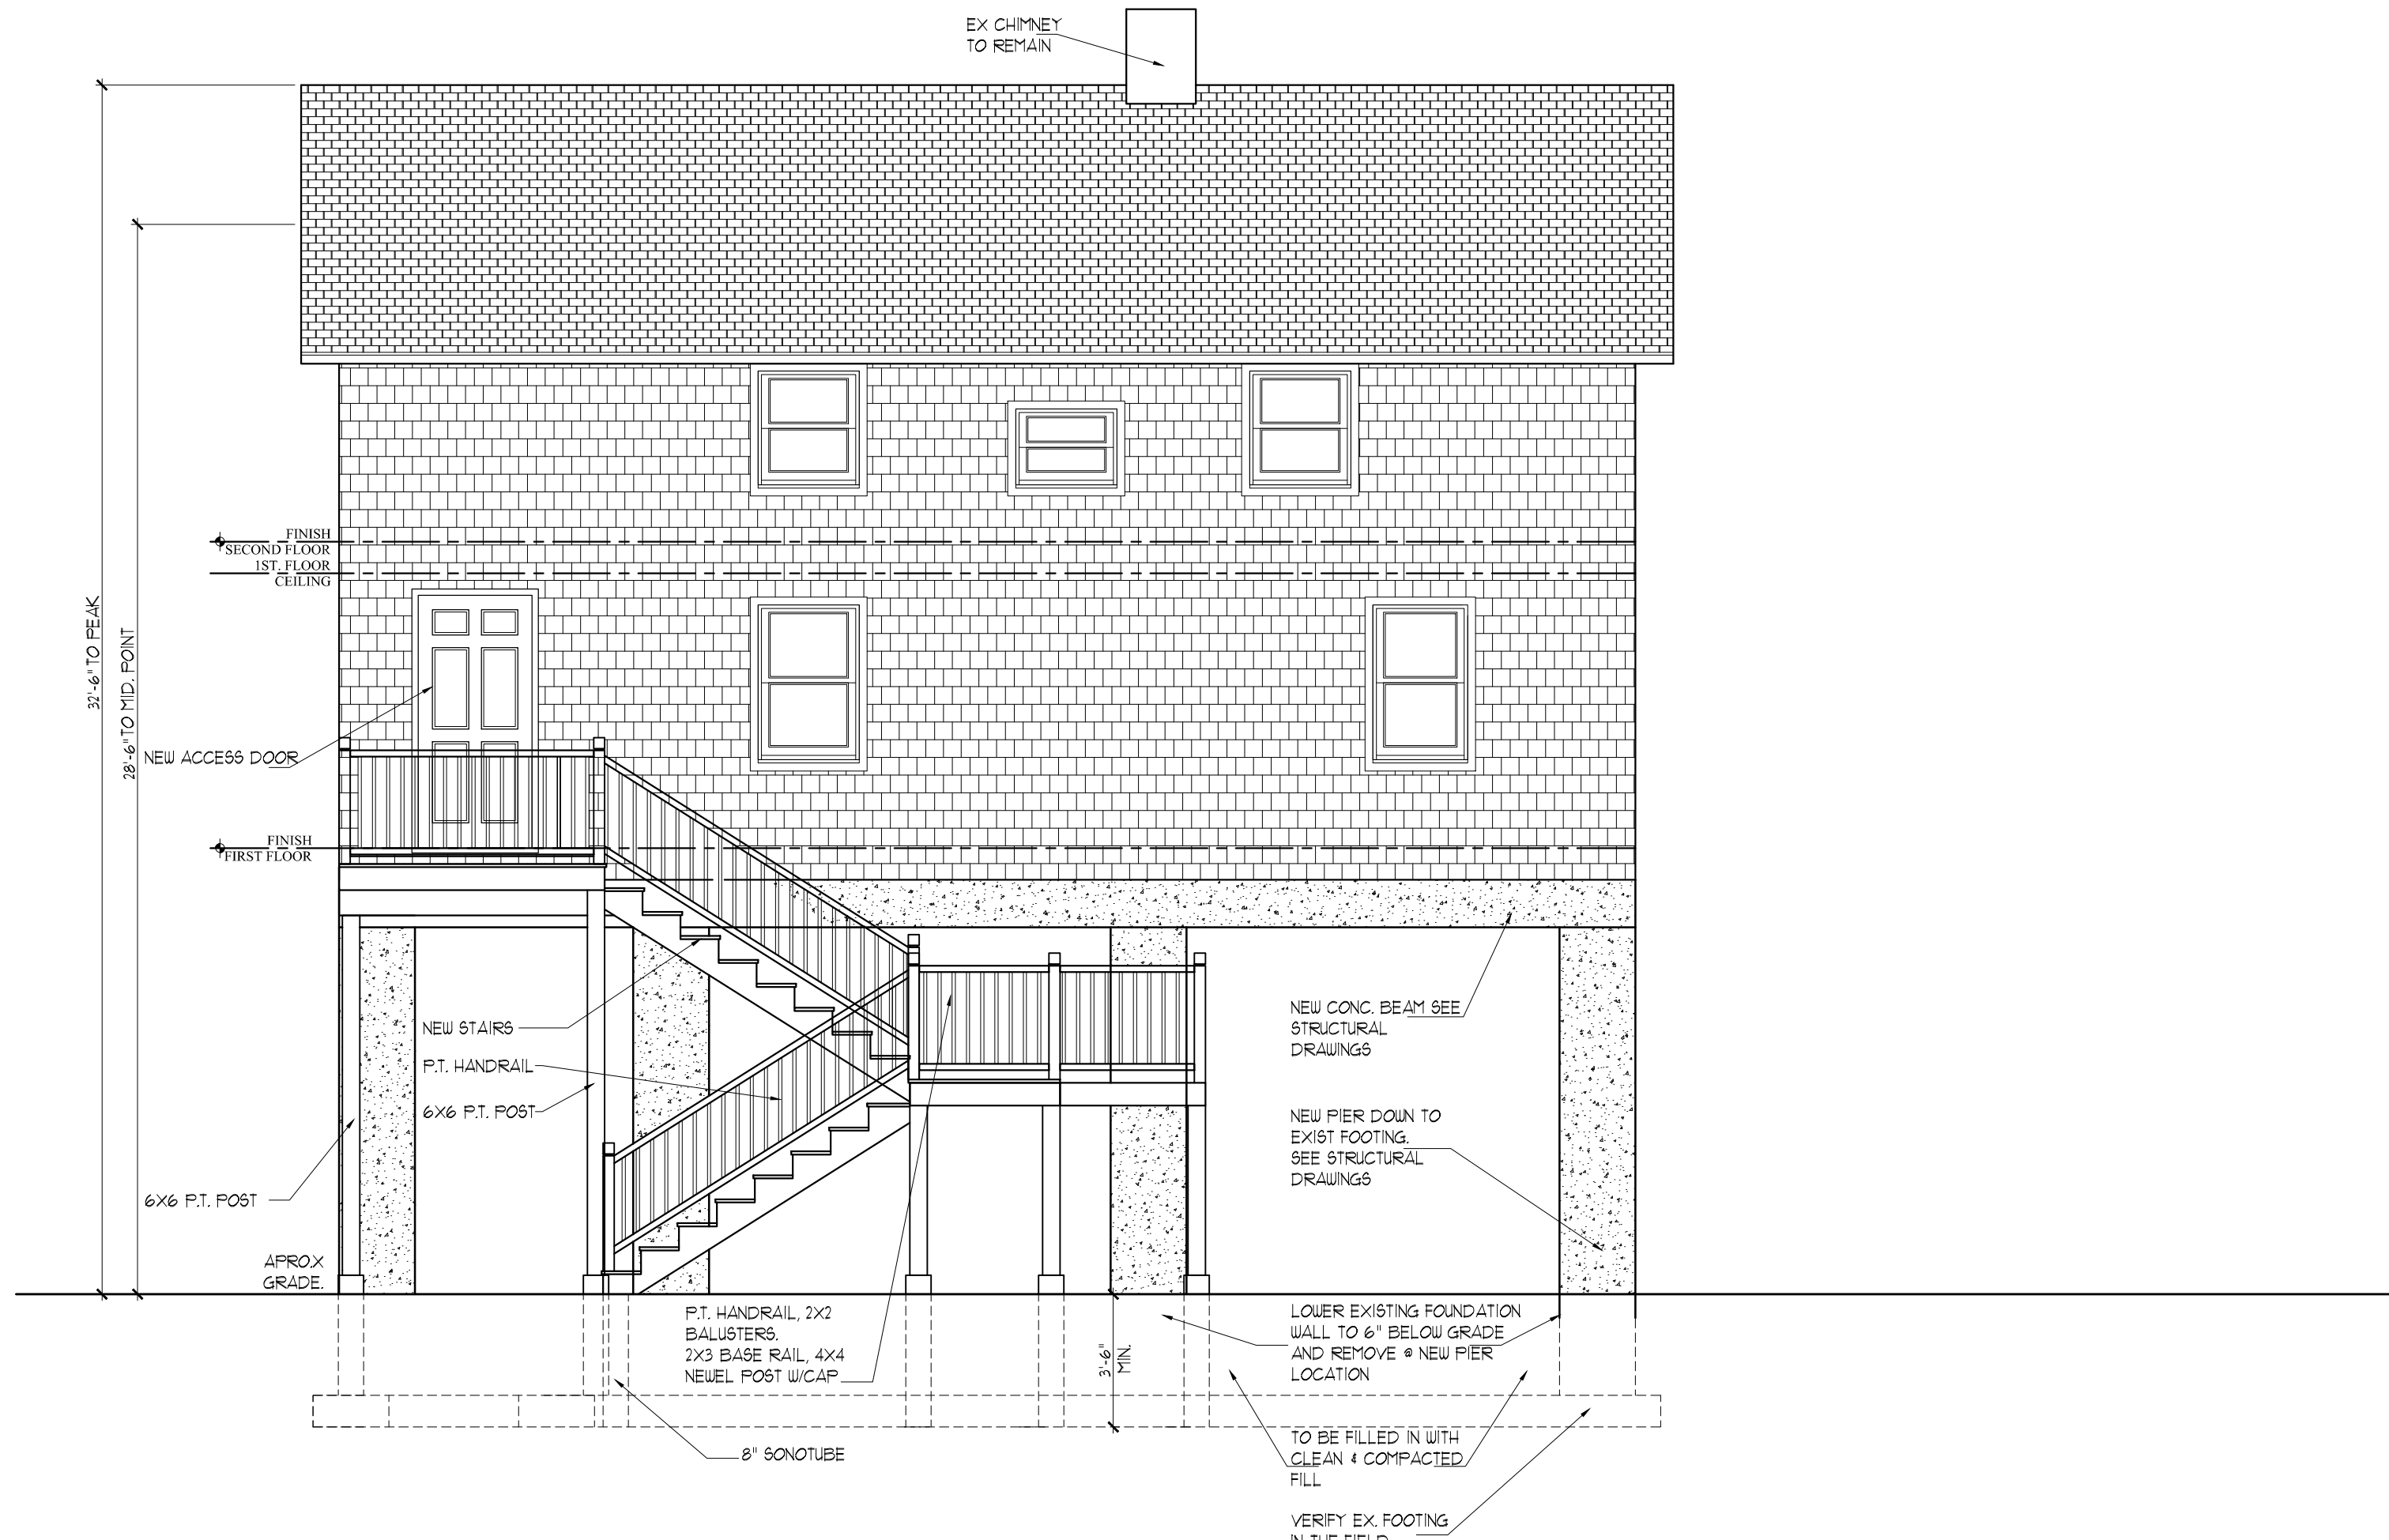

EAST ELEVATION

SCALE: 1/4"=1'-0"

NOT FOR
CONSTRUCTION

Revisions	Date
Review	11.11.14
Norwalk P&Z	12.15.14
Submittal	
Bid Set	01.20.15
Bid Set	03.03.15
Bid Set	04.16.15

© ARIS CRIST AIA 2015.
THIS TECHNICAL DRAWING AND THE
ARCHITECTURAL WORK DEPICTED ARE
COPYRIGHTED BY
ARIS CRIST AIA

Aris Crist Architects
34 East Putnam Avenue
Greenwich, Connecticut 06830
203 661 0661


APPLICANT No. 1260

35 HARBOR VIEW AVENUE
NORWALK CT, 06854


ELEVATIONS

Drawn
L.F.O.
Checked
Date
10.27.14
Scale
AS NOTED
Job Number
Sheet

A-4.0

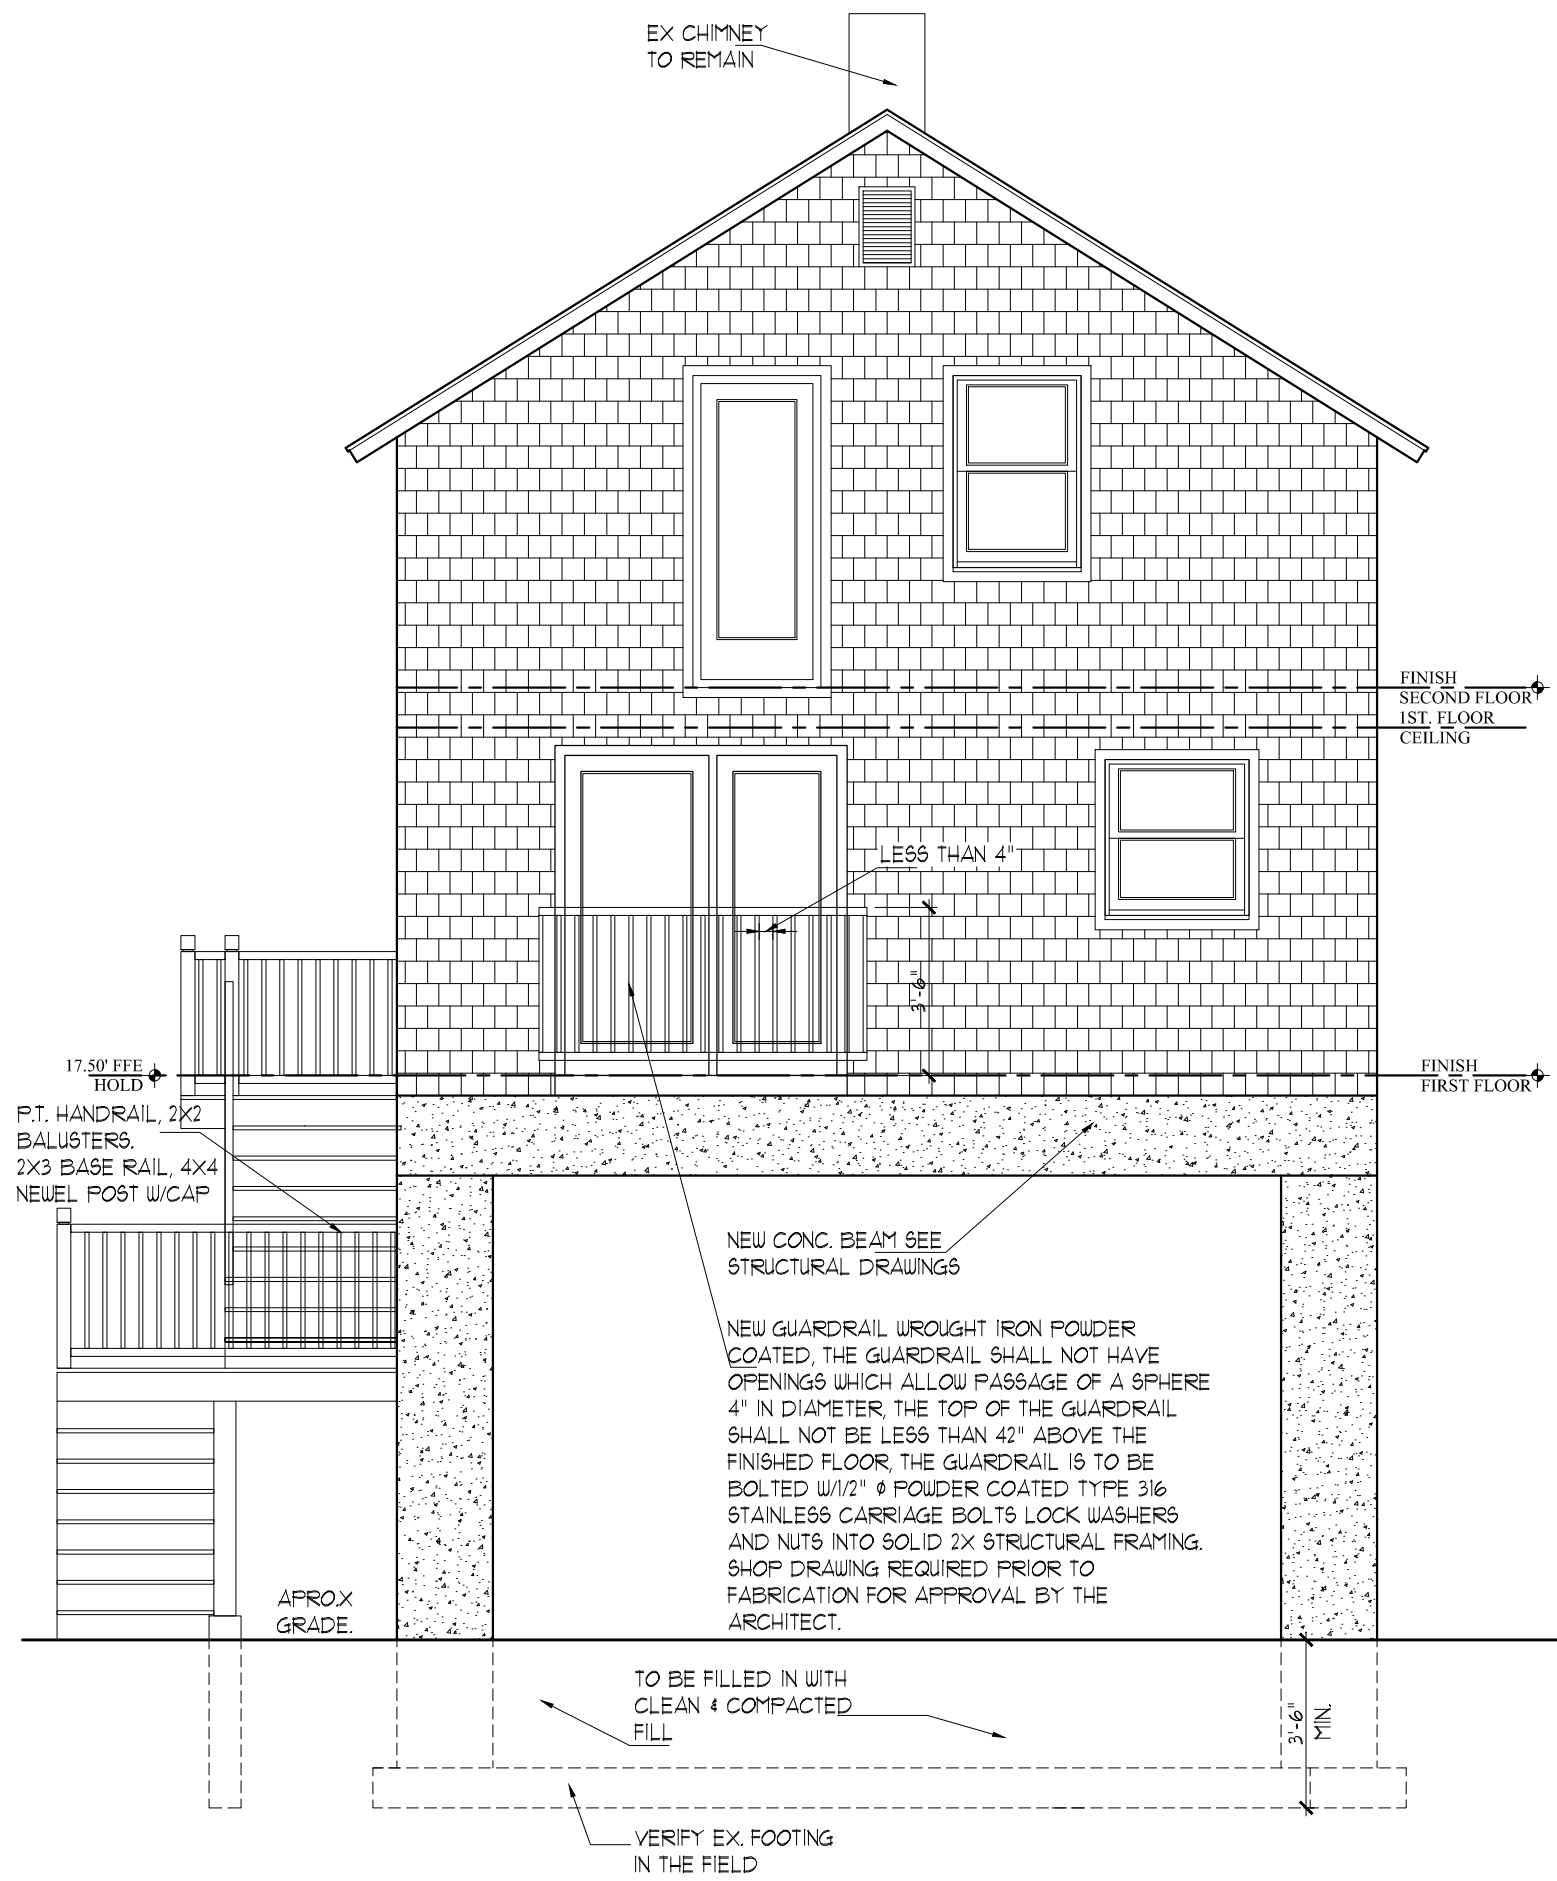


REAR ELEVATION
SCALE: 1/4"=1'-0"

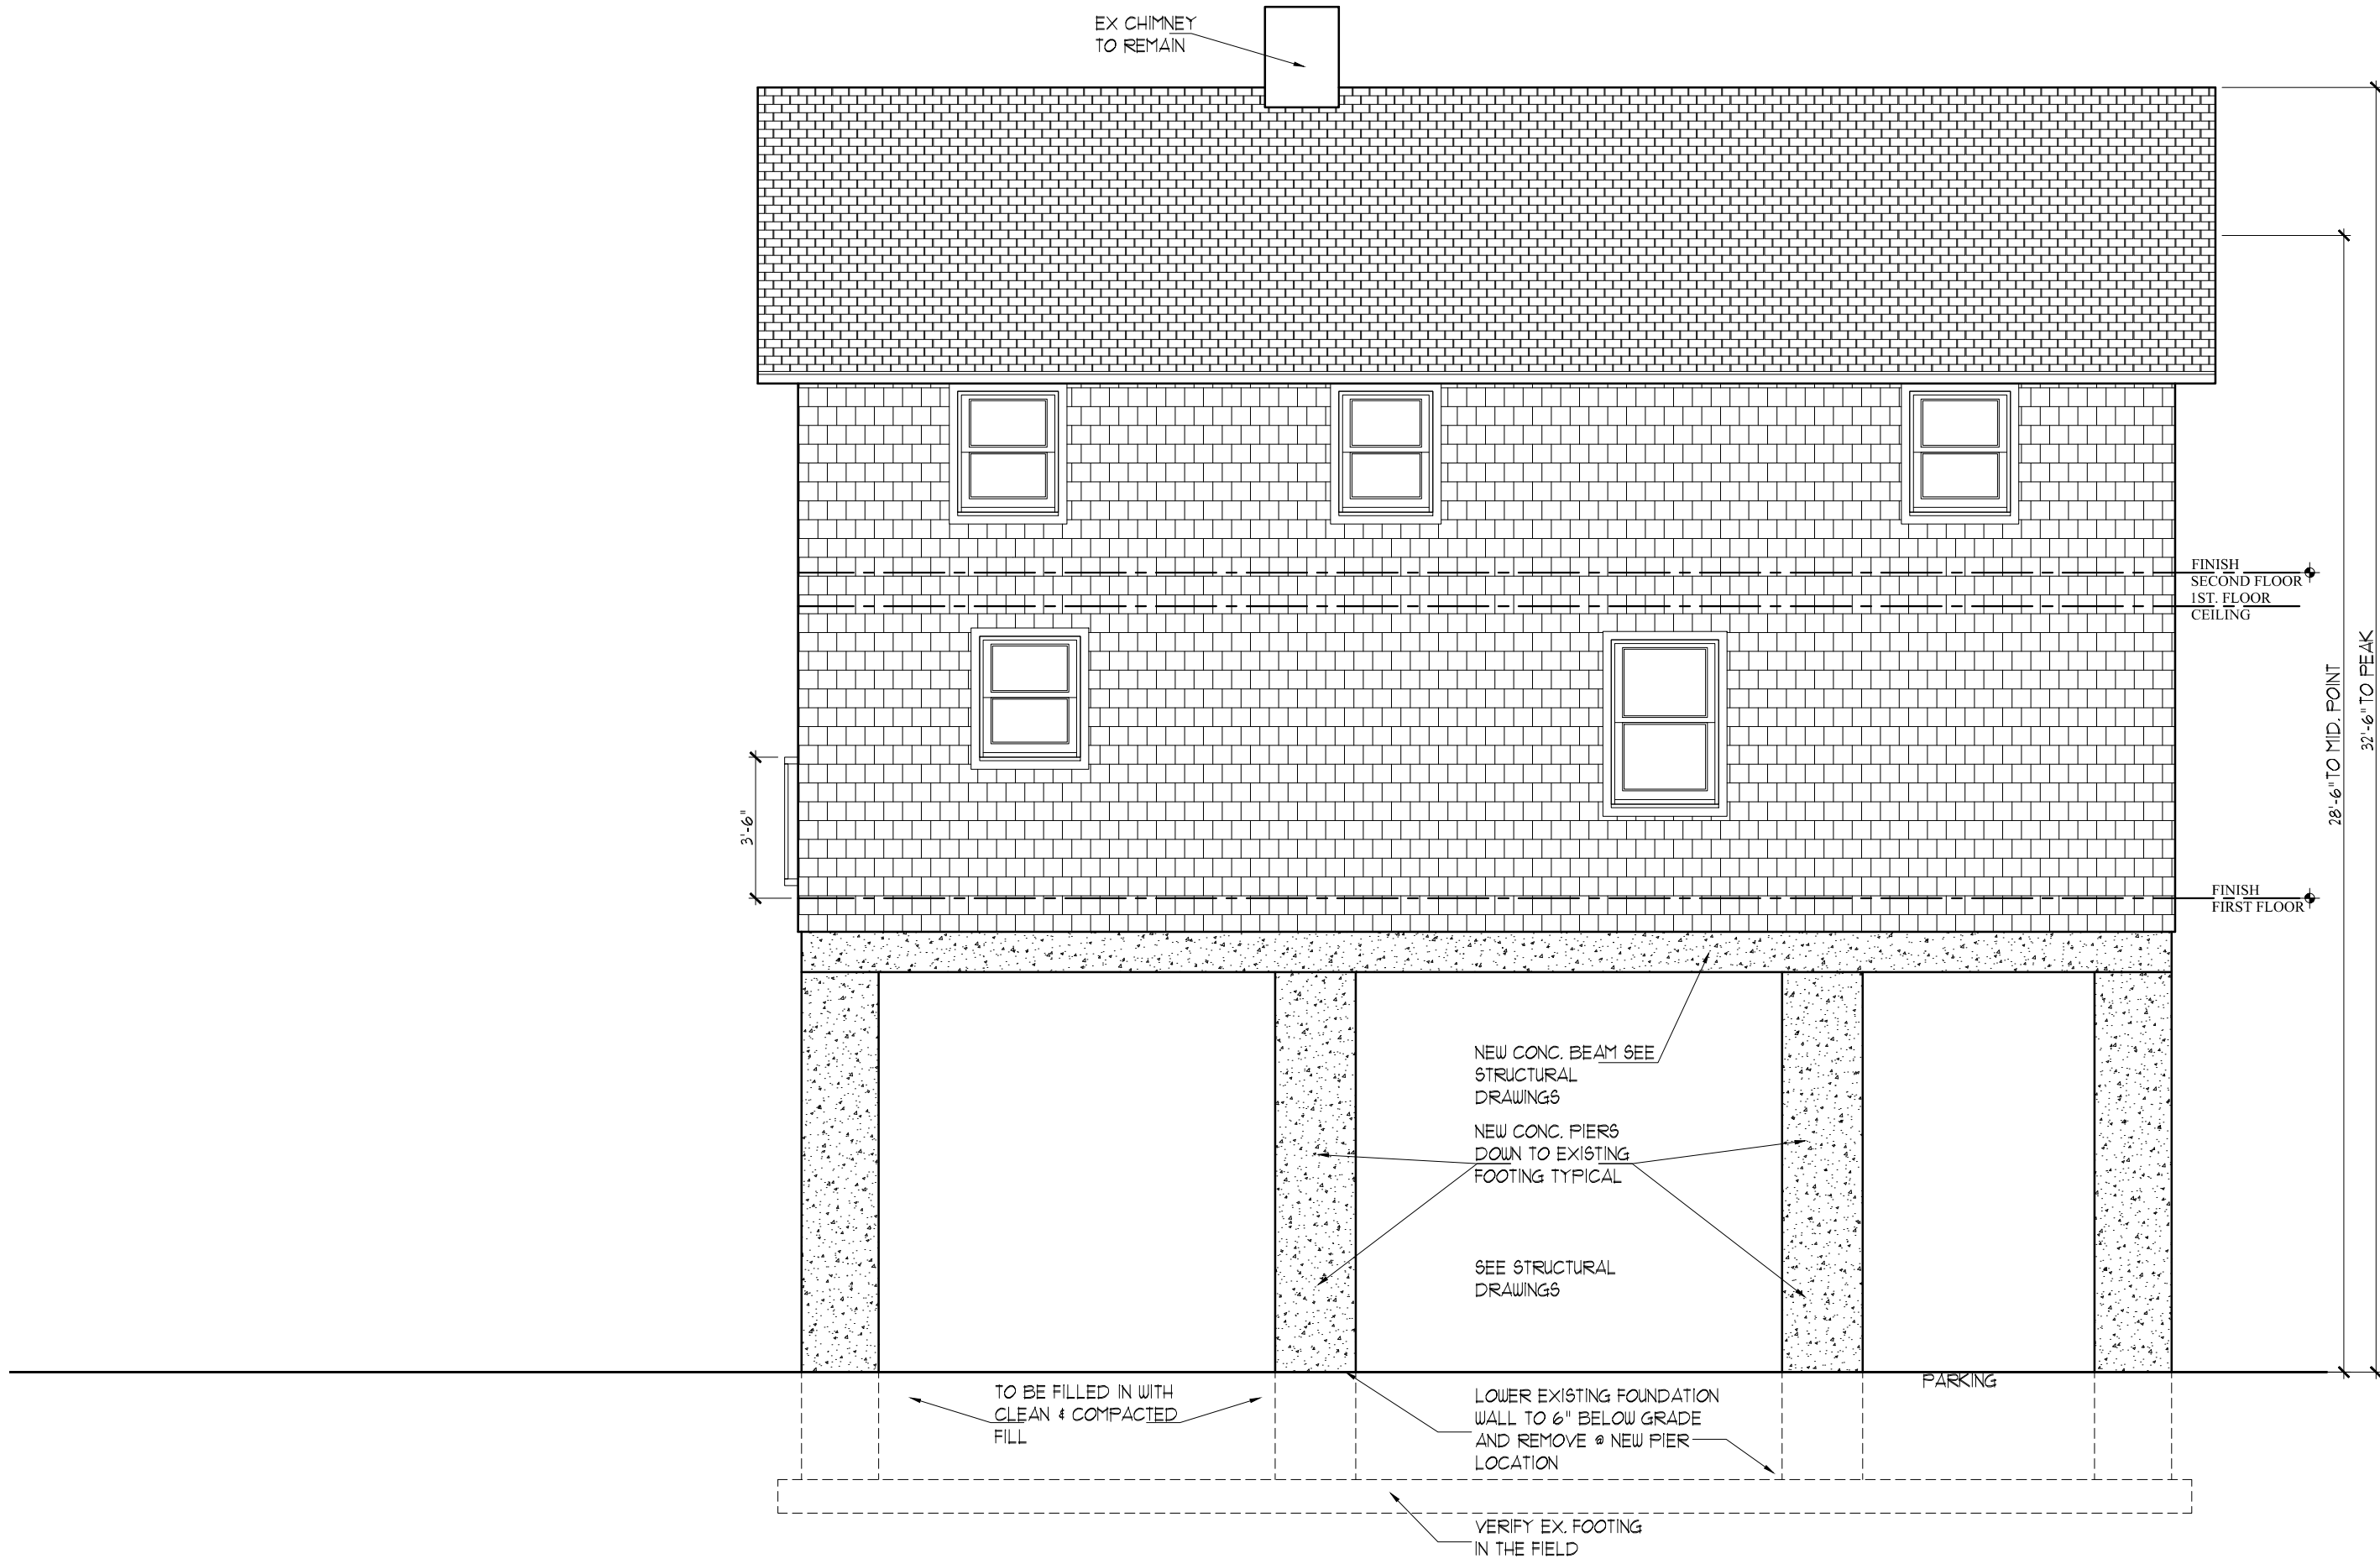

WEST ELEVATION
SCALE: 1/4"=1'-0"

NOT FOR
CONSTRUCTION


S1

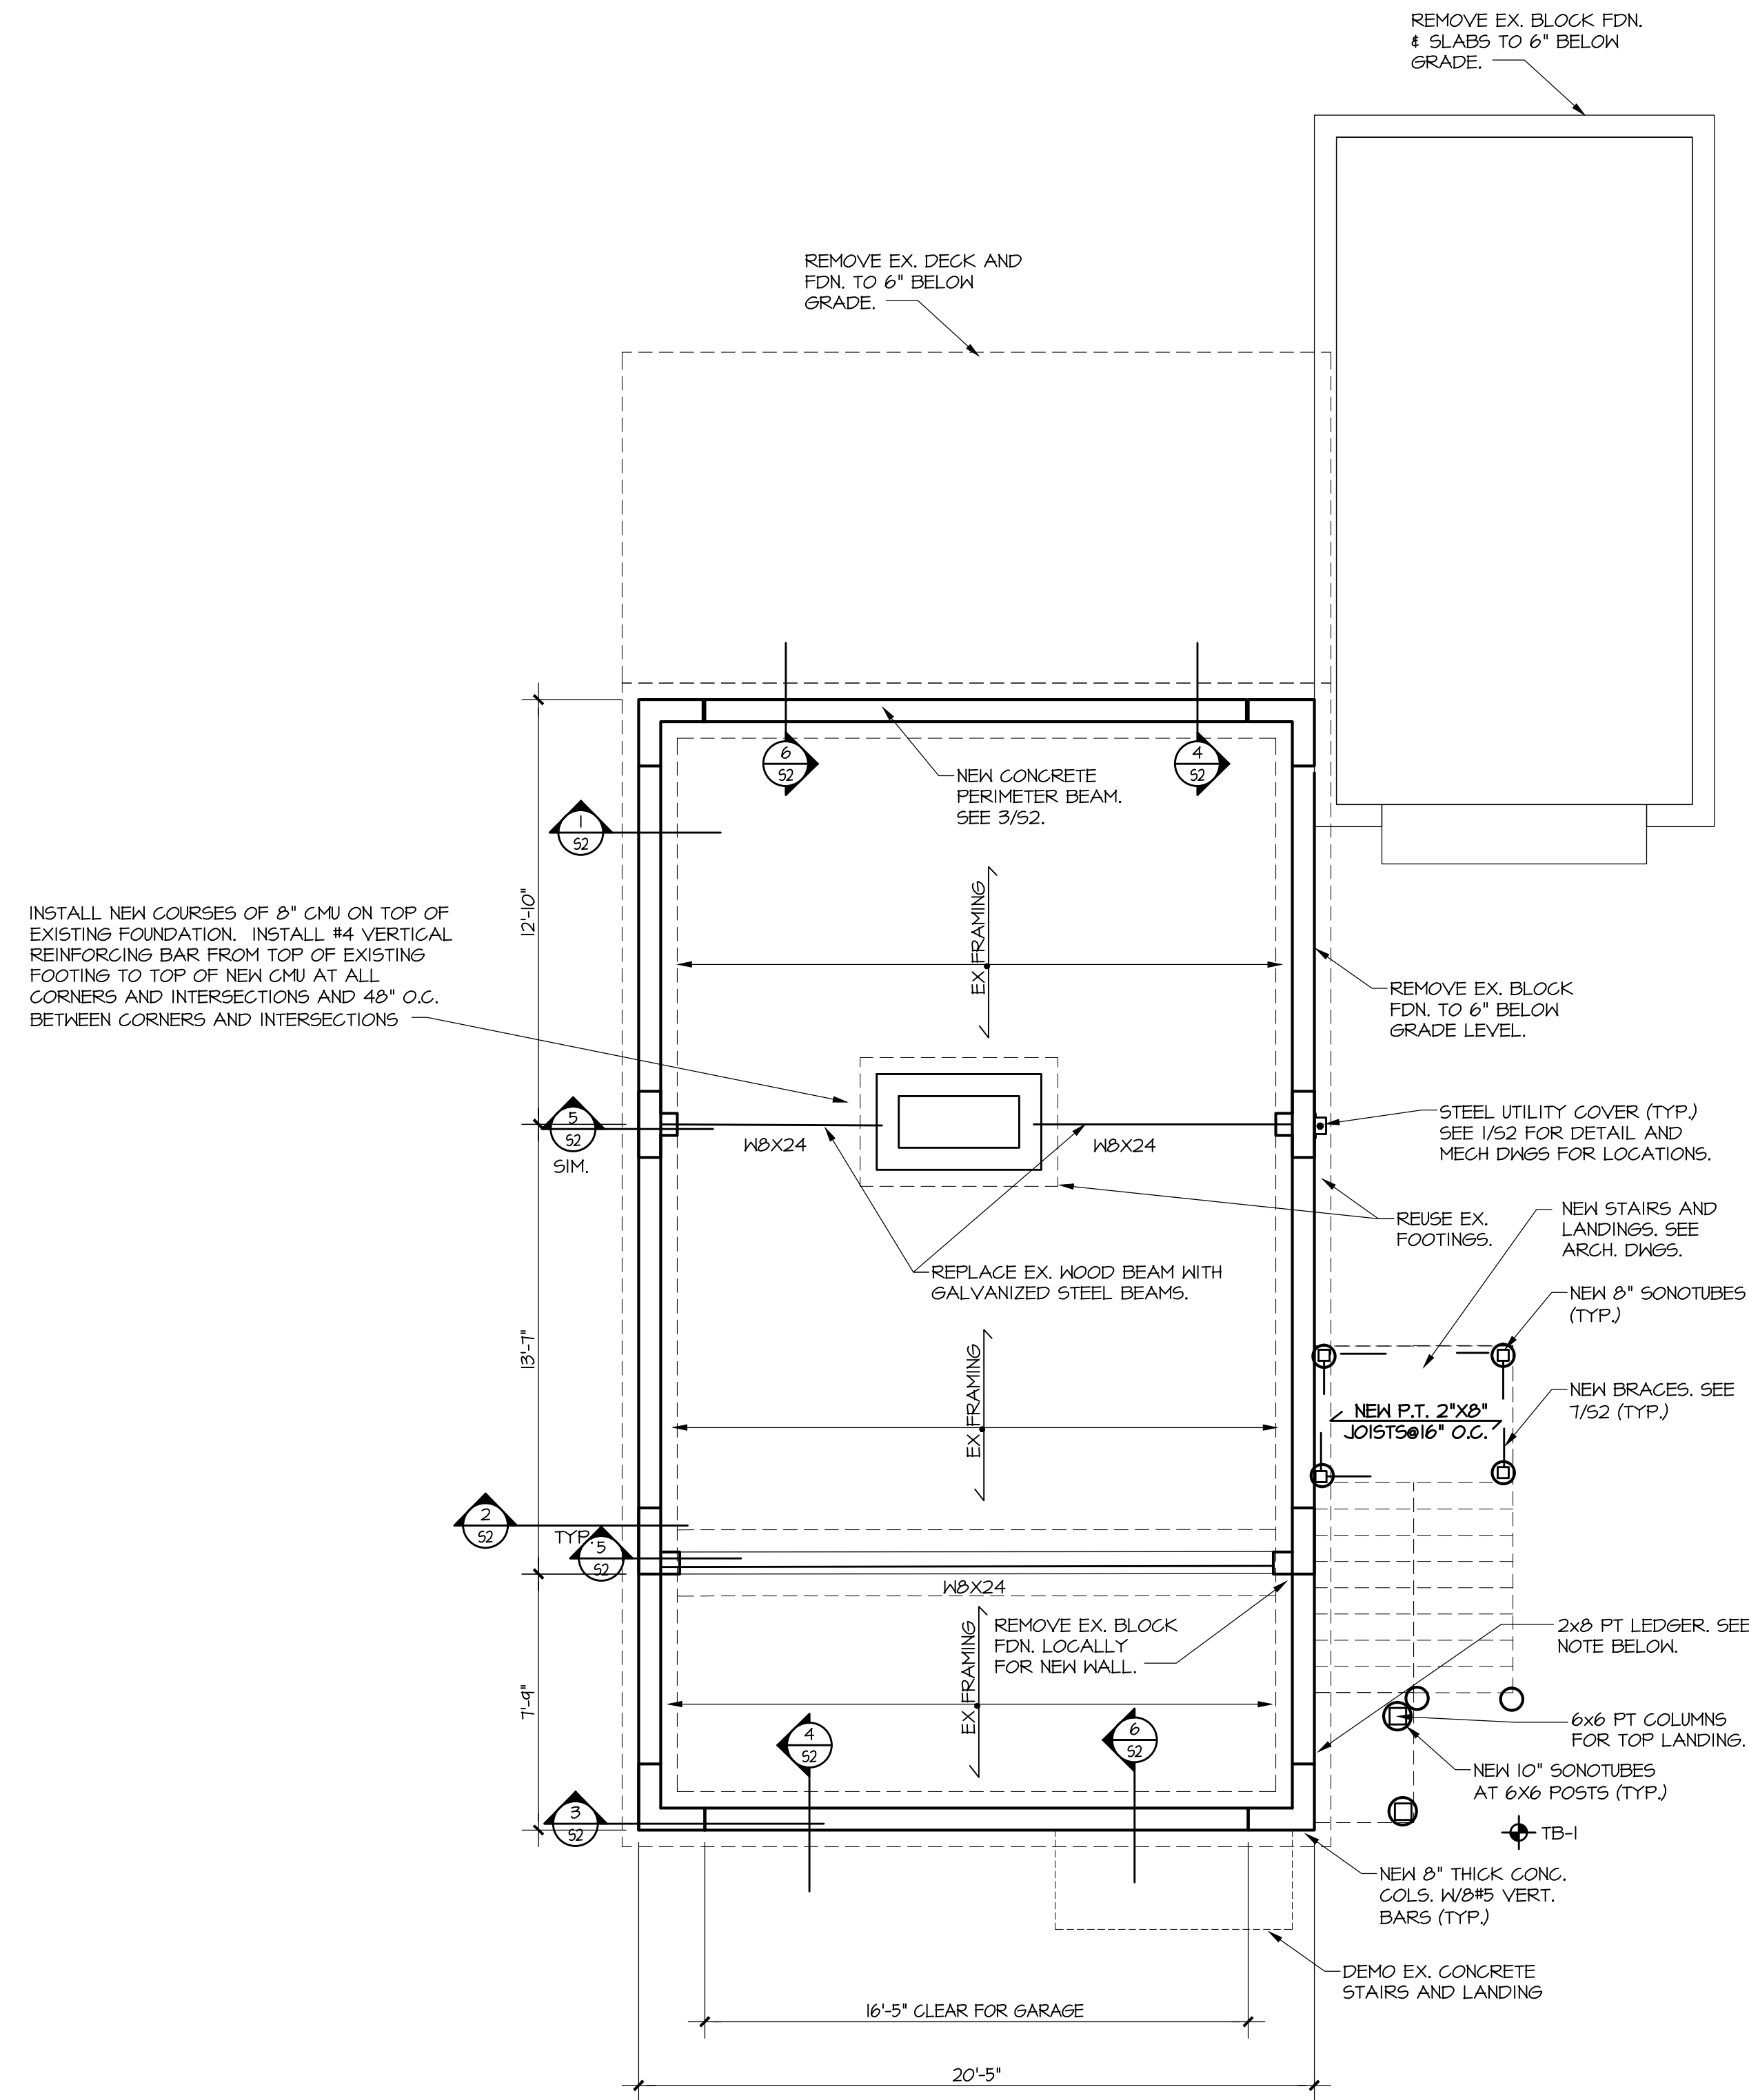

FOUNDATION AND FIRST FLOOR FRAMING PLAN
1/4" = 1'-0"

- DO NOT SCALE THIS DRAWING. SEE ARCHITECTURAL PLANS FOR ALL DIMENSIONS AND ELEVATIONS.
- ALL WORK SHOWN IS NEW UNLESS INDICATED AS EXISTING AND/ OR SHOWN WITH LIGHT LINE WORK.
- SIZE AND DEPTH OF EXISTING FOOTINGS AND FIRST FLOOR FRAMING TO BE VERIFIED IN FIELD. CONTRACTOR TO EXPOSE EX. FRAMING TO DETERMINE WALL TIE DOWNS TO FLOOR FRAMING.
- TYPICAL SONOTUBE, PIER AND POST; NEW CONC. SONOTUBE PIER, BOTTOM OF PIER AT 3'-6" MIN. FROM FINISHED GRADE. SEE PLAN FOR SIZE, TYP. AND POST; P.T. SEE PLAN FOR SIZE. PROVIDE SIMPSON ABL66 POST BASE AND SIMPSON PC46 POST CAP.
-  TB# INDICATES APPROXIMATE LOCATION OF SOIL TEST BORING.
- PLACE 3/4" GRAVEL, 6" DEEP, UNDER HOUSE.
- SEE DRAWING 50 FOR GENERAL NOTES AND MATERIAL SPECIFICATIONS AND DRAWING 52 FOR SECTIONS AND DETAILS.

**NOT FOR
CONSTRUCTION**

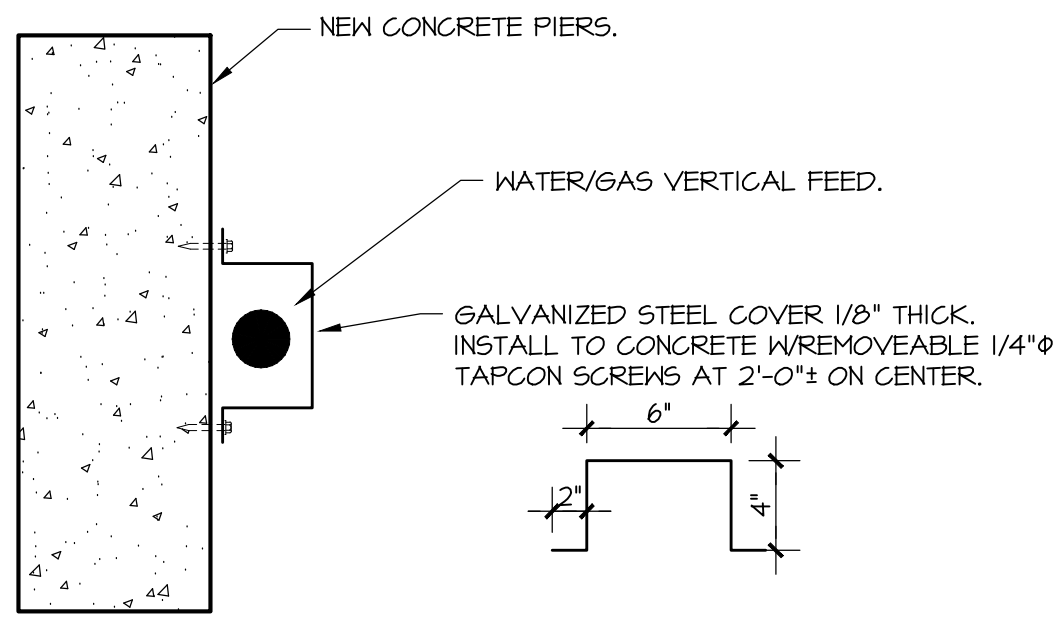


PLAN VIEW

UTILITY COVER DETAIL AT PIER

NO SCALE

1

52

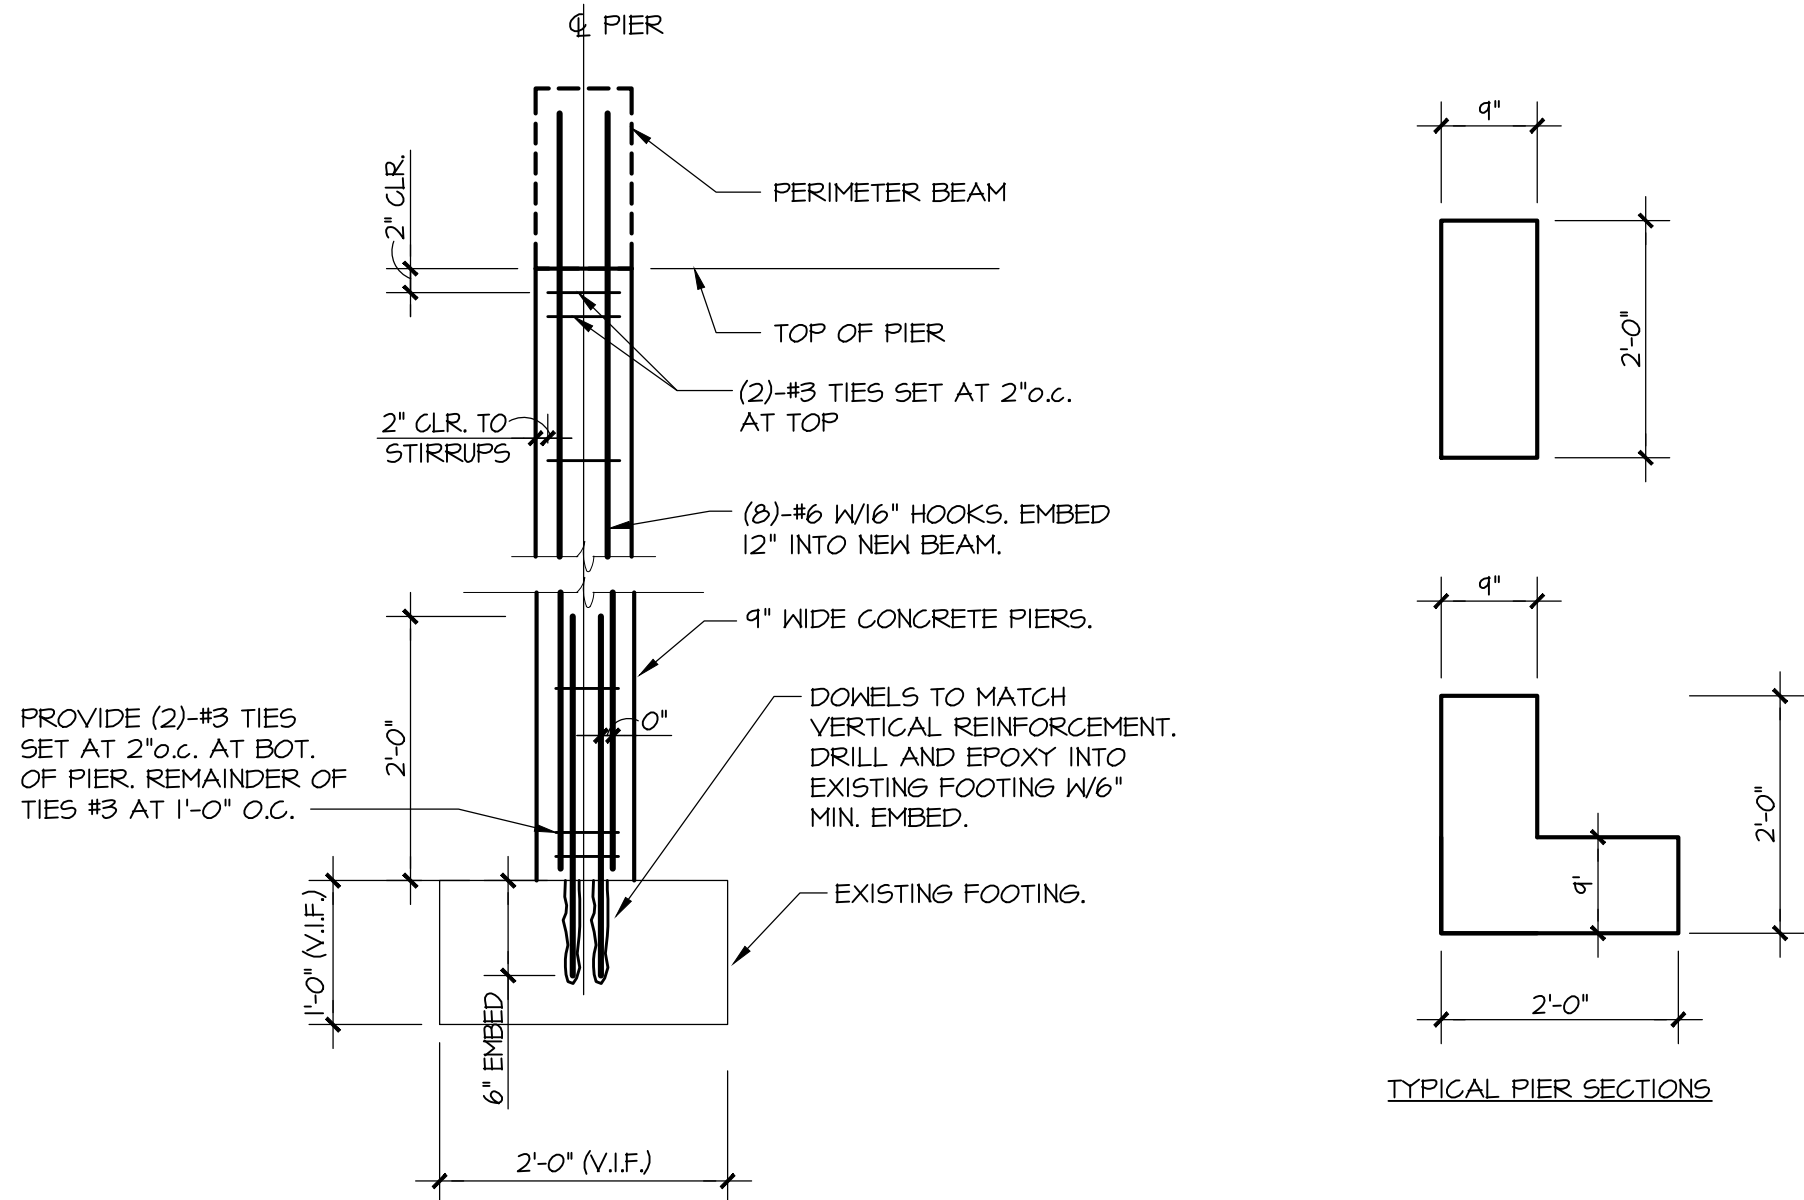


TYPICAL PIER/FOOTING DETAIL

NO SCALE

2

52

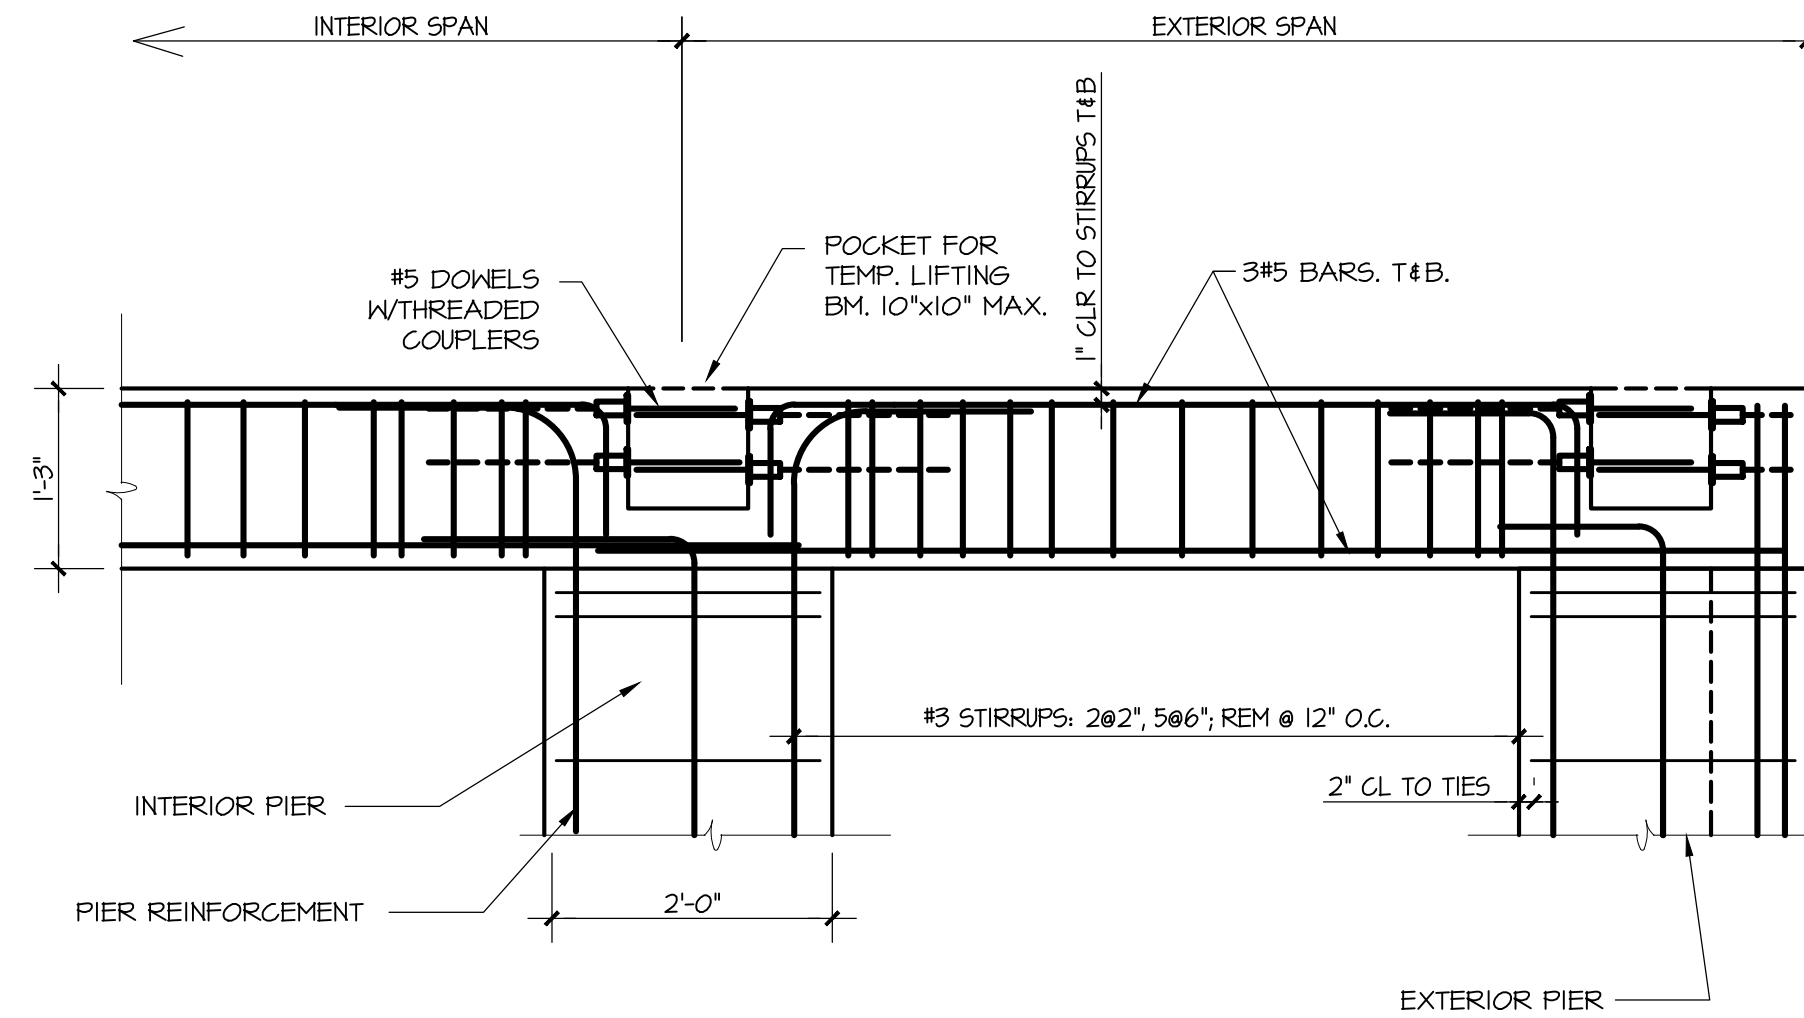


TYPICAL PERIMETER BEAM DETAIL

NO SCALE

3

52

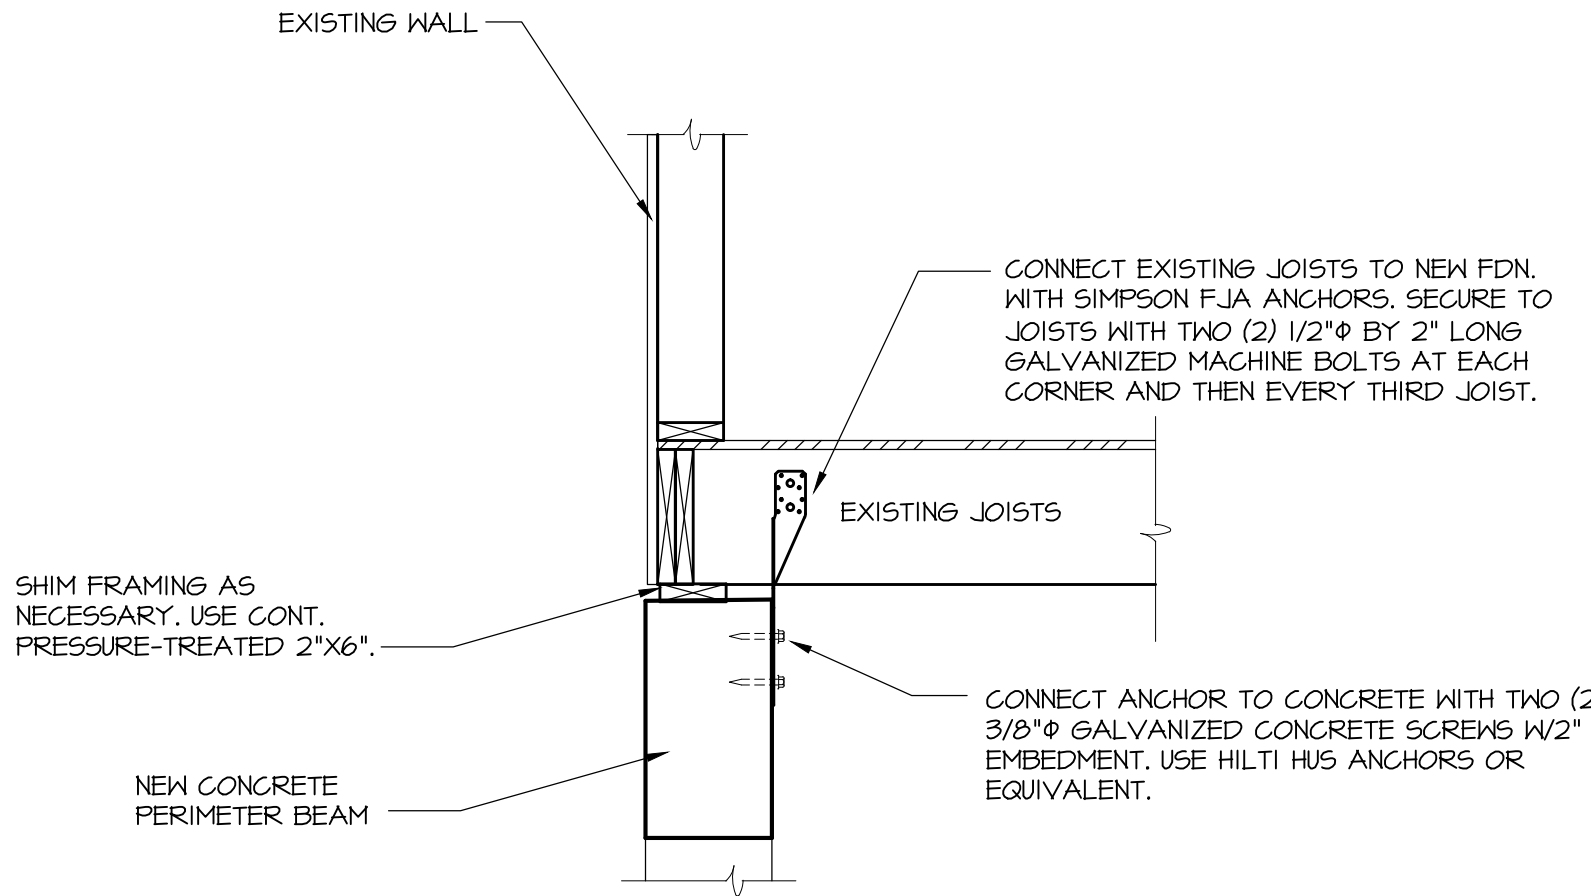


CONCRETE TO BLDG. CONNECTION DETAIL

NO SCALE

4

52

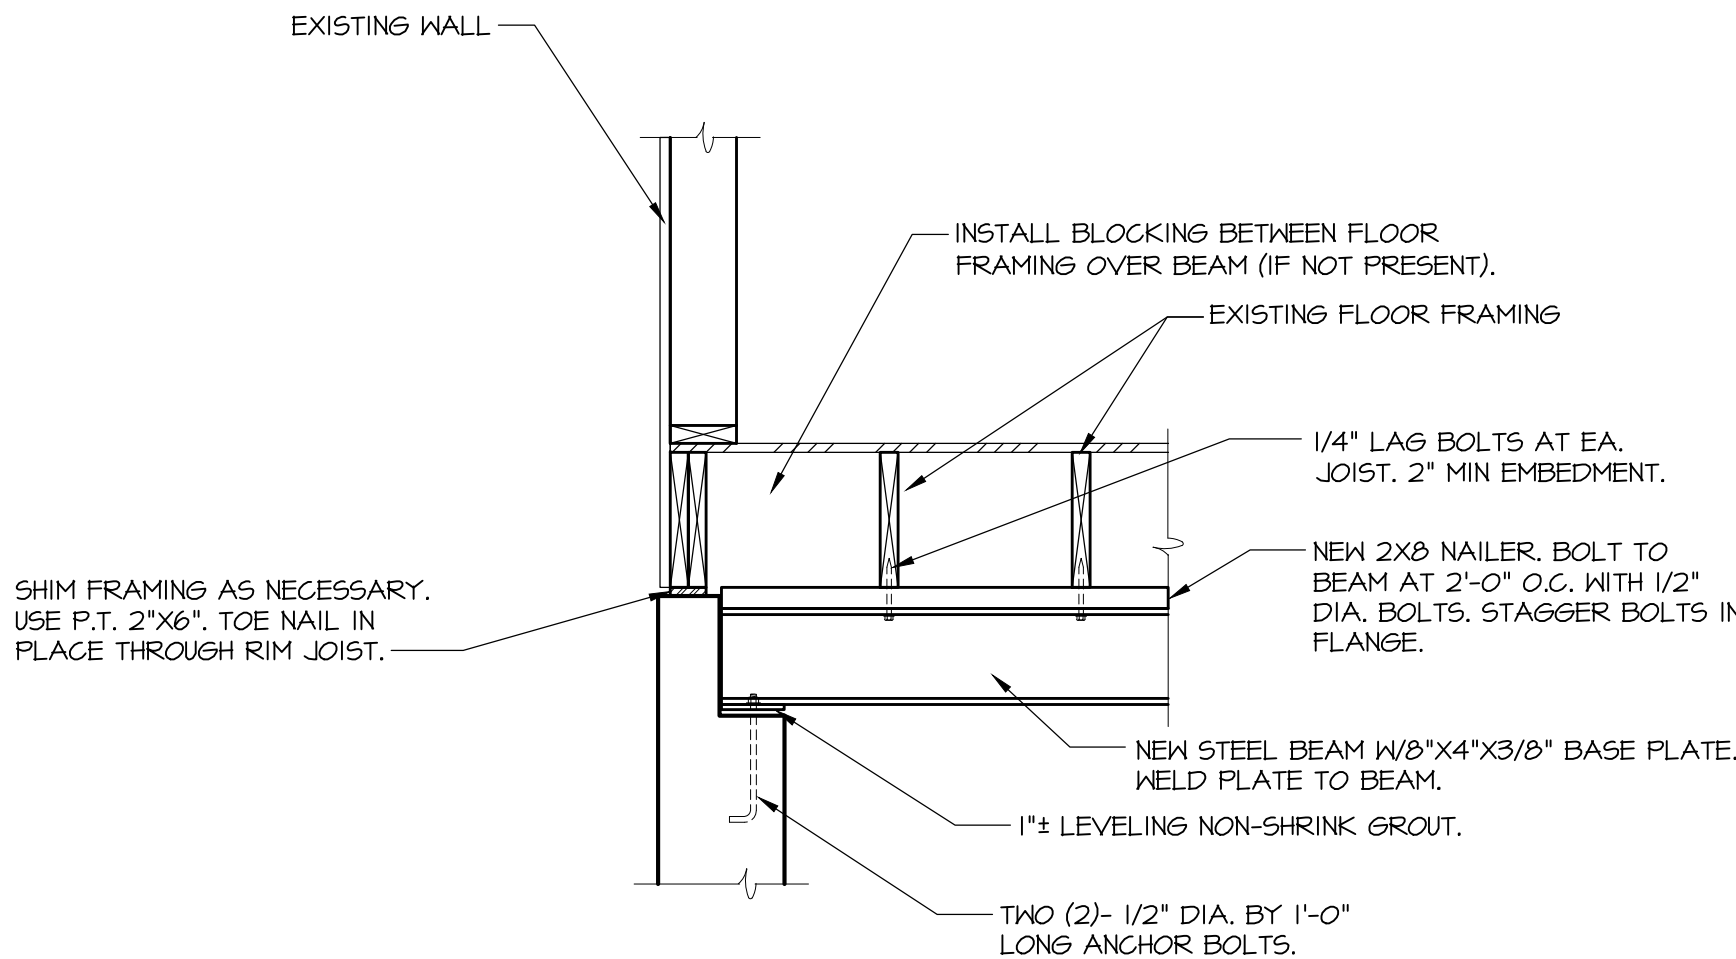


STEEL BEAM BEARING DETAILS

NO SCALE

5

52

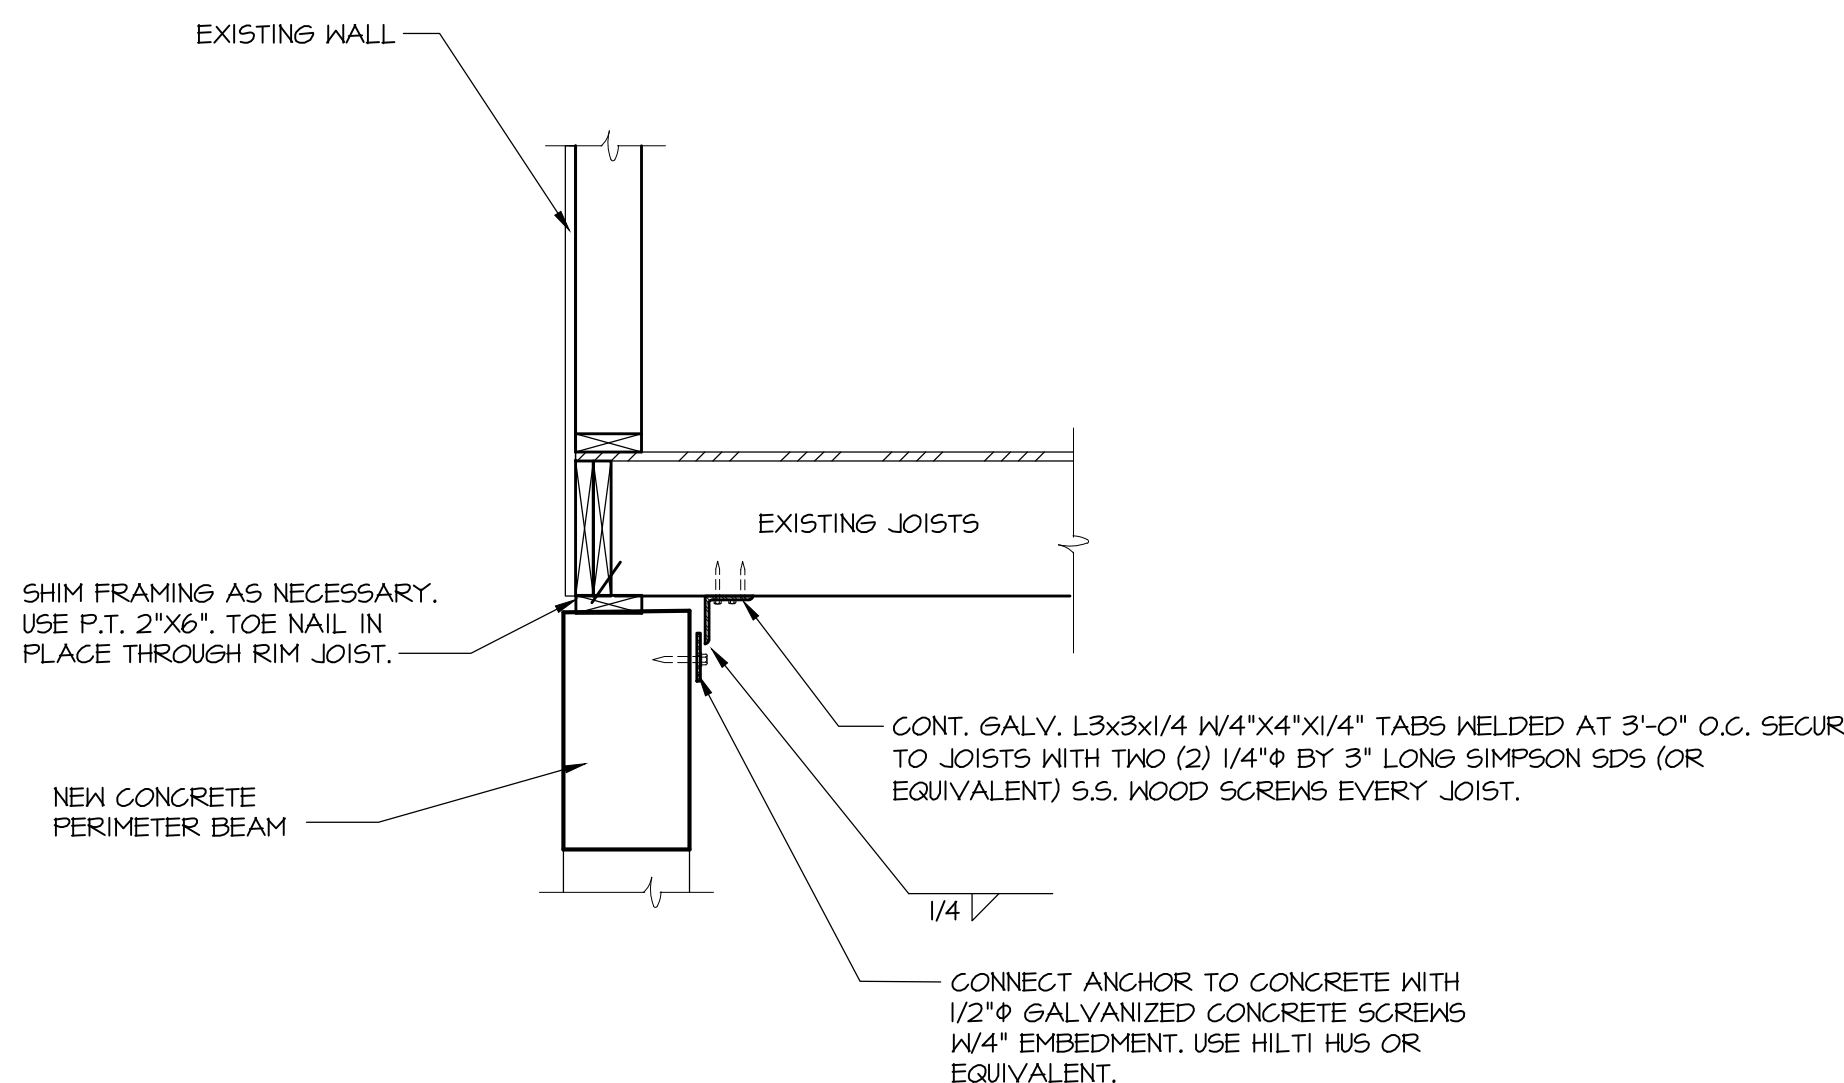


CONCRETE TO BLDG. CONNECTION DETAIL

NO SCALE

6

52

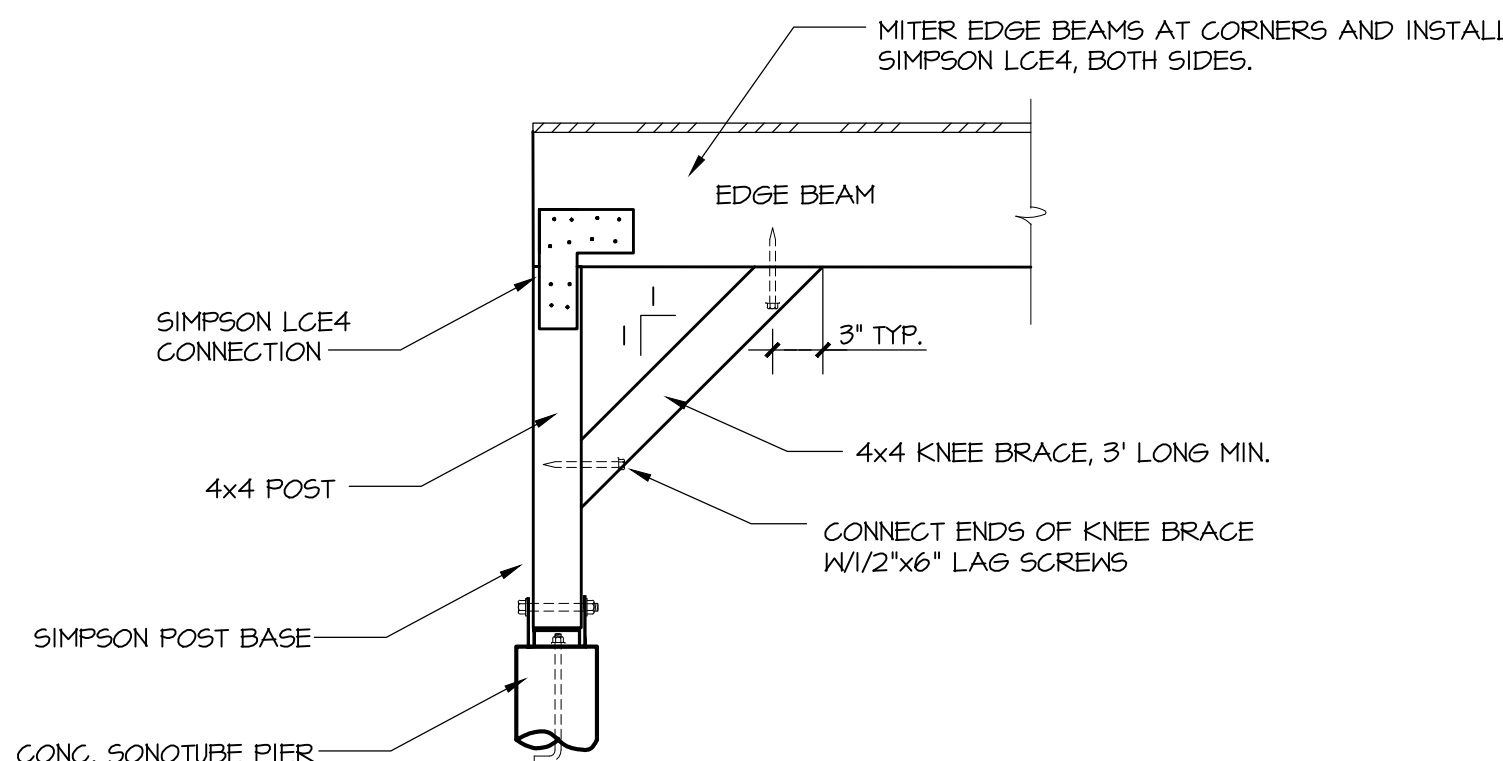

DECK KNEE BRACE CONNECTION DETAIL


NO SCALE

7

52

NOT FOR
CONSTRUCTION

Revisions	Date

 


The DiSalvo Engineering Group
Structural Engineers
63 Corporate Rd., Ridgefield, CT 06877
(860) 439-9581 | www.dieg.com

Aris Crist Architects
34 East Putnam Avenue
Greenwich, Connecticut 06830
203 661 0661

RESIDENCE No. 1260
35 HARBOR VIEW AVENUE
NORWALK, CT 06854
REPAIR DETAILS


JM	Drawn
GCF	Checked
03.27.15	Date
AS NOTED	Scale
13288.00	Job Number
	Sheet

S2

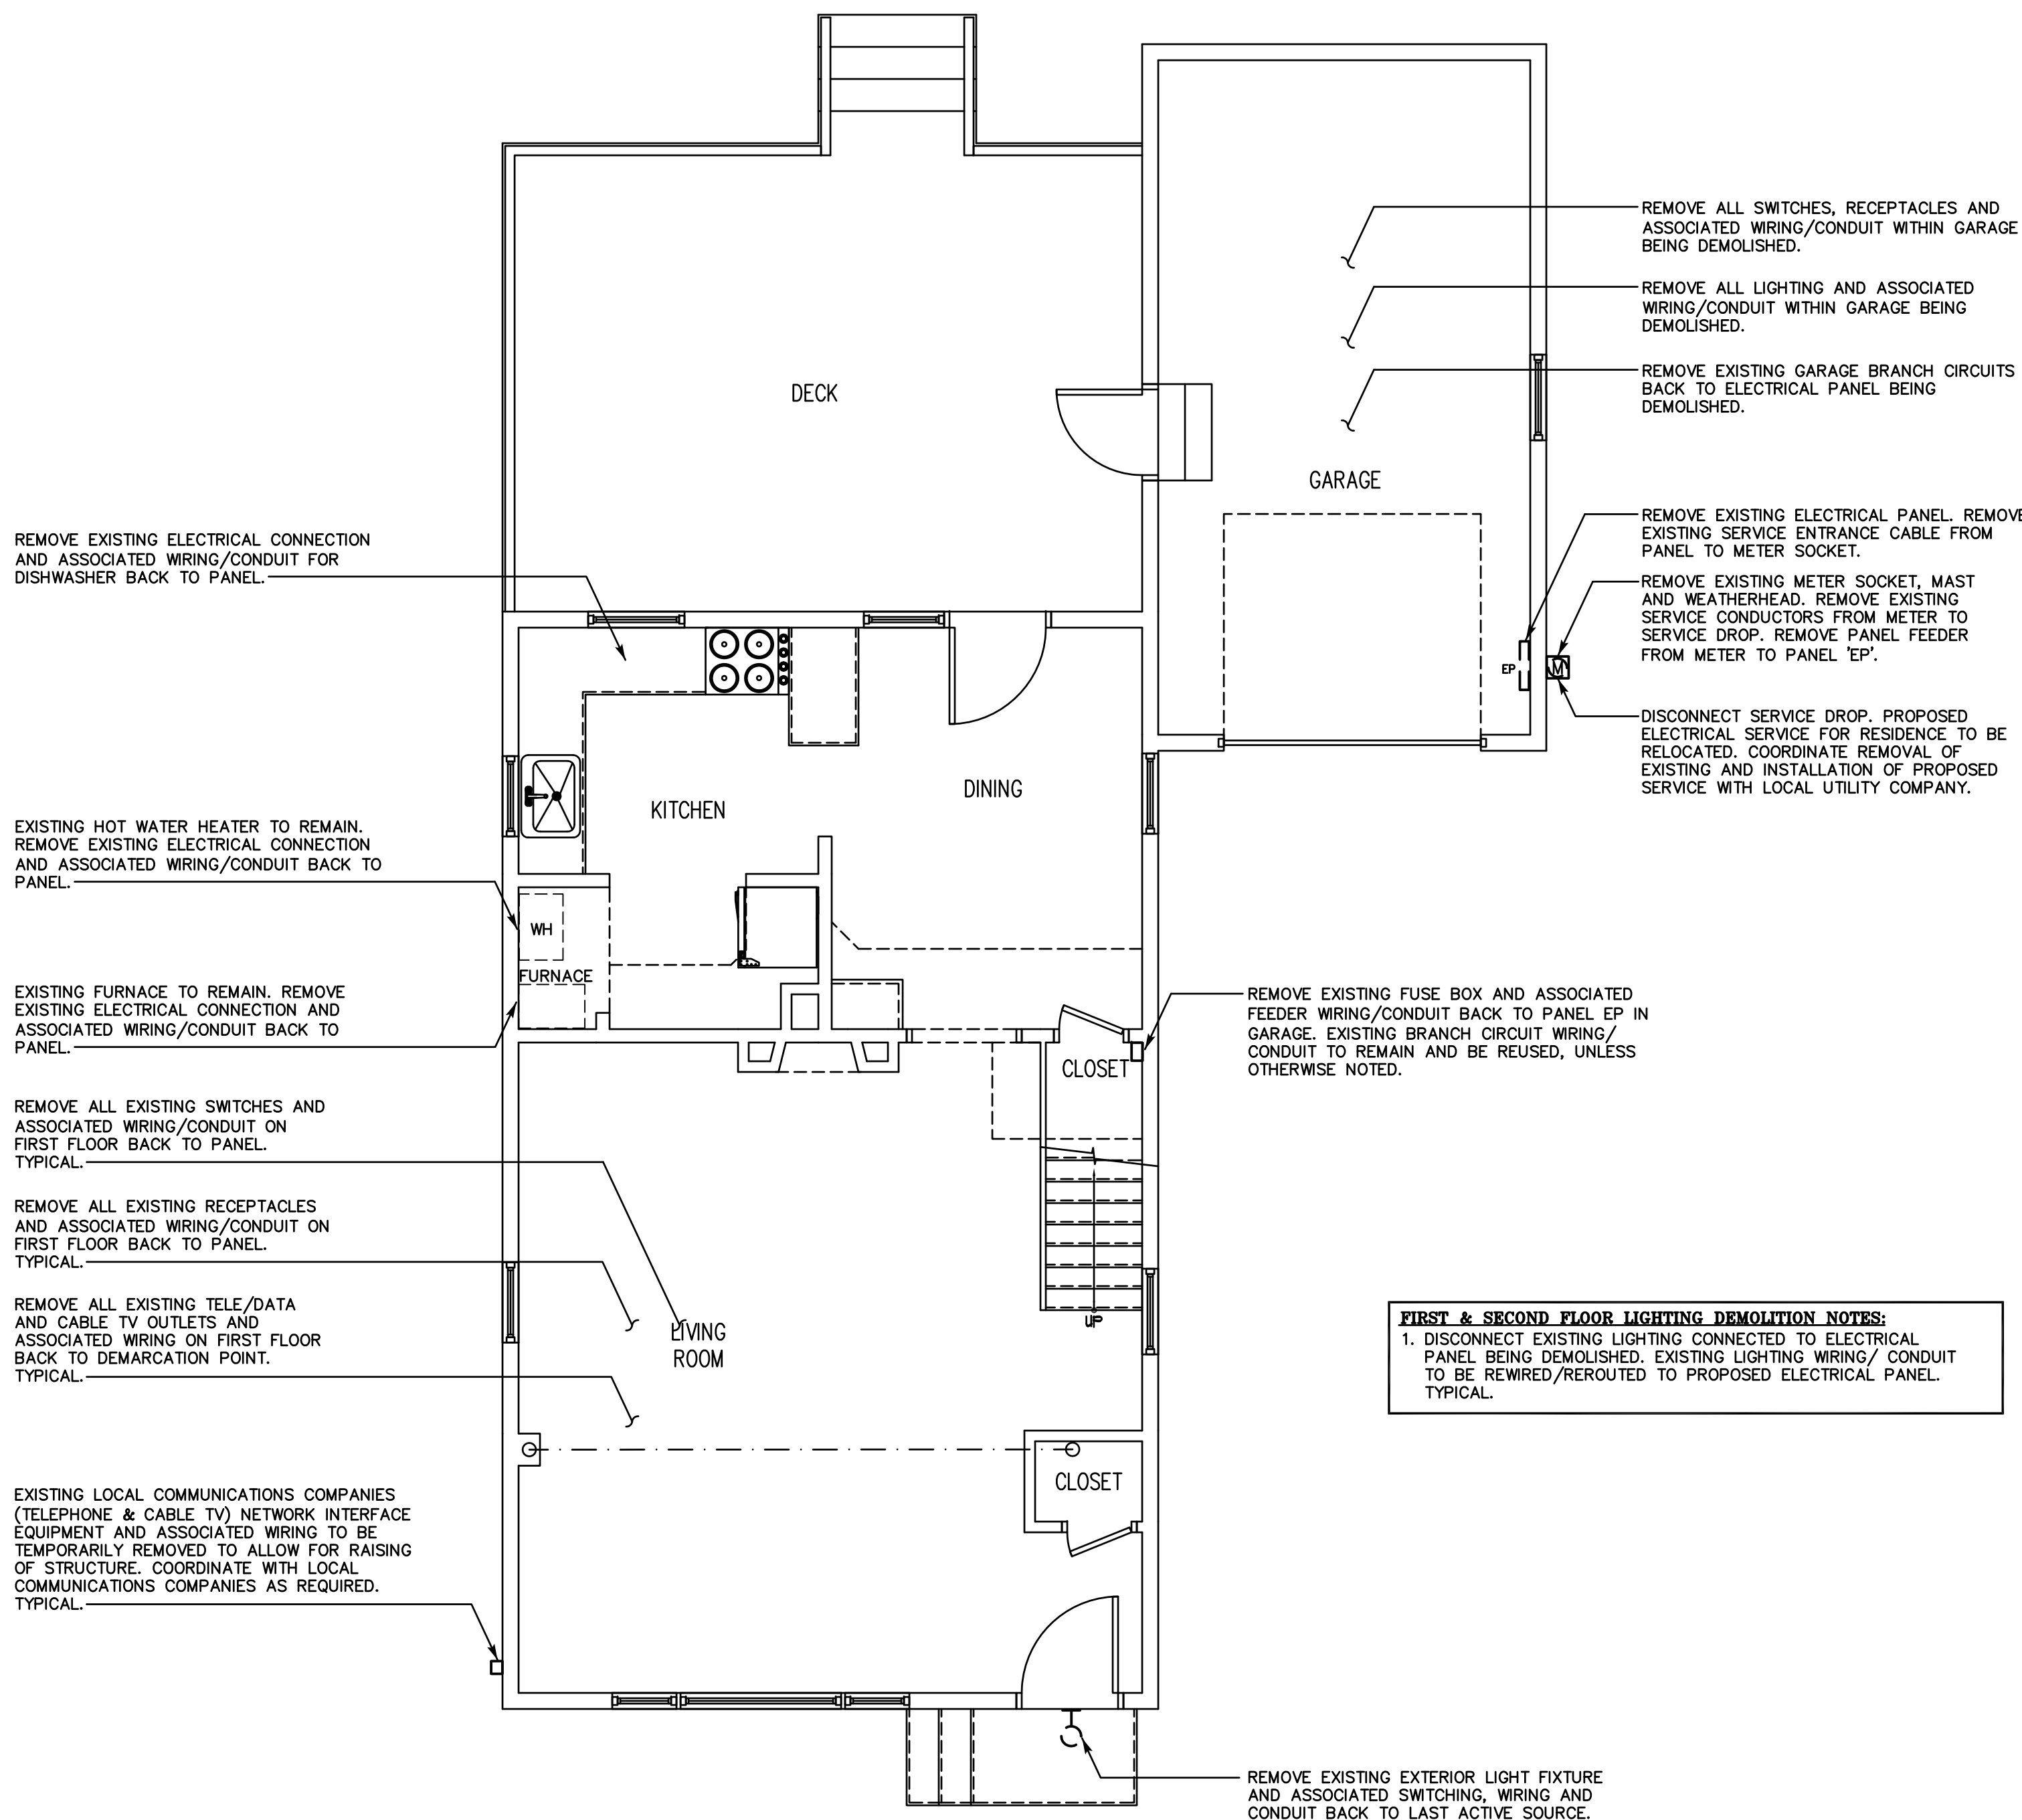

FIRST & SECOND FLOOR LIGHTING DEMOLITION NOTES:
1. DISCONNECT EXISTING LIGHTING CONNECTED TO ELECTRICAL PANEL BEING DEMOLISHED. EXISTING LIGHTING WIRING/ CONDUIT TO BE REWIRED/REROUTED TO PROPOSED ELECTRICAL PANEL. TYPICAL.

FIRST FLOOR ELECTRICAL DEMOLITION PLAN
SCALE: 1/4"=1'-0"

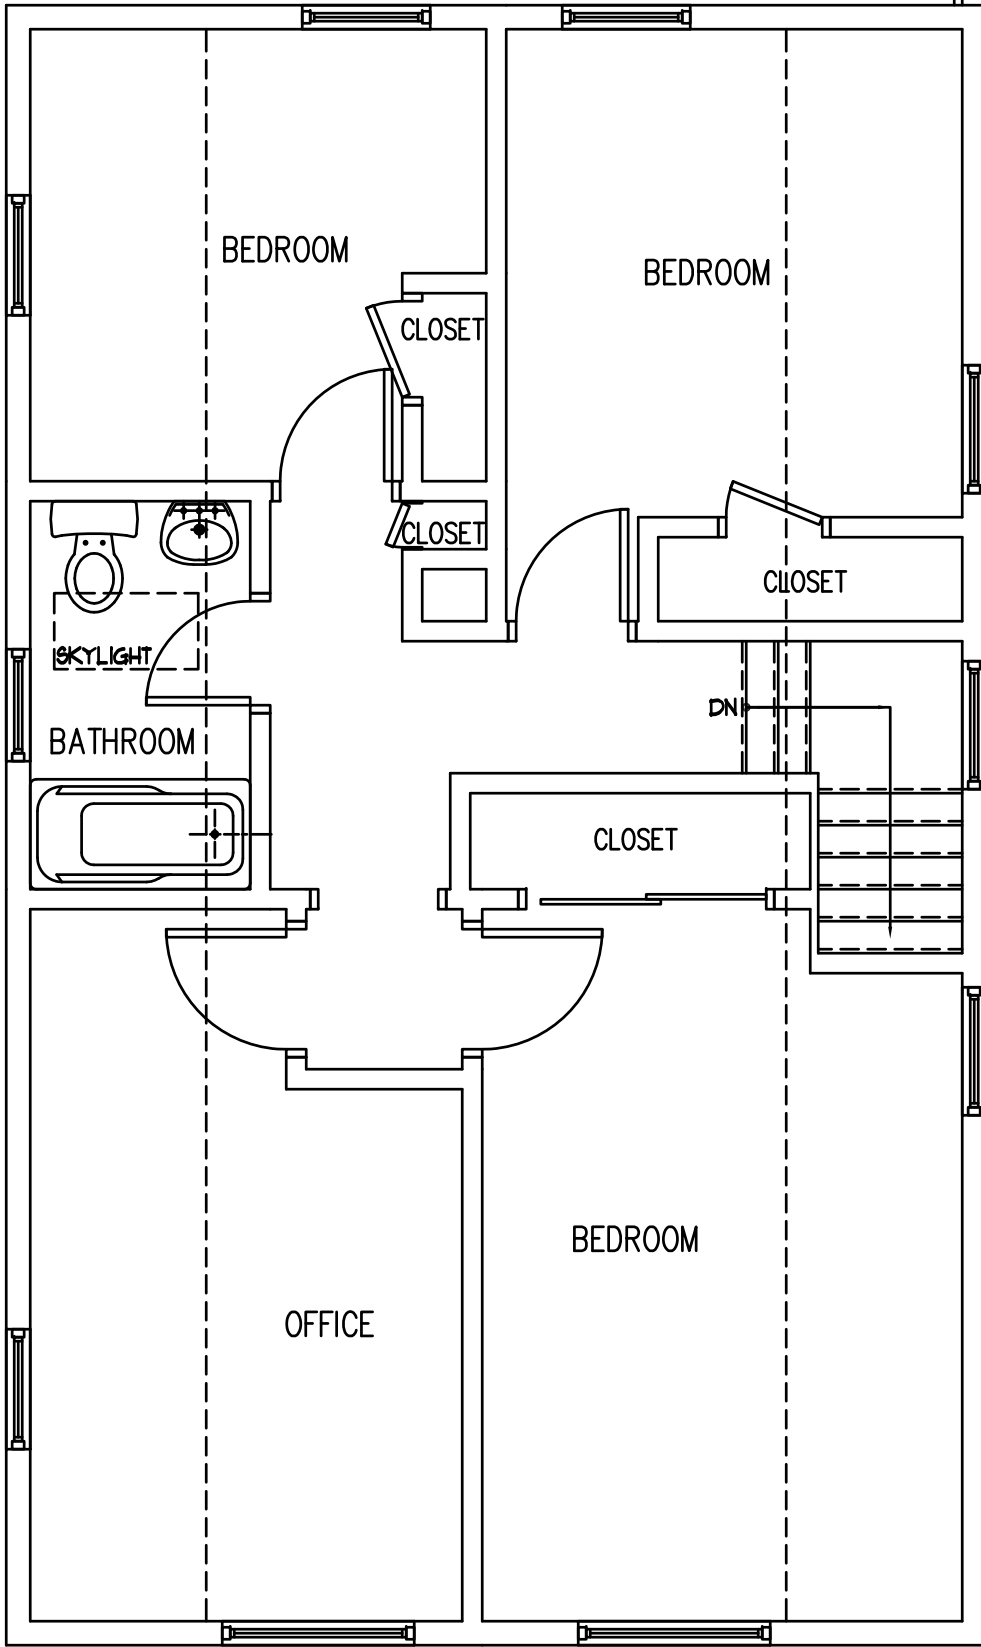

SECOND FLOOR DEMOLITION NOTES:
1. DISCONNECT EXISTING BRANCH CIRCUITS CONNECTED TO ELECTRICAL PANEL BEING DEMOLISHED. EXISTING BRANCH CIRCUITS WIRING/ CONDUIT TO BE REWIRED/REROUTED TO PROPOSED ELECTRICAL PANEL. TYPICAL.

SECOND FLOOR ELECTRICAL DEMOLITION PLAN
SCALE: 1/4"=1'-0"

- DEMOLITION NOTES:**
1. THE CONTRACTOR SHALL VISIT THE PROJECT SITE AND BECOME INFORMED AS TO THE NATURE AND SCOPE OF DEMOLITION WORK REQUIRED, NOTING AND ACCOUNTING FOR EXISTING CONDITIONS. TYPICAL.
 2. REMOVE AND PROPERLY DISPOSE OF EQUIPMENT AND ASSOCIATED COMPONENTS/ACCESSORIES AS INDICATED ON DEMOLITION PLANS. PROPERLY DISPOSE OF ALL DEMOLITION DEBRIS AS REQUIRED BY FEDERAL, STATE AND LOCAL CODES AND ORDINANCES. TYPICAL.
 3. CONTRACTOR SHALL NOT DAMAGE ANY EXISTING EQUIPMENT, PIPING, OR ASSOCIATED ACCESSORIES WHICH ARE TO REMAIN. ANY SUCH ITEMS DAMAGED SHALL BE REPLACED AT CONTRACTOR'S EXPENSE. TYPICAL.
 4. CONTRACTOR SHALL NOT DAMAGE ANY EXISTING ELECTRICAL CONNECTIONS, WIRING AND ASSOCIATED ACCESSORIES WHICH ARE TO REMAIN. ANY SUCH ITEMS DAMAGED SHALL BE REPLACED AT CONTRACTOR'S EXPENSE. TYPICAL.
 5. ALL DEMOLITION WORK SHALL BE PERFORMED IN A SAFE AND ORDERLY MANNER WITH QUALIFIED AND LICENSED PERSONNEL IN ACCORDANCE WITH STATE AND LOCAL GOVERNING AUTHORITIES AND ALL APPLICABLE CODES AND STANDARDS. COORDINATE WORK WITH ALL PROJECT DISCIPLINES AND EXISTING CONDITIONS. TYPICAL.
 6. DRAWINGS ARE DIAGRAMMATIC. CONTRACTOR SHALL FIELD VERIFY ALL EXISTING CONDITIONS INCLUDED IN AND RELATED TO THE PROJECT SCOPE OF WORK. TYPICAL.
 7. DO NOT DISTURB ANY SUSPECTED HAZARDOUS MATERIALS. NOTIFY OWNERS REPRESENTATIVE OR ANY SUSPECTED MATERIALS IMPEDING PERFORMANCE OF WORK. TYPICAL.
 8. CONTRACTOR SHALL COORDINATE WITH LOCAL UTILITY COMPANIES. CONTRACTOR RESPONSIBLE FOR ALL FEES ASSOCIATED WITH ANY AND ALL UTILITY COMPANIES TO COMPLETE SCOPE OF WORK.
 9. CONTRACTOR SHALL VERIFY ALL EXISTING EQUIPMENT SIZES AND LOCATIONS INFIELD AND PRIOR TO BIDDING.

Revisions	Date
Bid Set	04.06.15

CONSULTANT: **SALAMONE & ASSOCIATES, P.C.**
CONSULTING ENGINEERS
118 North Plains Industrial Road
Wallingford, Connecticut 06495
Tel: (860) 287-8780 Fax: (860) 287-8728


© ARIS CRIST AIA 2015.
THIS TECHNICAL DRAWING AND
THE ARCHITECTURAL WORK
DEPICTED ARE COPYRIGHTED BY
ARIS CRIST AIA

Aris Crist Architects
34 East Putnam Avenue
Greenwich, Connecticut 06830
203 661 0661


RESIDENCE No. 1260
35 HARBOR VIEW AVE.
NORWALK CT, 06854
ELECTRICAL DEMOLITION PLANS

JDB	Drawn
JAS	Checked
10.27.2014	Date
AS NOTED	Scale
	Job Number
	Sheet

DE-1.0

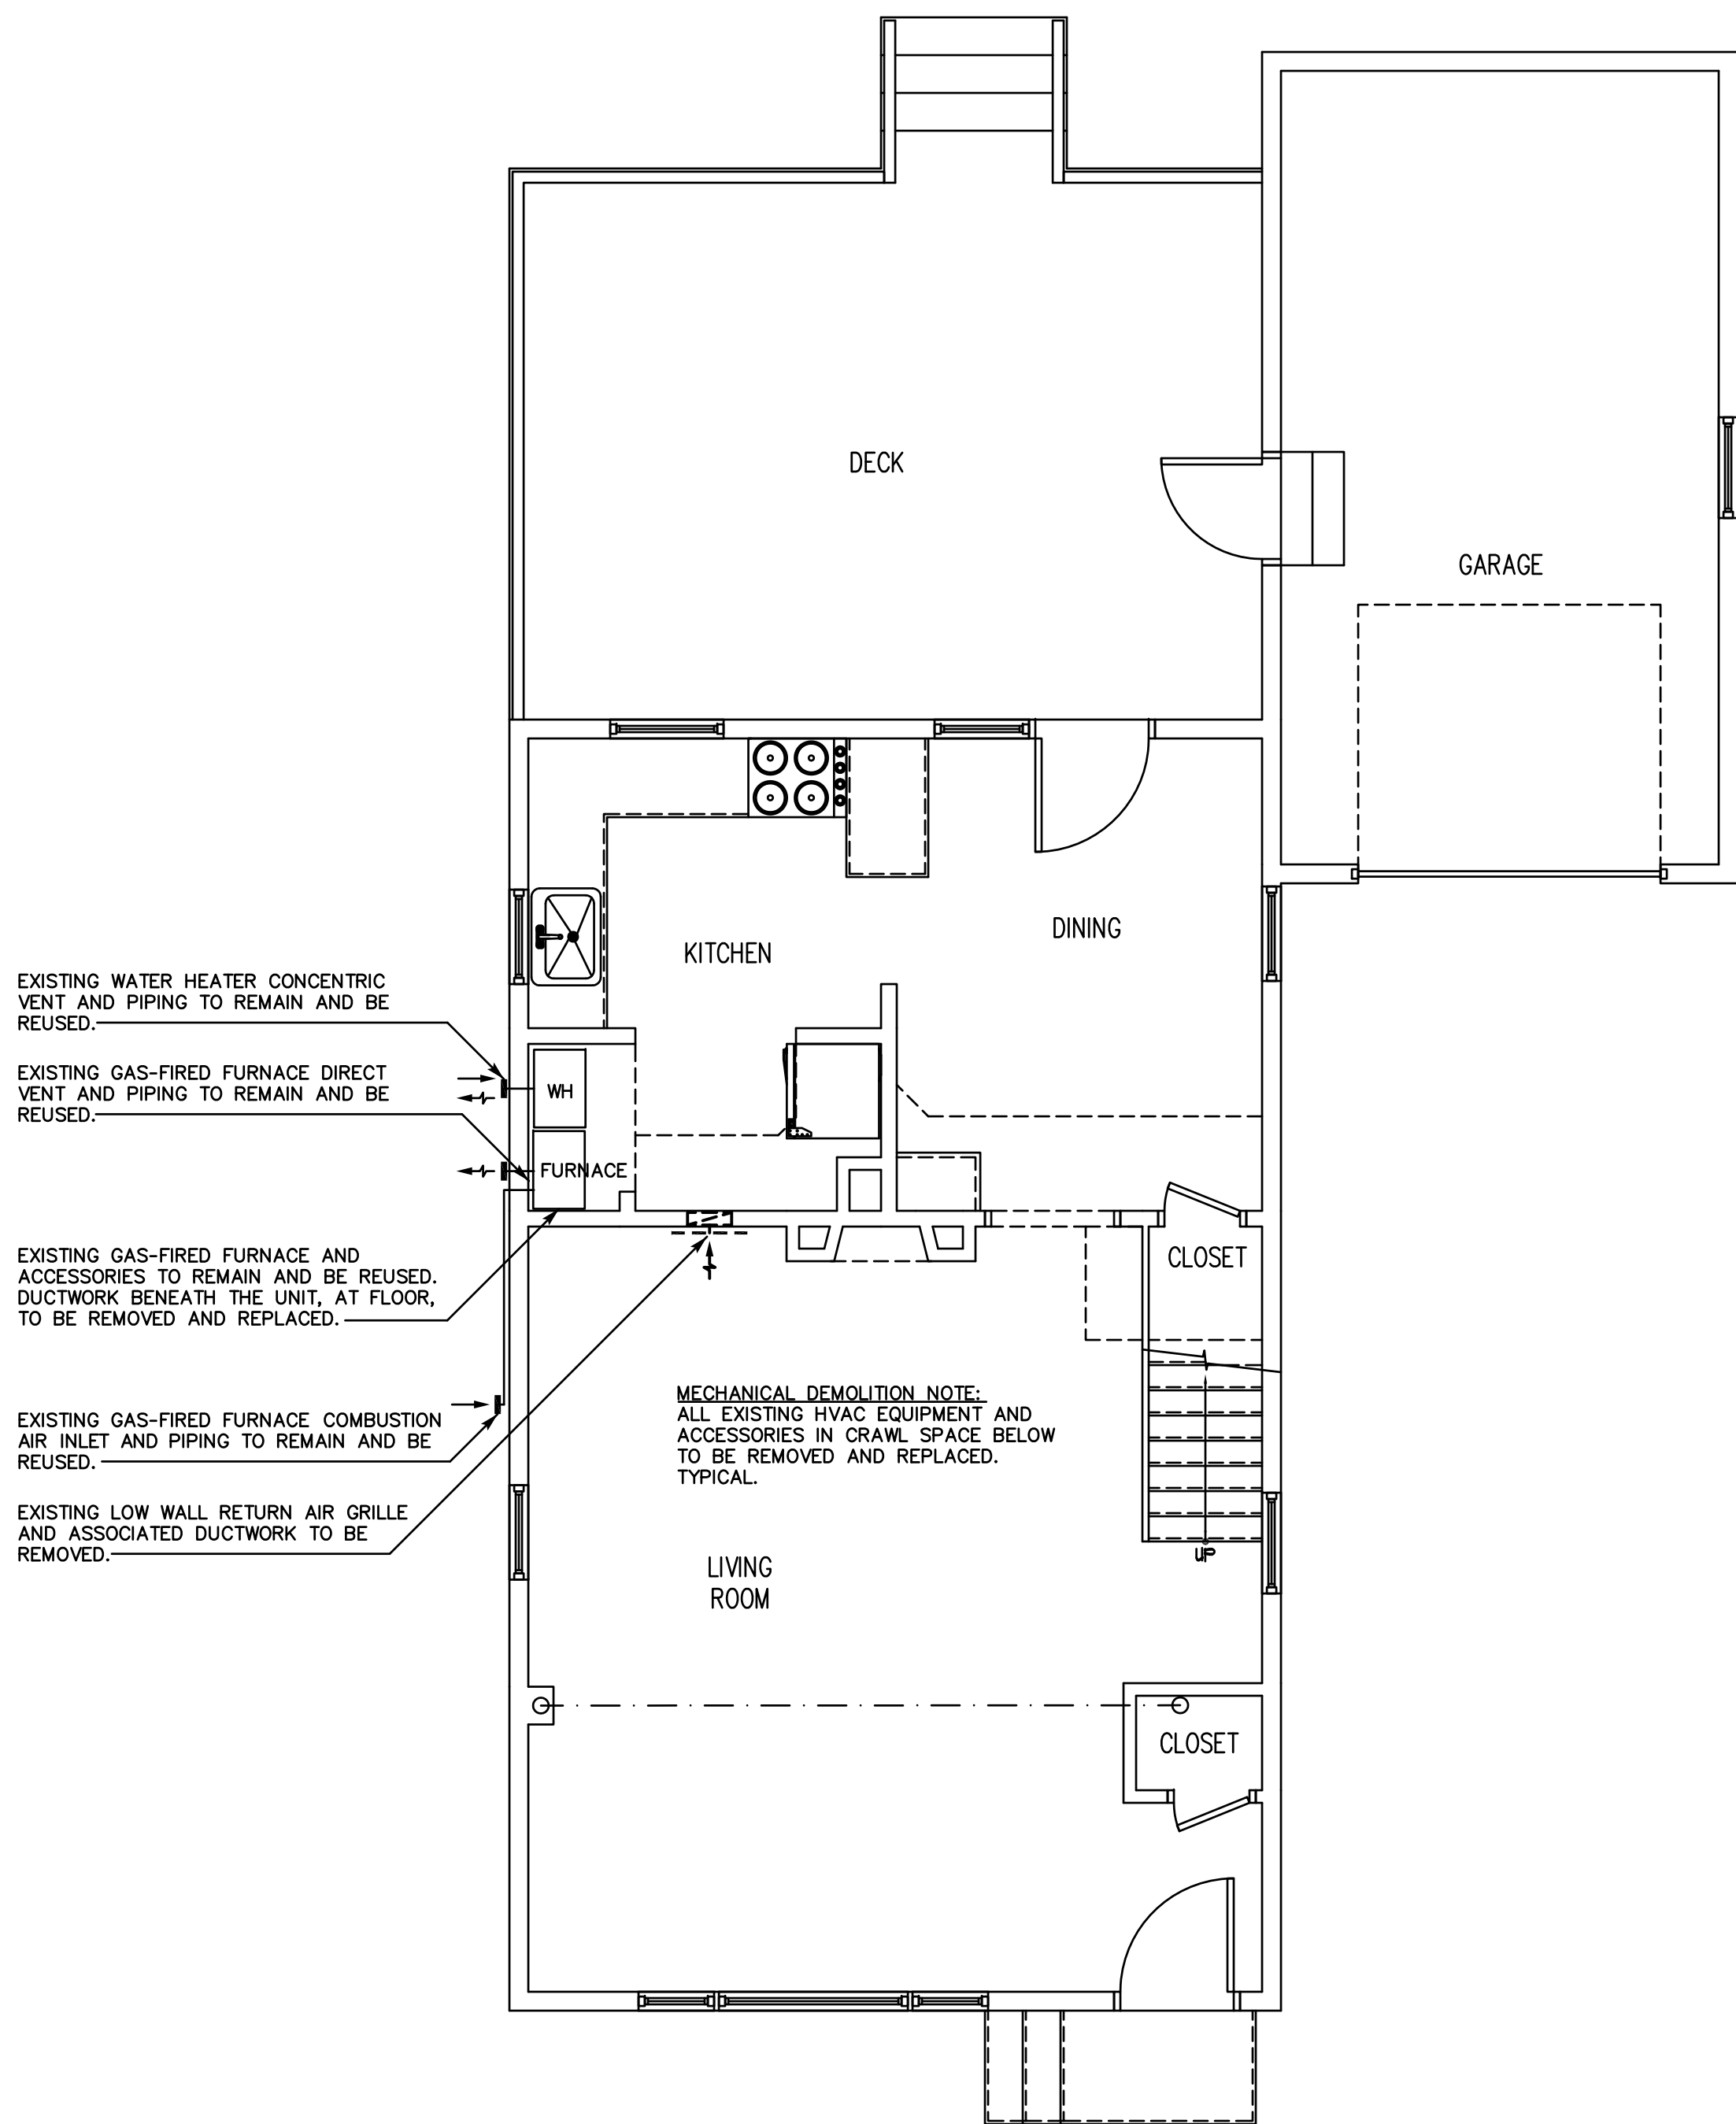

FIRST FLOOR MECHANICAL DEMOLITION PLAN
SCALE: 1/4"=1'-0"

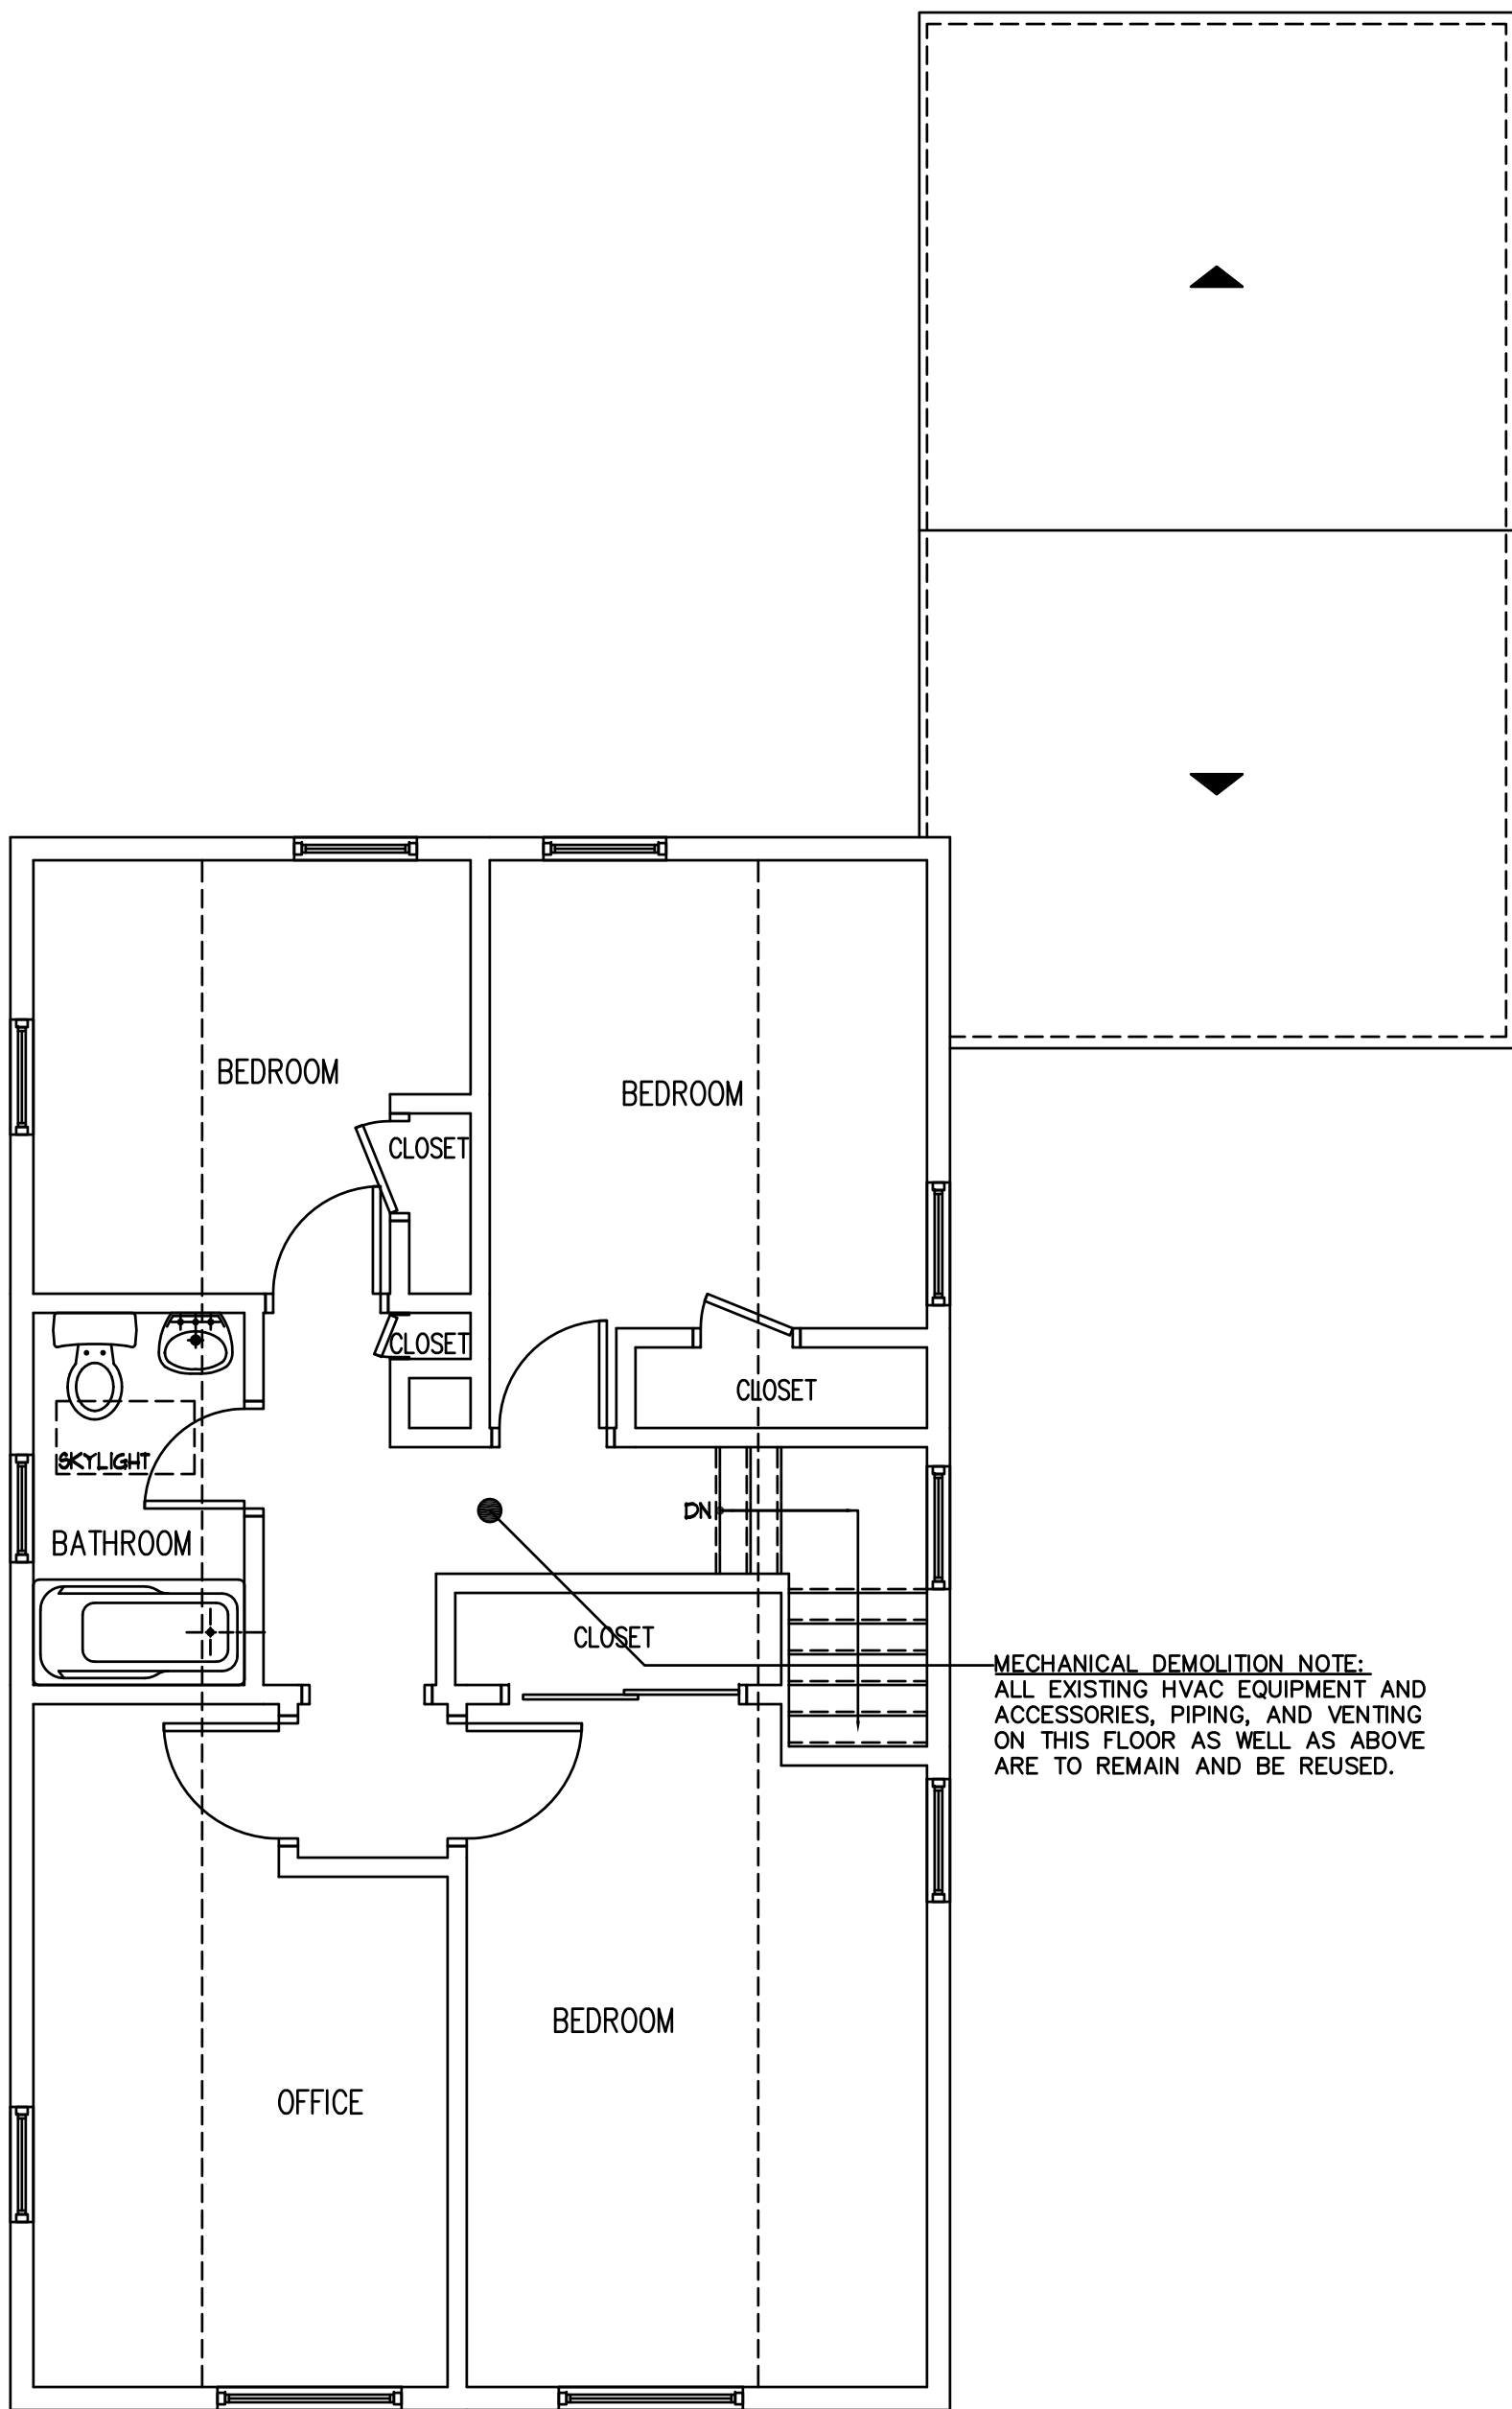

SECOND FLOOR MECHANICAL DEMOLITION PLAN
SCALE: 1/4"=1'-0"

- DEMOLITION NOTES:**
1. THE CONTRACTOR SHALL VISIT THE PROJECT SITE AND BECOME INFORMED AS TO THE NATURE AND SCOPE OF DEMOLITION WORK REQUIRED, NOTING AND ACCOUNTING FOR EXISTING CONDITIONS. TYPICAL.
 2. REMOVE AND PROPERLY DISPOSE OF EQUIPMENT AND ASSOCIATED COMPONENTS/ACCESSORIES AS INDICATED ON DEMOLITION PLANS. PROPERLY DISPOSE OF ALL DEMOLITION DEBRIS AS REQUIRED BY FEDERAL, STATE AND LOCAL CODES AND ORDINANCES. TYPICAL.
 3. CONTRACTOR SHALL NOT DAMAGE ANY EXISTING EQUIPMENT, PIPING, OR ASSOCIATED ACCESSORIES WHICH ARE TO REMAIN. ANY SUCH ITEMS DAMAGED SHALL BE REPLACED AT CONTRACTOR'S EXPENSE. TYPICAL.
 4. ALL DEMOLITION WORK SHALL BE PERFORMED IN A SAFE AND ORDERLY MANNER WITH QUALIFIED AND LICENSED PERSONNEL IN ACCORDANCE WITH STATE AND LOCAL GOVERNING AUTHORITIES AND ALL APPLICABLE CODES AND STANDARDS. COORDINATE WORK WITH ALL PROJECT DISCIPLINES AND EXISTING CONDITIONS. TYPICAL.
 5. CONTRACTOR SHALL PROVIDE MINIMUM OF 72 HOURS NOTICE PRIOR TO ANY EQUIPMENT/SERVICE SHUT DOWN.
 6. DRAWINGS ARE DIAGRAMMATIC. CONTRACTOR SHALL FIELD VERIFY ALL EXISTING CONDITIONS INCLUDED IN AND RELATED TO THE PROJECT SCOPE OF WORK. TYPICAL.
 7. ALL EXISTING DUCTWORK, REGISTERS, GRILLES, AND ASSOCIATED ACCESSORIES TO REMAIN IN PLACE AND BE REUSED UNLESS OTHERWISE NOTED.TYPICAL.

Revisions	Date
Bld Set	04.06.15

CONSULTANT
SALAMONE & ASSOCIATES, P.C.
CONSULTING ENGINEERS
118 North Plains Industrial Road
Wallingford, Connecticut 06495
Tel: (860) 287-8780
Fax: (860) 287-8728


© ARIS CRIST AIA 2015.
THIS TECHNICAL DRAWING AND
THE ARCHITECTURAL WORK
DEPICTED ARE COPYRIGHTED BY
ARIS CRIST AIA

Aris Crist Architects
34 East Putnam Avenue
Greenwich, Connecticut 06830
203 661 0661

RESIDENCE No. 1260
35 HARBOR VIEW AVE.
NORWALK CT, 06854
MECHANICAL DEMOLITION PLANS

JDB	Drawn
JAS	Checked
10.27.2014	Date
AS NOTED	Scale
	Job Number
	Sheet

DM-1.0

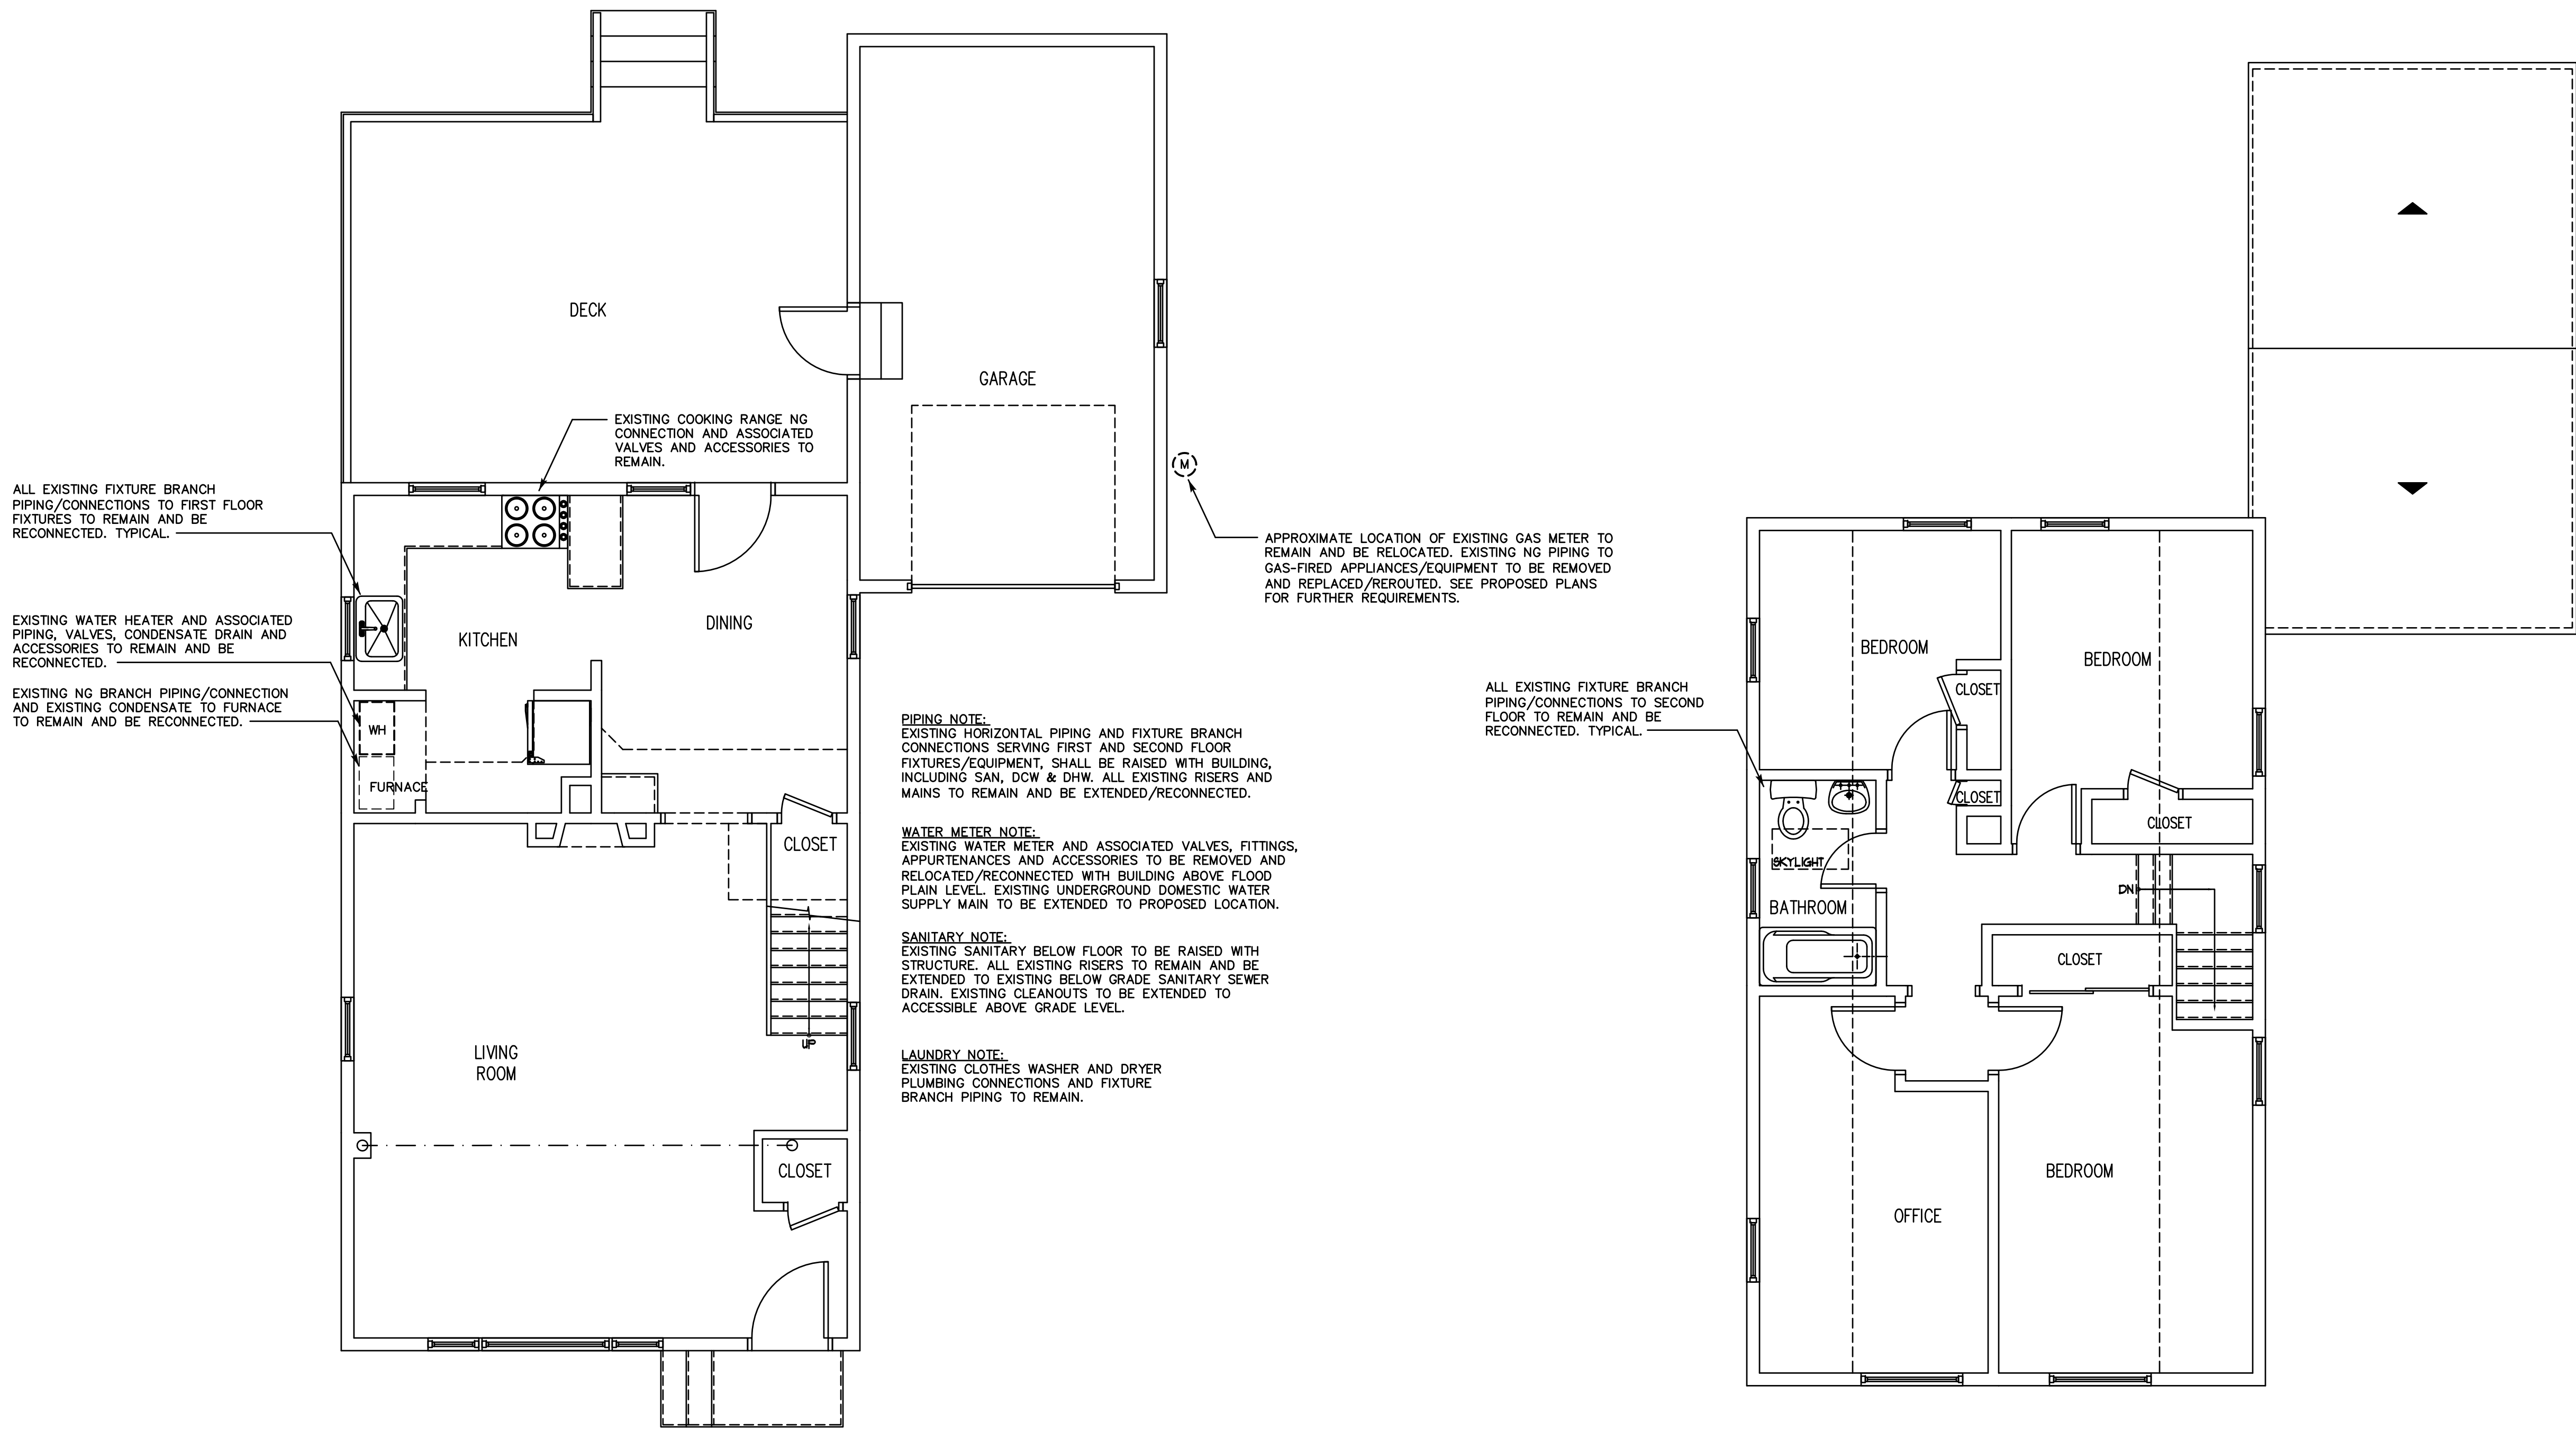

Revisions	Date
Bld Set	04.06.15

CONSULTANT

SALAMONE & ASSOCIATES, P.C.

CONSULTING ENGINEERS

118 North Plains Industrial Road
Wallingford, Connecticut 06495
Tel: (860) 287-8780 Fax: (860) 287-8728

© ARIS CRIST AIA 2015.
THIS TECHNICAL DRAWING AND
THE ARCHITECTURAL WORK
DEPICTED ARE COPYRIGHTED BY
ARIS CRIST AIA

Aris Crist Architects

34 East Putnam Avenue
Greenwich, Connecticut 06830
203 661 0661

RESIDENCE No. 1260

35 HARBOR VIEW AVE.
NORWALK CT, 06854

PLUMBING DEMOLITION PLANS

JDB	Drawn
JAS	Checked
10.27.2014	Date
AS NOTED	Scale
	Job Number
	Sheet

DP-1.0

Revisions	Date
Bid Set	04.06.15

CONSULTANT:

**SALAMONE
&
ASSOCIATES, P.C.**

CONSULTING ENGINEERS

116 North Plains Industrial Road
Wallingford, Connecticut 06492
Phone: (203) 281-6896
Fax: (203) 287-8728

© ARIS CRIST AIA 2015.
THIS TECHNICAL DRAWING AND
THE ARCHITECTURAL WORK
DEPICTED ARE COPYRIGHTED BY
ARIS CRIST AIA

Aris Crist Architects
34 East Putnam Avenue
Greenwich, Connecticut 06830
203 661 0661

RESIDENCE No. 1260

35 HARBOR VIEW AVE.
NORWALK CT, 06854

ELECTRICAL PLANS

JDB	Drawn
JAS	Checked
10.27.2014	Date
AS NOTED	Scale
	Job Number
	Sheet

E-1.0

ELECTRICAL NOTES:

1. THE CONTRACTOR(S) SHALL VISIT THE PROJECT SITE PRIOR TO BIDDING, NOTING EXISTING CONDITIONS AND EQUIPMENT. IF SAID IS NOT BEING REMOVED AS PART OF PROJECT OR IS NOTED AS EXISTING TO REMAIN, THE CONTRACTOR(S) SHALL REMOVE EQUIPMENT AND/OR PROVIDING PROPOSED SCOPE OF WORK. EQUIPMENT SHALL BE TEMPORARILY RELOCATED AND COMPLETELY REINSTALLED AFTER PROPOSED SCOPE OF WORK IS COMPLETED. THE BID SHALL REFLECT THE CONTRACTOR(S) AND CONTRACTOR(S) SHALL BID ACCORDINGLY, NO ADDITIONAL COMPENSATION WILL BE CONSIDERED FOR RELATED WORK OF COORDINATION WITH EXISTING CONDITIONS.
2. REMOVE AND PROPERLY DISPOSE OF EQUIPMENT AND ASSOCIATED COMPONENTS/ACCESSORIES AS INDICATED ON DEMOLITION PLANS. PROPERLY DISPOSE OF ALL DEMOLITION DEBRIS AS REQUIRED BY FEDERAL, STATE AND LOCAL CODES AND ORDINANCES. TYPICAL.
3. CONTRACTOR SHALL NOT DAMAGE ANY EXISTING EQUIPMENT, PIPING, OR ASSOCIATED MATERIALS THAT ARE TO REMAIN. IF SUCH ITEMS DAMAGED SHALL BE REPLACED AT CONTRACTOR'S EXPENSE. TYPICAL.
4. THE CONTRACTOR SHALL BE RESPONSIBLE FOR ALL WORK INCLUDING TOOLS, MATERIAL, MANPOWER, ETC. REQUIRED FOR COMPLETE AND PROPER INSTALLATION OF PROPOSED MATERIALS, FIXTURES AND/OR EQUIPMENT.
5. DO NOT DISTURB ANY SUSPECTED HAZARDOUS MATERIALS. NOTIFY OTHERS REPRESENTATIVE OF ANY SUSPECTED MATERIALS IMPEDING PERFORMANCE. WORK TYPICAL.
6. ALL DEMOLITION WORK SHALL BE PERFORMED IN A SAFE AND ORDERLY MANNER WITH QUALIFIED AND LICENSED PERSONNEL IN ACCORDANCE WITH STATE AND LOCAL GOVERNING AUTHORITIES AND ALL APPLICABLE REGULATIONS. DEMOLITION WORK SHALL BE IN ACCORDANCE WITH ALL PROJECT DISCIPLINES AND EXISTING CONDITIONS. TYPICAL.

EXISTING CIRCUITS NOTES:

1. CONTRACTOR SHALL EXTEND EXISTING BRANCH CIRCUITS TO PROPOSED ELECTRICAL PANEL LOCATION PER NEC.
2. UNDERSIDE OF FIRST FLOOR SHALL BE SPRAYED WITH FOAM INSULATION. ALL JUNCTION BOXES SHALL BE INSTALLED SUCH THAT THEY ARE ACCESSIBLE ONCE SPRAY FOAM INSULATION IS INSTALLED.
3. WHERE JUNCTION BOXES WILL NOT BE ACCESSIBLE ONCE SPRAY FOAM INSULATION IS INSTALLED, CONTRACTOR SHALL REMOVE CONDUIT TO NEXT ACCESSIBLE POINT/BOX AND PROVIDE AN ENTIRE SECTION OF WIRING/CONDUIT WITHOUT JUNCTION/SPLICE BOXES FROM ACCESSIBLE POINT/BOX BACK TO ELECTRICAL PANEL.
4. ALL JUNCTION/SPLICE BOXES BELOW FIRST FLOOR SHALL BE WEATHERPROOF.
5. ALL NON-METALLIC SHEATHED CABLE LOCATED BELOW FIRST FLOOR SHALL BE ROUTED WITHIN CONDUIT PER NEC REQUIREMENTS.
6. ALL SERVICE ENTRANCE CABLE SHALL BE INSTALLED WITHIN CONDUIT PER NEC REQUIREMENTS.

WIRING NOTES:

1. ALL WIRING SHALL BE COPPER THHN/THWN WITH EXCEPTION OF SERVICE ENTRANCE CONDUCTORS.
2. CONTRACTOR MAY UTILIZE ALUMINUM WIRING FOR SERVICE ENTRANCE CONDUCTORS ONLY.
3. ALL WIRING SHALL BE CONCEALED BEHIND WALL/CEILING SURFACES IN ALL FINISHED AREAS.
4. CONTRACTOR SHALL PROVIDE MINIMUM 1/2" CONDUIT FOR #14 AWG, #12 AWG AND #10 AWG CIRCUITS AND 3/4" CONDUIT FOR #8 AWG CIRCUITS. CONTRACTOR SHALL INCREASE CONDUIT SIZES AS REQUIRED PER NEC SO THAT CONDUIT FILL ALLOWED BY NEC IS NOT EXCEEDED. CONDUIT TYPE SHALL BE MC CABLE FOR INTERIOR AND LOMC CABLE FOR EXTERIOR LOCATIONS, UNLESS OTHERWISE NOTED.
5. CONTRACTOR MAY UTILIZE NONMETALLIC-SHEATHED CABLE FOR BRANCH CIRCUITS IN INTERIOR DRY LOCATIONS.

WIRING DEVICE NOTES:

1. CONTRACTOR SHALL COORDINATE RECEPTACLE AND SWITCH COLORS WITH ARCHITECT PRIOR TO ORDERING AND INSTALLATION. PROVIDE MATCHING COVER PLATE. TYPICAL.
2. CONTRACTOR SHALL PROVIDE RED EMERGENCY SWITCH COVER PLATE WITH ON/OFF DIRECTION FOR FURNACE AND HOT WATER HEATER CIRCUITS.

TELE/DATA & CABLE TV NOTES:

1. CONTRACTOR SHALL PROVIDE TELE/DATA AND CABLE TV OUTLETS ON FIRST FLOOR. INSTALL AT LOCATIONS OF DEMOLISHED TELE/DATA OUTLETS.


2. CONTRACTOR SHALL PROVIDE MINIMUM CAT 5E TELE/DATA WIRING AND RG6 COAXIAL CABLE WIRING FROM RESPECTIVE OUTLETS BACK TO DEMARCATION POINTS. COORDINATE WITH LOCAL UTILITY COMPANIES.

RECEPTACLE NOTES:

- RECEPTACLE NOTES:**
1. CONTRACTOR SHALL PROVIDE TAMPER RESISTANT RECEPTACLES PER ARTICLE 406.12 OF THE NEC.


HEAT TRACE NOTES:

1. CONTRACTOR SHALL PROVIDE 3 WATTS PER FOOT, LOW TEMP., SELF REGULATING HEAT TRACE (THERMOSTATICALLY CONTROLLED) FOR EXPOSED EXTERIOR COPPER DOMESTIC WATER SERVICE PIPING. 1" MIN. ABOVE. COORDINATE LENGTH REQUIRED WITH PLUMBING CONTRACTOR. EMERSON FREEZE FREE WITH EH38 THERMOSTAT CONTROL.
2. CONTRACTOR SHALL PROVIDE 5 WATTS PER FOOT, IN-LINE HEAT TRACE WITH THERMOSTAT FOR EXPOSED EXTERIOR PE TYPE DOMESTIC WATER SERVICE PIPING WITH PIPE SIZES OF 1" AND 1 1/2" MIN. ALL OTHERS TO BE PROVIDED BY THE PLUMBING CONTRACTOR. EMERSON EASY HEAT WITH SL20 CONTROL.
3. PROVIDE ELECTRICAL CONNECTION AND INSTALL PER NEC AND MANUFACTURERS REQUIREMENTS, CONNECT PANEL CIRCUIT #13. SEE SCHEDULE FOR FURTHER REQUIREMENTS.

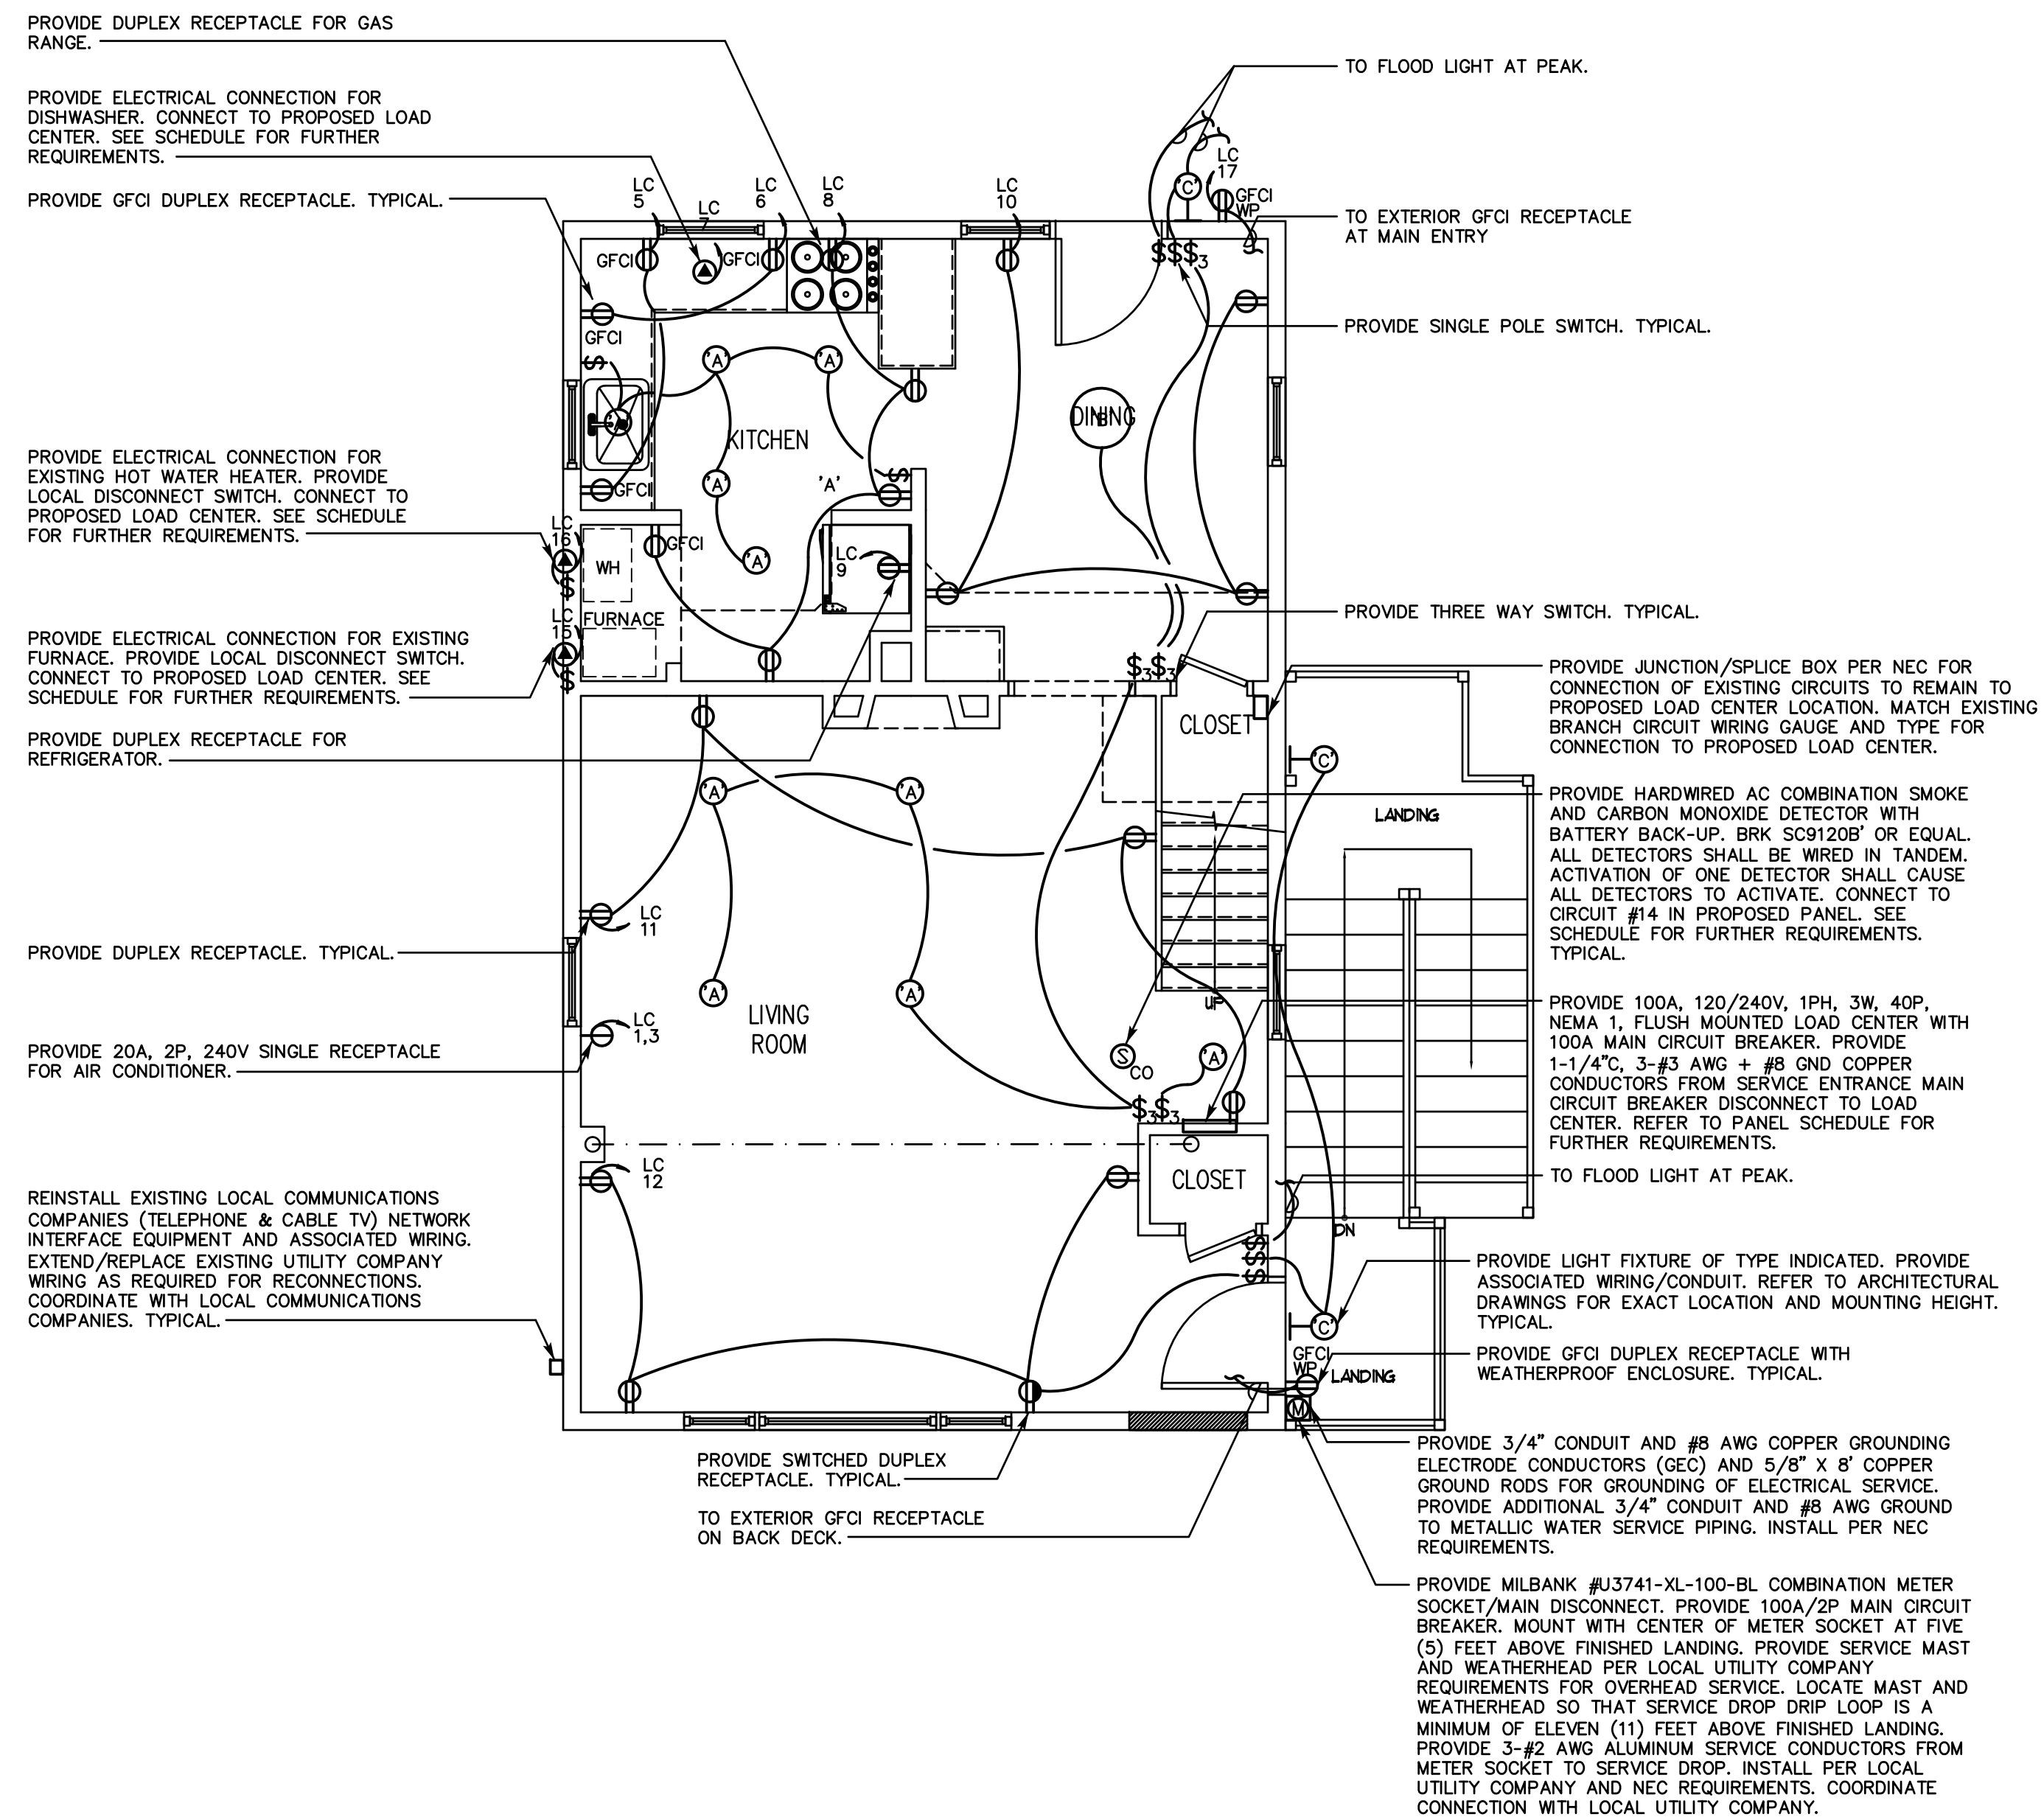

FIRST FLOOR ELECTRICAL PLAN

SCALE: $\frac{1}{4}"=1'-0"$

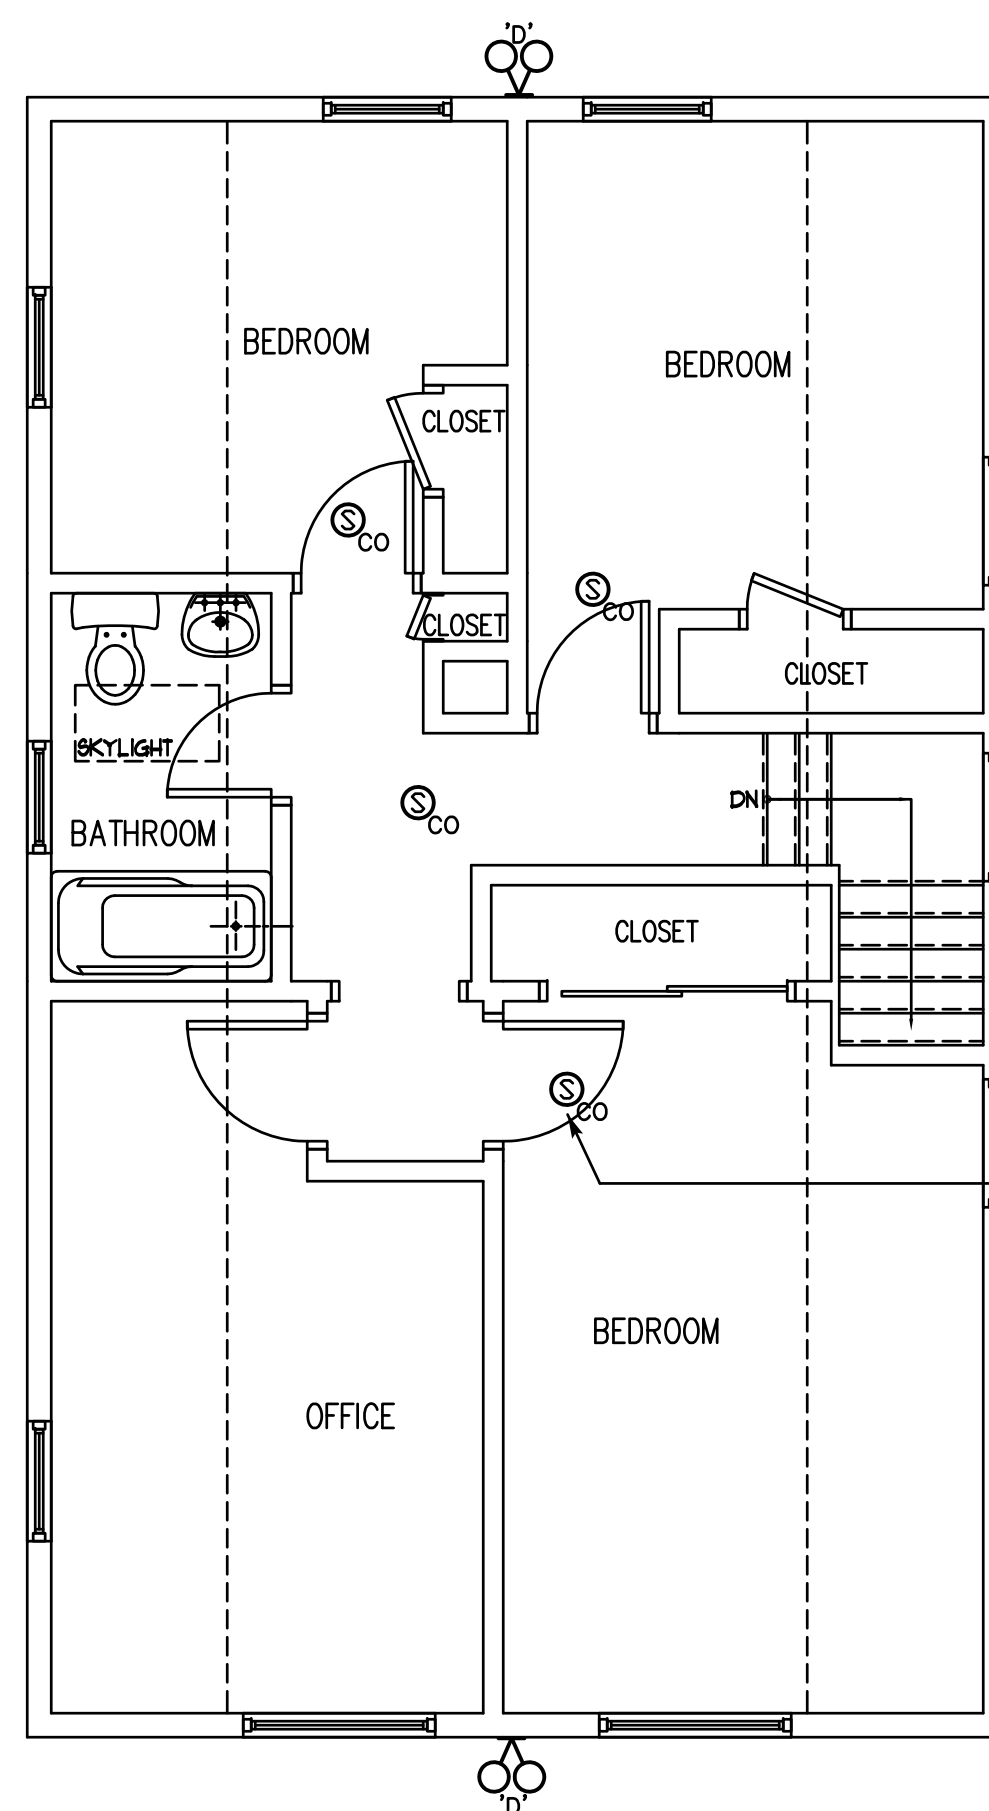

SECOND FLOOR ELECTRICAL PLAN

SCALE: $\frac{1}{4}"=1'-0"$

PANELBOARD LC		Class: Type:				Short Circuit Rating (Min.): 10 K.A.I.C. Remark:	
SERVICE		120/240 Volts 1 Phase 3 Wire				S/E Label: YES	
PANELBOARD CONFIGURATION		100 AMPERE MAIN BUS Trim: RECESSED				Entrance: BOTTOM Equipment Ground Bus: YES	
MAIN		Type: 100A MCB Wire Size: 1-1/4"C, 3-#3 AWG + #8 GND (COPPER)					
BRANCH CIRCUITS		Branch Protective Devices: (MOLDED CASE CIRCUIT BREAKERS)					
Circ No	Circuit Designation	KVA Load	Pole	Trip Amps	Frame Amps	Wire (min.)	See Remark
1	A/C RECEPT - LIVING ROOM	-	2	20	100	3-#12 AWG	'A'
2	DRYER	-	2	30	100	4-#10 AWG	'A'
3	- - -	-	-	-	-	- - -	
4	- - -	-	-	-	-	- - -	
5	RECEPT -GFCI KITCHEN COUNTER	1.5	1	20	100	3-#12 AWG	
6	RECEPT -GFCI KITCHEN COUNTER	1.5	1	20	100	3-#12 AWG	
7	DISHWASHER	1.5	1	20	100	3-#12 AWG	
8	RECEPT -RANGE & KITCHEN	1.0	1	20	100	3-#12 AWG	'A'
9	REFRIGERATOR	0.9	1	20	100	3-#12 AWG	
10	RECEPT -DINING	0.8	1	20	100	3-#12 AWG	'A'
11	RECEPT -LIVING	0.8	1	20	100	3-#12 AWG	'A'
12	RECEPT -LIVING	0.8	1	20	100	3-#12 AWG	'A'
13	HEAT TRACE -WATER SERVICE	0.4	1	15	100	3-#14 AWG	
14	SMOKE/CO DETECTORS	0.1	1	15	100	3-#14 AWG	'A'
15	FURNACE	-	1	15	100	3-#14 AWG	
16	WATER HEATER	-	1	15	100	3-#14 AWG	
17	EXT. GFCI RECEPT	0.4	1	20	100	3-#12 AWG	
18	EXISTING	-	1	20	100	3-#12 AWG	'B'
19	EXISTING	-	1	20	100	3-#12 AWG	'B'
20	EXISTING	-	1	20	100	3-#12 AWG	'B'
21	EXISTING	-	1	20	100	3-#12 AWG	'B'
22	EXISTING	-	1	15	100	3-#14 AWG	'B'
23	EXISTING	-	1	15	100	3-#14 AWG	'B'
24	EXISTING	-	1	15	100	3-#14 AWG	'B'
25	EXISTING	-	1	15	100	3-#14 AWG	'B'
26	SPARE	-	1	20	100	- - -	
27	SPARE	-	1	20	100	- - -	
28	SPARE	-	1	20	100	- - -	
29	SPARE	-	1	15	100	- - -	
30	SPARE	-	1	15	100	- - -	
31	SPARE	-	1	15	100	- - -	
32	PREPARED SPACE	-	1	-	100	- - -	
33	PREPARED SPACE	-	1	-	100	- - -	
34	PREPARED SPACE	-	1	-	100	- - -	
35	PREPARED SPACE	-	1	-	100	- - -	
36	PREPARED SPACE	-	1	-	100	- - -	
37	PREPARED SPACE	-	1	-	100	- - -	
38	PREPARED SPACE	-	1	-	100	- - -	
39	PREPARED SPACE	-	1	-	100	- - -	
40	PREPARED SPACE	-	1	-	100	- - -	
TOTAL KVA:		-					

'A' - ARC FAULT CIRCUIT BREAKER
'B' - CONTRACTOR SHALL PROVIDE ARC FAULT CIRCUIT BREAKER FOR ALL EXISTING CIRCUITS REQUIRED BY NEC.


LIGHT FIXTURE SCHEDULE					
LTG. CODE	DESCRIPTIONS	VOLTS	CATALOG NO./ MANUFACTURER	MOUNTING	LAMP (G.E. OR EQUAL)
'A'	5" RECESSED LIGHT FIXTURE. WHITE BAFFLE AND FINISH TRIM. UL LISTED.	120	- - - OR EQUAL	RECESSED/ CEILING	-
'B'	2 LIGHT SURFACE MOUNTED CEILING FIXTURE, BRUSHED NICKEL FINISH. UL LISTED.	120	- HAMPTON BAY OR EQUAL	SURFACE/ CEILING	(2) 60W INCAN
'C'	OUTDOOR WALL SCONCE. BLACK FINISH WITH WHITE LENS. ENERGY STAR QUALIFIED. COMPACT FLUORESCENT LAMPING. UL LISTED WET LOCATION.		88198BLE-12 SEA GULL LTG OR EQUAL	SURFACE/ WALL	(1) GU24 CFL
'D'	FULLY ADJUSTABLE DUAL HEAD LED FLOOD LIGHT WITH MOTION SENSOR. 1200 LUMEN OUTPUT. INTEGRAL PHOTOCELL, ADJUSTABLE ON-TIME, MANUAL OVERRIDE. WHITE FINISH. UL LISTED WET LOCATIONS.	120	OFLR-6LC-120-MO-WH LITHONIA LTG OR EQUAL	SURFACE/ WALL	LED

FIRE ALARM SYMBOL LIST	
Ⓢ	AC SMOKE DETECTOR WITH BATTERY BACKUP
Ⓢ _{CO}	AC COMBINATION SMOKE/CARBON MONOXIDE DETECTOR WITH BATTERY BACKUP


ELECTRICAL SYMBOL LIST	
□	RECESSED LOAD CENTER
⚡	QUAD RECEPTACLE
⚡ GFCI WP	DUPLEX RECEPTACLE GFCI - GROUND FAULT CIRCUIT INTERRUPTER WP - WITHIN WEATHERPROOF ENCLOSURE
●	SPECIAL PURPOSE CONNECTION
DB	DOOR BELL
TI	TRANSFORMER
CH	DOOR BELL CHIME
S	SWITCH (NONE) - SINGLE POLE 2 - TWO POLE 3 - THREE WAY 4 - FOUR WAY D - DIMMER TOL - THERMAL OVERLOAD PROTECTION DEVICE

ELECTRICAL GENERAL NOTES	
1. SEE SPECIFICATIONS, DIVISION 26 ELECTRICAL.	
2. UNLESS OTHERWISE INDICATED, PROVIDE A COMPLETE AND OPERATIONAL ELECTRICAL SYSTEM INCLUDING ALL NECESSARY MATERIAL, LABOR AND EQUIPMENT.	
3. ELECTRICAL PLANS AND DETAILS AND ONE LINE DIAGRAMS SHOW THE GENERAL LOCATION AND ARRANGEMENT OF THE ELECTRICAL SYSTEM. THEY ARE DIAGRAMMATIC AND DO NOT SHOW ALL CONDUIT BODIES, CONNECTORS, BENDS, FITTINGS, HANGERS AND ADDITIONAL PULL AND JUNCTION BOXES	
4. PROVIDE FIRE ALARM DETECTION DEVICES.	
5. ALL EQUIPMENT AND MATERIAL SHALL BE LABELED, LISTED AND INSTALLED IN ACCORDANCE WITH THEIR LISTING.	
6. THE CONTRACTOR SHALL OBTAIN ALL REQUIRED PERMITS AND ARRANGE FOR ALL REQUIRED INSPECTIONS IN ACCORDANCE WITH STATE AND LOCAL GOVERNING AUTHORITIES	
7. ALL WORK SHALL BE DONE WITH LICENSED WORKMEN IN ACCORDANCE WITH STATE AND LOCAL GOVERNING AUTHORITIES.	
8. THE DEFINITION OF ELECTRICAL TERMS USED SHALL BE AS DEFINED IN THE 2011 NATIONAL ELECTRICAL CODE (NEC) WITH CONNECTICUT AMENDMENTS.	
9. THE TERM "INDICATED" SHALL MEAN "AS SHOWN ON CONTRACT DOCUMENTS (SPECIFICATIONS, DRAWINGS AND RELATED ATTACHMENTS)".	
10. THE TERM "PROVIDE" SHALL MEAN "TO FURNISH, INSTALL AND CONNECT COMPLETELY".	
11. THE TERM "SIZE" SHALL MEAN ONE OR MORE OF THE FOLLOWING: "LENGTH, CURRENT AND VOLTAGE RATING, NUMBER OF POLES, NEMA SIZE AND OTHER SIMILAR ELECTRICAL CHARACTERISTICS".	
12. THE TERM "SPACE" ON PANELBOARD AND SWITCHBOARD SCHEDULES SHALL MEAN "PROVIDE SPACE TO INSTALL THE NUMBER OF POLES AND SIZE OF THE PROTECTIVE DEVICE INDICATED WITH ALL NECESSARY BUS AND FITTINGS TO INSTALL THE DEVICE AT SOME FUTURE DATE".	
13. ELECTRICAL PLANS AND DETAILS DO NOT SHOW ALL INTERFERENCES AND CONDITIONS, VISIBLE AND/OR HIDDEN, THAT MAY EXIST; THUS REQUIRING THE CONTRACTOR TO INSPECT AND SURVEY THE SPACE BEFORE PERFORMING THE WORK.	
14. COORDINATE ELECTRICAL WORK WITH OWNER.	
15. COORDINATE ELECTRICAL WORK WITH OTHER DIVISIONS OF THIS PROJECT.	
16. TURN OVER TO THE OWNER ALL MANUFACTURERS WARRANTIES FOR EQUIPMENT AND MATERIAL PROVIDED.	
17. UNLESS OTHERWISE INDICATED, ALL ELECTRICAL EQUIPMENT HAS BEEN BASED ON SQUARE D PRODUCTS.	
18. THE CONTRACTOR MAY SUBSTITUTE EQUIPMENT OF ANOTHER MANUFACTURER IF IT IS OF EQUAL QUALITY AND RATING, SUBJECT TO OWNER'S AND ENGINEER'S REVIEW AND ACCEPTANCE.	
19. UNLESS OTHERWISE INDICATED, ALL ENCLOSURES FOR EQUIPMENT PROVIDED SHALL BE NEMA TYPE 1.	
20. UNLESS OTHERWISE INDICATED, ALL CONDUCTORS TO BE COPPER THHN/THWN.	
21. UNLESS OTHERWISE INDICATED, ALL OUTLET AND SWITCH BOXES TO BE CAST IRON WITH THREADED HUBS.	
22. IN INTERIOR PROTECTED LOCATIONS, OUTLET AND SWITCH BOXES MAY BE STEEL.	
23. BEFORE SELECTING MATERIAL AND EQUIPMENT, AND PROCEEDING WITH WORK, INSPECT AREAS WHERE MATERIAL AND EQUIPMENT ARE TO BE INSTALLED TO INSURE SUITABILITY, AND CHECK NEEDED SPACE FOR PLACEMENT, CLEARANCES AND INTERCONNECTIONS.	
24. BEFORE CUTTING OR DRILLING INTO BUILDING ELEMENTS, INSPECT AND LAYOUT WORK TO AVOID DAMAGING STRUCTURAL ELEMENTS AND BUILDING UTILITIES.	
25. ALL WORK SHALL BE DONE IN ACCORDANCE WITH 2011 NATIONAL ELECTRIC CODE (NEC) ANSI/NFPA 70, NFPA 72, NFPA 101.	
26. THE MEASUREMENT FROM ABOVE FINISHED FLOOR (AFF) SHALL BE TAKEN FROM THE FINISHED FLOOR SURFACE TO THE TOP OF WALL RECEPTACLES AND SWITCH BOXES, TO THE CENTER LINE OF WALL LIGHTING OUTLET BOXES, TO THE TOP OF WALL MOUNTED EQUIPMENT ENCLOSURES, TO THE CENTER LINE OF THE TOP MOST SWITCH HANDLE, OR TO THE LOWEST SURFACE OF CEILING LIGHTING FIXTURES OTHER CEILING MOUNTED EQUIPMENT.	
27. UNLESS OTHERWISE INDICATED, ALL CONDUCTORS ARE NO. 12 AWG.	
28. CONDUIT SIZE FOR INDICATED CONDUCTORS SHALL BE BASED ON CHAPTER 9 OF NEC.	
29. THE CONTRACTOR MAY GROUP BRANCH CIRCUIT HOME RUN CONDUCTORS IN A SINGLE RACEWAY IN ACCORDANCE WITH NEC ARTICLE 300-17, AND ARTICLE 310, NOTE 8 OF NOTES TO TABLES 310-16 THROUGH 310-19.	
30. ALL BLANK COVER PLATES TO BE STAINLESS STEEL.	
31. CONTRACTOR SHALL OBTAIN AND PAY FOR ALL LOCAL UTILITY COMPANIES (POWER, TELEPHONE, CABLE TV) CHARGES FOR SERVICE DISCONNECTONS AND SERVICE INSTALLATIONS.	

ELECTRICAL ABBREVIATIONS	
A	AMPERES
A.F.F.	ABOVE FINISHED FLOOR
AWG	AMERICAN WIRE GAUGE
C	CONDUIT
CIR	CIRCUIT
FA	FIRE ALARM
FAAP	FIRE ALARM ANNUNCIATOR PANEL
FACP	FIRE ALARM CONTROL PANEL
FT	FEET
G	GROUNDING
HP	HORSEPOWER
KAIC	INTERRUPTING CAPACITY (KILOAMPERE)
KVA	KILOVOLT-AMPERE
KW	KILOWATT
NEC	NATIONAL ELECTRIC CODE
NEMA	NATIONAL ELECTRICAL MANUFACTURERS ASS.
NIC	NOT IN CONTRACT
P	POLE
RM	ROOM
S	SMOKE DETECTOR
UL	UNDERWRITER'S LABORATORY
UTIL	UTILITY
V	VOLTS
VA	VOLT-AMPERES
W	WATTS
#	WIRE SIZE IN AWG, OR MCM WHEN INDICATED

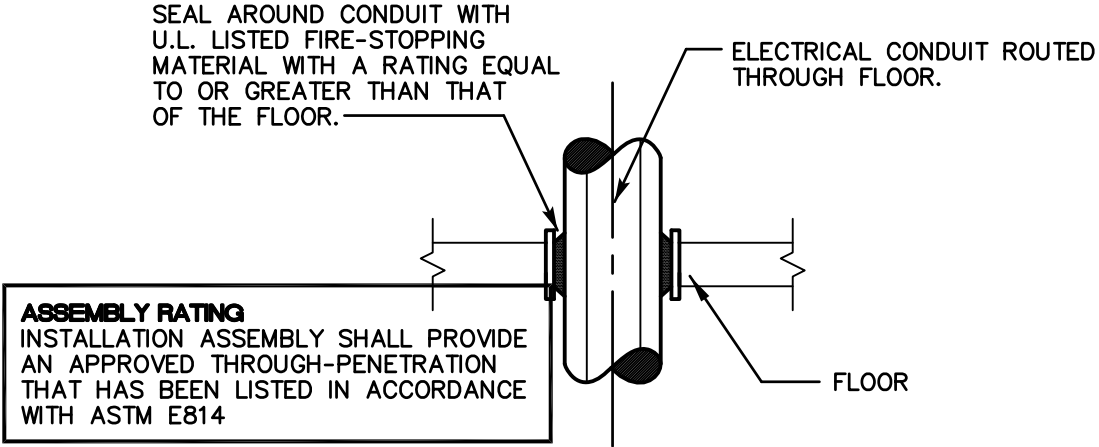

**TYPICAL CONDUIT FLOOR
PENETRATION DETAIL**
SCALE: N.T.S.

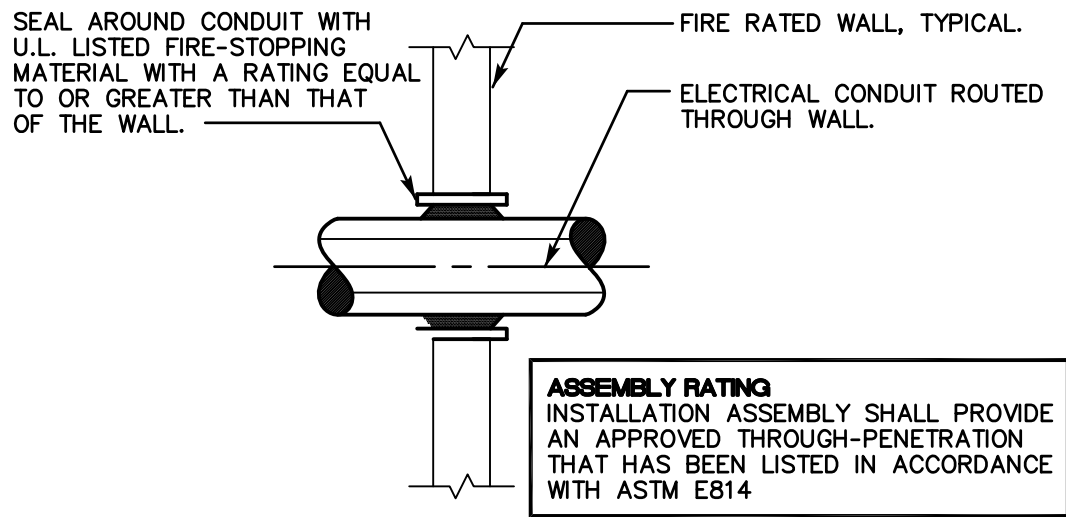

**TYPICAL CONDUIT WALL
PENETRATION DETAIL**
SCALE: N.T.S.

Revisions	Date
Bid Set	04.06.15

CONSULTANT

SALAMONE
&
ASSOCIATES, P.C.

CONSULTING ENGINEERS
118 North Plains Industrial Road
Wallingford, Connecticut 06495
Tel: (203) 867-8888
Fax: (203) 867-8728

© ARIS CRIST AIA 2015.
THIS TECHNICAL DRAWING AND
THE ARCHITECTURAL WORK
DEPICTED ARE COPYRIGHTED BY
ARIS CRIST AIA

Arís Crist Architects

34 East Putnam Avenue
Greenwich, Connecticut 06830
203 661 0661


RESIDENCE No. 1260

35 HARBOR VIEW AVE.
NORWALK CT, 06854

ELECTRICAL SCHEDULES, SYMBOLS, NOTES & ABBREVIATIONS

JDB	Drawn
JAS	Checked
10.27.2014	Date
AS NOTED	Scale
	Job Number
	Sheet

E-2.0

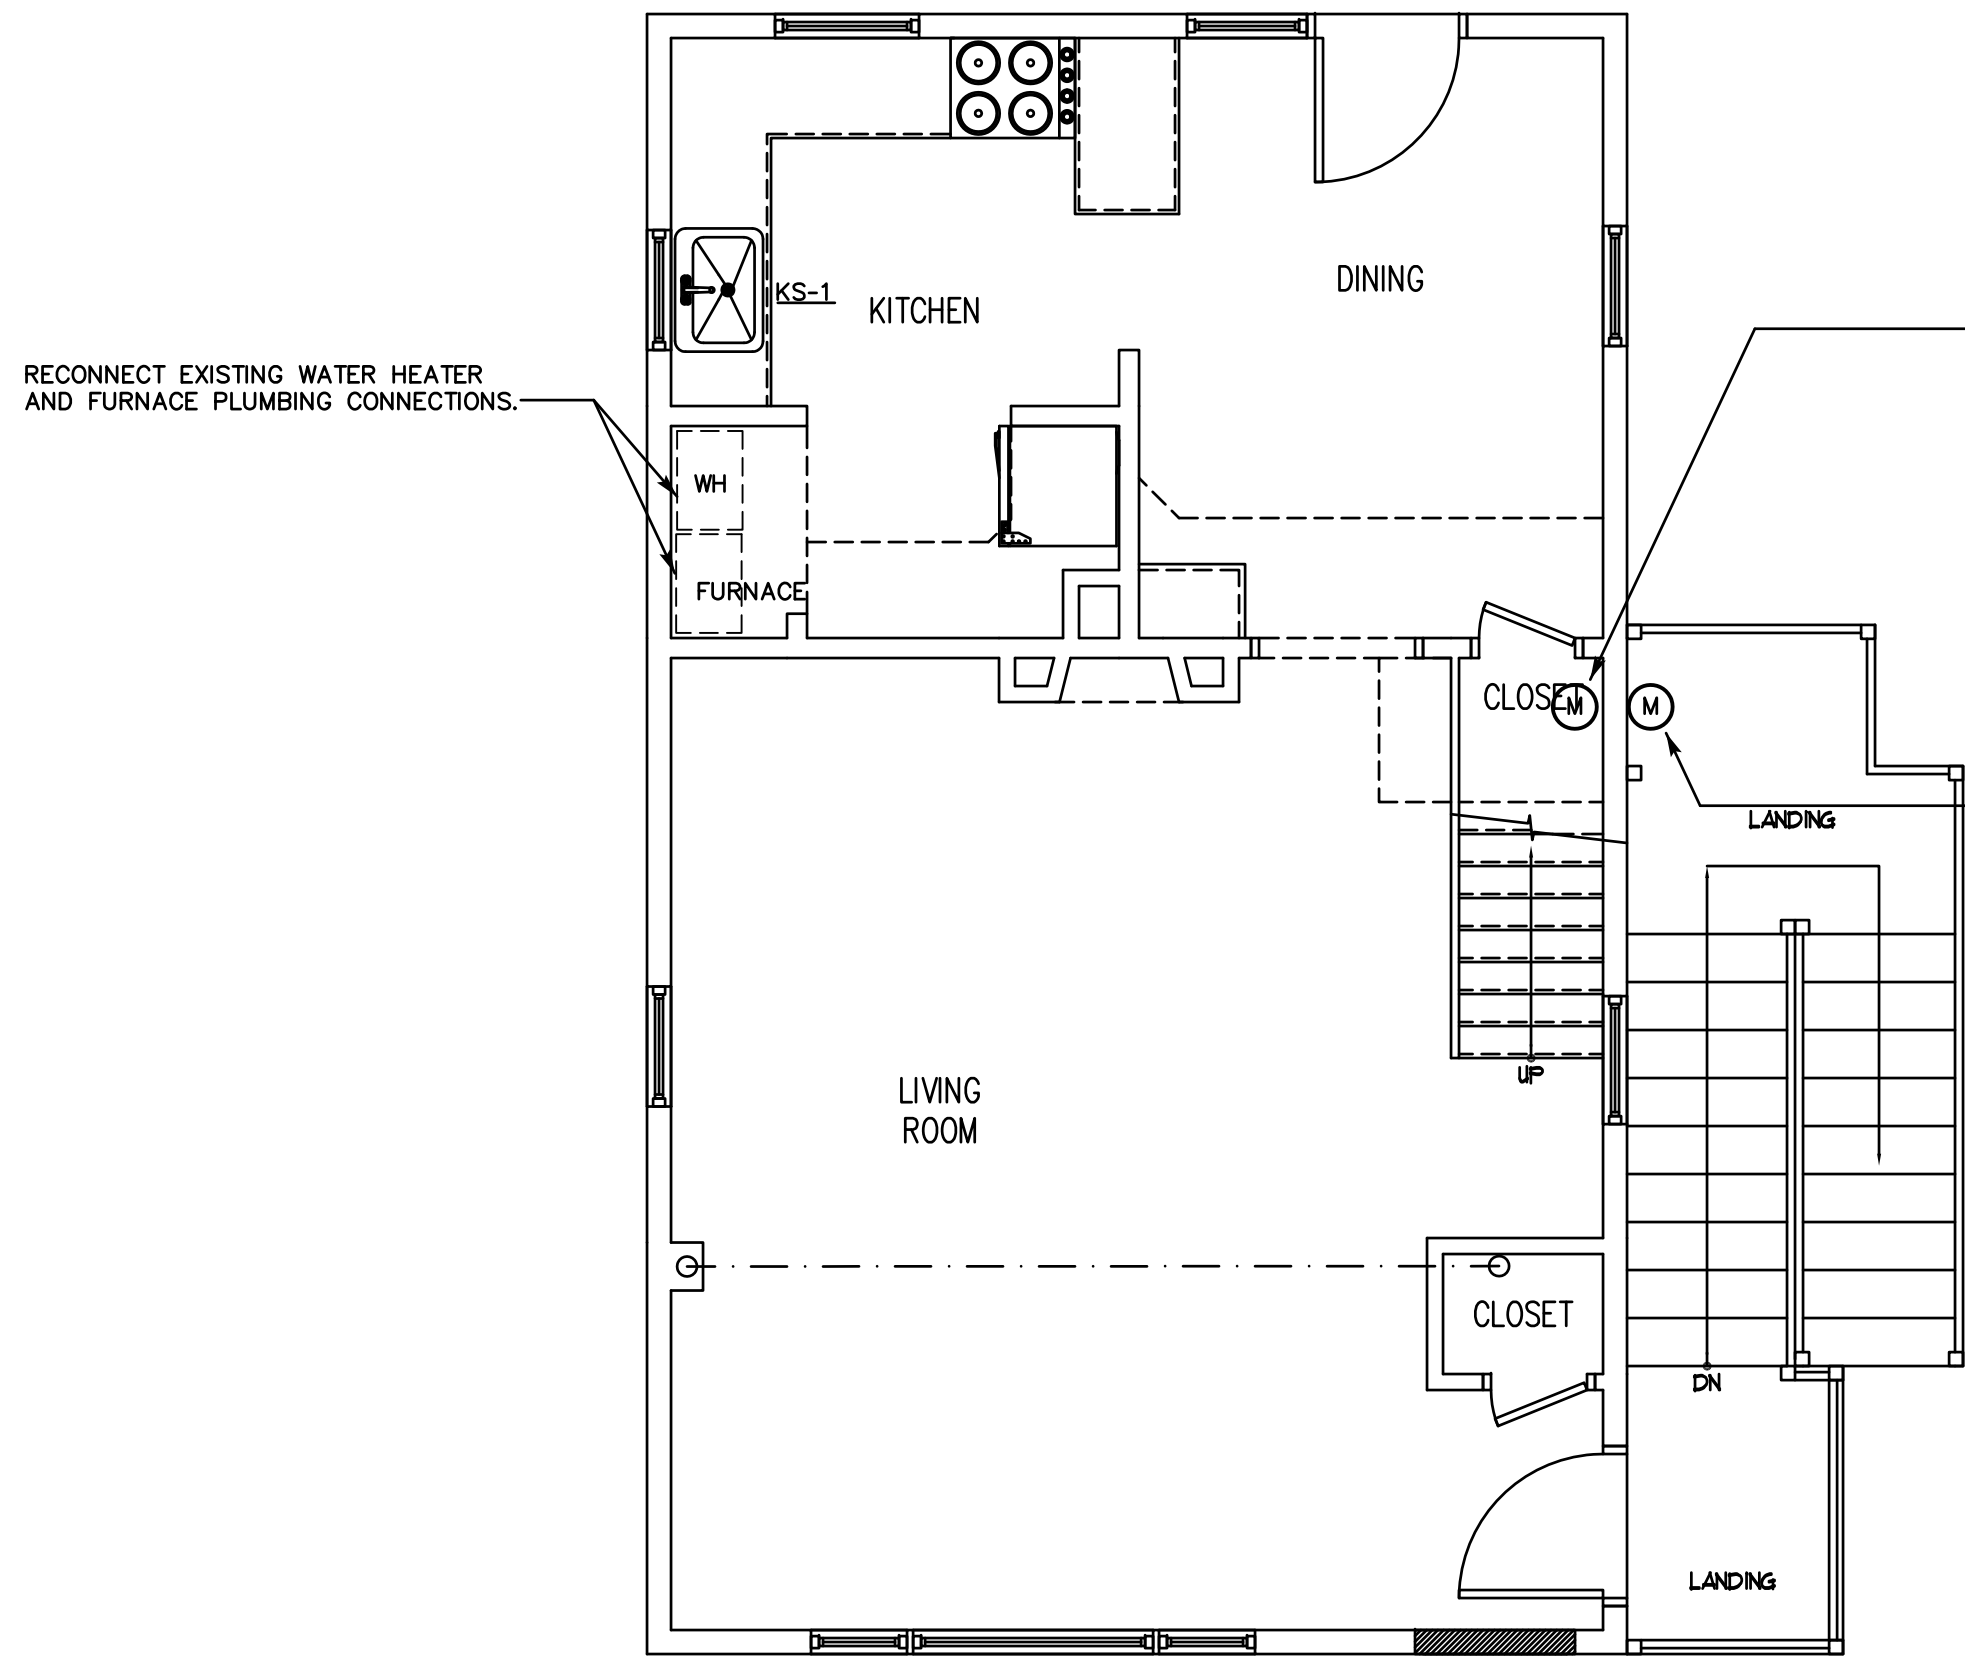

FIRST FLOOR PLUMBING PLAN

SCALE: 1/4"=1'-0"

EXISTING FIXTURES AND ASSOCIATED PLUMBING CONNECTIONS TO REMAIN.

RELOCATE EXISTING WATER METER AND ASSOCIATED VALVES AND ACCESSORIES WITHIN EXISTING INTERIOR CLOSET AND ABOVE FLOOD PLAIN LEVEL. COORDINATE EXACT LOCATION WITH ARCHITECT. EXISTING UNDERGROUND DOMESTIC WATER SUPPLY MAIN TO BE EXTENDED TO PROPOSED LOCATION. PROVIDE DOMESTIC COLD WATER SUPPLY MAIN AT BUILDING TO CONNECT TO EXISTING DCW MAIN AND SUPPLIES. PROVIDE ALL PIPING, FITTINGS, VALVES AND CONNECTIONS AS REQUIRED FOR PROPER SYSTEM INSTALLATION/REINSTALLATION. INSULATE PIPING. PIPING SHALL BE PROPERLY SUPPORTED AND PROTECTED FROM FREEZING. COORDINATE PROTECTION/INSULATION WITH ARCHITECT. COORDINATE METER WITH ARCHITECT AND LOCAL UTILITY CO.

RELOCATE EXISTING NG METER AND SERVICE MAIN. RAISE METER AND ASSOCIATED VENT, VALVES AND APURTENANCES WITH BUILDING ABOVE 100 YEAR FLOOD PLAIN LEVEL. METER SHALL BE ACCESSIBLE FOR READING AND MAINTENANCE. REINSTALL AND PROVIDE PROPER PIPING AND METER SUPPORT PER NFPA 54 REQUIREMENTS. PROVIDE ADDITIONAL PIPING ACCORDINGLY. PROVIDE NG PIPING FROM METER TO PROPOSED APPLIANCES/EQUIPMENT LOCATIONS. RECONNECT, PROVIDE ANY/ALL VALVES AND FITTINGS AS REQUIRED FOR PROPER RECONNECTION. GAS METER SHALL BE MINIMUM 10 FT FROM ANY MECHANICAL AIR INTAKE AS PER CODE. SEE MECHANICAL PLANS. COORDINATE EXACT LOCATION WITH ARCHITECT. COORDINATE WITH LOCAL UTILITY CO. NG PIPING SHALL NOT BE ENCASED IN SPRAY FOAM INSULATION.

SANITARY NOTE:
EXISTING SANITARY TO BE RAISED WITH STRUCTURE. PROVIDE PIPING TO EXTEND TO ALL EXISTING RISERS. LOCATE SANITARY MAIN VERT AT NEAREST PIER. PROVIDE EXTENSIONS OF ALL EXISTING CLEANOUTS TO MAINTAIN ABOVE GRADE ACCESS. PROVIDE ADDITIONAL ACCESSIBLE ABOVE GRADE CLEANOUTS AT PROPOSED MAIN BUILDING DRAIN RISER EXTENSIONS. TYPICAL.


DOMESTIC WATER NOTE:
EXISTING HORIZONTAL DOMESTIC HOT AND COLD WATER DISTRIBUTION PIPING AT CRAWL SPACE/BELOW FIRST FLOOR, THAT IS TO REMAIN SHALL BE RAISED WITH BUILDING. ALL EXISTING RISERS TO FIRST AND SECOND FLOOR FIXTURES AND MAINS TO REMAIN AND BE EXTENDED/RECONNECTED. PROVIDE ALL PIPING AND ACCESSORIES AS REQUIRED FOR PROPER INSTALLATION AND RECONNECTION.

NOTES:
INSULATE PROPOSED DOMESTIC WATER SYSTEM PIPING WITHIN BUILDING INTERIOR WITH MIN. R-4.

COORDINATE ALL PIPING ROUTING WITH ARCHITECTURAL AND ALL OTHER PROJECT DISCIPLINES. PIPING SHALL BE INSTALLED PER CURRENT CODES AND STANDARDS. TYPICAL.

ALL DOMESTIC WATER & SANITARY PIPING EXTERIOR RISERS SHALL BE PROTECTED FROM IMPACTS, FREEZING, AND WEATHER. COORDINATE PROTECTION WITH STRUCTURAL DRAWINGS, INSULATION WITH ARCHITECTURAL DRAWINGS, AND HEAT TRACE WITH ELECTRICAL DRAWINGS.

ALL NG PIPING EXTERIOR RISERS SHALL BE PROTECTED FROM IMPACTS AND WEATHER. COORDINATE PROTECTION WITH STRUCTURAL DRAWINGS.

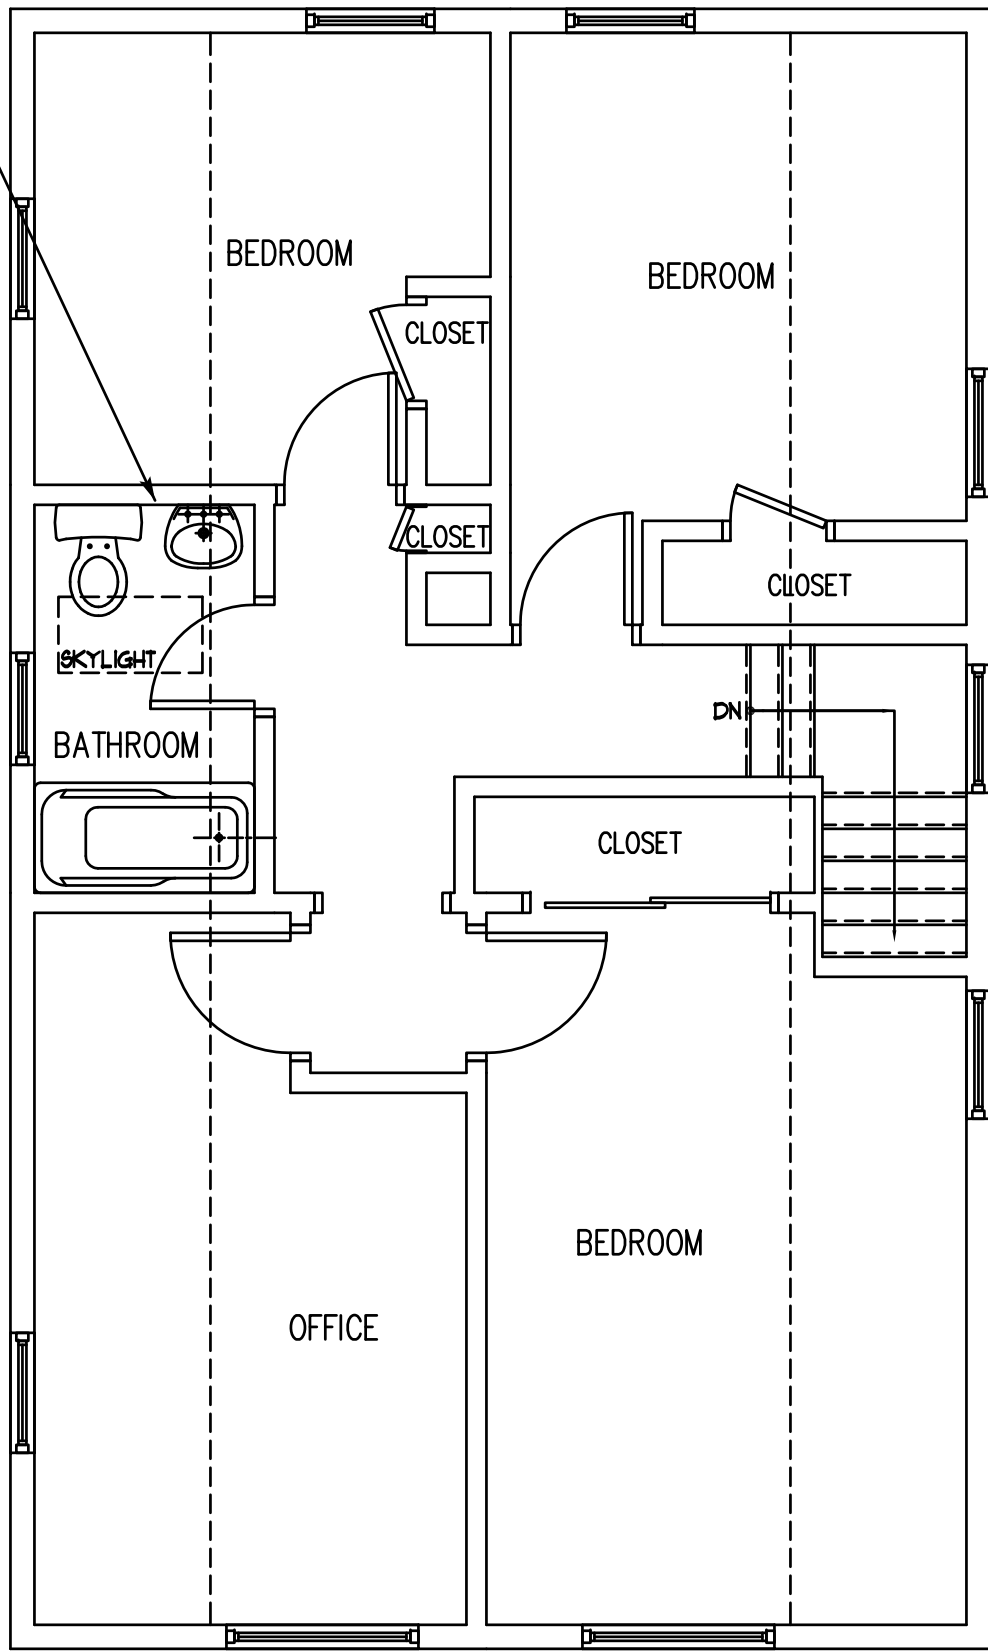

SECOND FLOOR PLUMBING PLAN

SCALE: 1/4"=1'-0"

WARNING

"CALL BEFORE YOU DIG"
1-800-922-4455

- CONTRACTOR SHALL REGISTER HIS INTENTION TO START EXCAVATIONS AT OR NEAR A PUBLIC UTILITY AT LEAST TWO FULL WORKING DAYS PRIOR TO THE ACTIVITY.
- CONTRACTOR SHALL RETURN SITE TO ORIGINAL CONDITION AFTER INSTALLATION OF ANY/ALL PROPOSED UTILITIES, EQUIPMENT, MATERIALS AND STRUCTURES.
 - THE LOCATION OF ALL UNDERGROUND UTILITIES IS BASED UPON THE BEST AVAILABLE INFORMATION. CONTRACTOR SHALL CONFIRM LOCATION OF ALL UNDERGROUND UTILITIES, FOUNDATIONS AND STRUCTURES PRIOR TO COMMENCEMENT OF ANY EXCAVATION.
 - CONTRACTOR IS RESPONSIBLE FOR REPAIR AND PAYMENT FOR ALL UTILITIES DAMAGED DURING CONSTRUCTION.

PLUMBING GENERAL NOTES:

- THE CONTRACTOR SHALL VISIT THE PROJECT SITE, PRIOR TO BIDDING, AND BECOME INFORMED AS TO THE NATURE AND SCOPE OF WORK REQUIRED, NOTING AND ACCOUNTING FOR EXISTING CONDITIONS. TYPICAL.
- THE CONTRACTOR SHALL BE RESPONSIBLE FOR ALL WORK INCLUDING TOOLS, MATERIAL, MANPOWER, ETC. REQUIRED FOR COMPLETE AND PROPER INSTALLATION OF PROPOSED MATERIALS, FIXTURES AND/OR EQUIPMENT.
- ALL WORK SHALL BE PERFORMED IN A SAFE AND ORDERLY MANNER WITH QUALIFIED AND LICENSED PERSONNEL IN ACCORDANCE WITH STATE AND LOCAL GOVERNING AUTHORITIES AND ALL APPLICABLE CODES AND STANDARDS. TYPICAL.
- CONTRACTOR SHALL PROVIDE CLEANOUTS FOR PROPOSED SANITARY PIPING AS REQUIRED PER CURRENT APPLICABLE CODES AND STANDARDS. TYPICAL.
- ROUTING OF ALL PIPING SHALL BE COORDINATED WITH STRUCTURAL FRAMING ELEMENTS AND ALL OTHER PROJECT DISCIPLINES. TYPICAL.
- PROVIDE DOUBLE CHECK VALVE BACKFLOW PREVENTER AND PRESSURE REDUCING VALVE ON DOMESTIC WATER SERVICE AS REQUIRED PER LOCAL WATER AUTHORITY AND CURRENT CODES AND STANDARDS.
- CONTRACTOR SHALL CONFIRM COMPATIBILITY OF SPRAY FOAM INSULATION WITH EXISTING SANITARY PVC/CPVC/ABS PIPING.
- CONTRACTOR SHALL CONFIRM COMPATIBILITY OF SPRAY FOAM INSULATION WITH PEX PIPING WHERE APPLICABLE.
- NO VALVES SHALL BE ENCASED IN SPRAY FOAM INSULATION.
- PROVIDE CONDENSATE DRAINAGE FOR DOMESTIC WATER HEATER AND FURNACE. PROVIDE PER MANUFACTURER'S REQUIREMENTS. COORDINATE WITH MECHANICAL. PROVIDE CONDENSATE PUMPS WHERE REQUIRED, COORDINATE WITH MECHANICAL AND ARCHITECTURAL. TYPICAL.

PLUMBING FIXTURE SCHEDULE

DESIGNATION	DESCRIPTION	FIXTURE	FITTINGS
KS-1	NEW KITCHEN SINK TOP MOUNT	18 GAUGE, TYPE 304 STAINLESS STEEL, SLIM-RIM, 8.25" BOWL DEPTH ELKAY NAMESAKE MODEL# LSS25224	1. SINGLE CONTROL FAUCET, BRASS AND COPPER WATERWAY, ADJUSTABLE HOT LIMIT SAFETY STOP, MANUFACTURER: MOEN SERIES: BANBURY 2. GARBAGE DISPOSAL MANUFACTURER: INSINKERATOR SERIES: BADGER 15SS

- NOTES:
- COORDINATE FIXTURE ACCESSORIES WITH PLUMBING PLANS AND ARCHITECTURAL DETAILS. TYPICAL.
 - PLUMBING FIXTURES SHALL BE WATER EFFICIENT AND WATER SENSE CERTIFIED WHERE APPLICABLE.
 - PLUMBING FIXTURES LISTED ABOVE, OR EQUAL, ARE ACCEPTABLE.

Revisions	Date
Bid Set	04.06.15

CONSULTANT
SALAMONE & ASSOCIATES, P.C.
CONSULTING ENGINEERS
118 North Plains Industrial Road
Wallingford, Connecticut 06495
Tel: (860) 287-8888
Fax: (860) 287-8728

© ARIS CRIST AIA 2015.
THIS TECHNICAL DRAWING AND
THE ARCHITECTURAL WORK
DEPICTED ARE COPYRIGHTED BY
ARIS CRIST AIA

Aris Crist Architects

34 East Putnam Avenue
Greenwich, Connecticut 06830
203 661 0661

RESIDENCE No. 1260

35 HARBOR VIEW AVE.
NORWALK CT, 06854

PLUMBING PLANS

JDB	Drawn
JAS	Checked
10.27.2014	Date
AS NOTED	Scale
	Job Number
	Sheet

P-1.0