

# REHABILITATION OF GRUPES RESERVOIR DAM

NID ID# CT00057

STATE ID# 9003

NEW CANAAN CONNECTICUT

FIRST TAXING DISTRICT OF THE CITY OF NORWALK WATER DEPARTMENT

CONTRACT NO. RES XXXX-XX

**OWNER/OPERATOR:**




FIRST TAXING DISTRICT  
OF THE CITY OF NORWALK,  
WATER DEPARTMENT  
12 NEW CANAAN AVENUE  
NORWALK, CONNECTICUT 06851  
(203) 847-7387

**PROJECT ENGINEER:**



GZA GEOENVIRONMENTAL, INC.  
249 VANDERBILT AVENUE  
NORWOOD, MA 02062

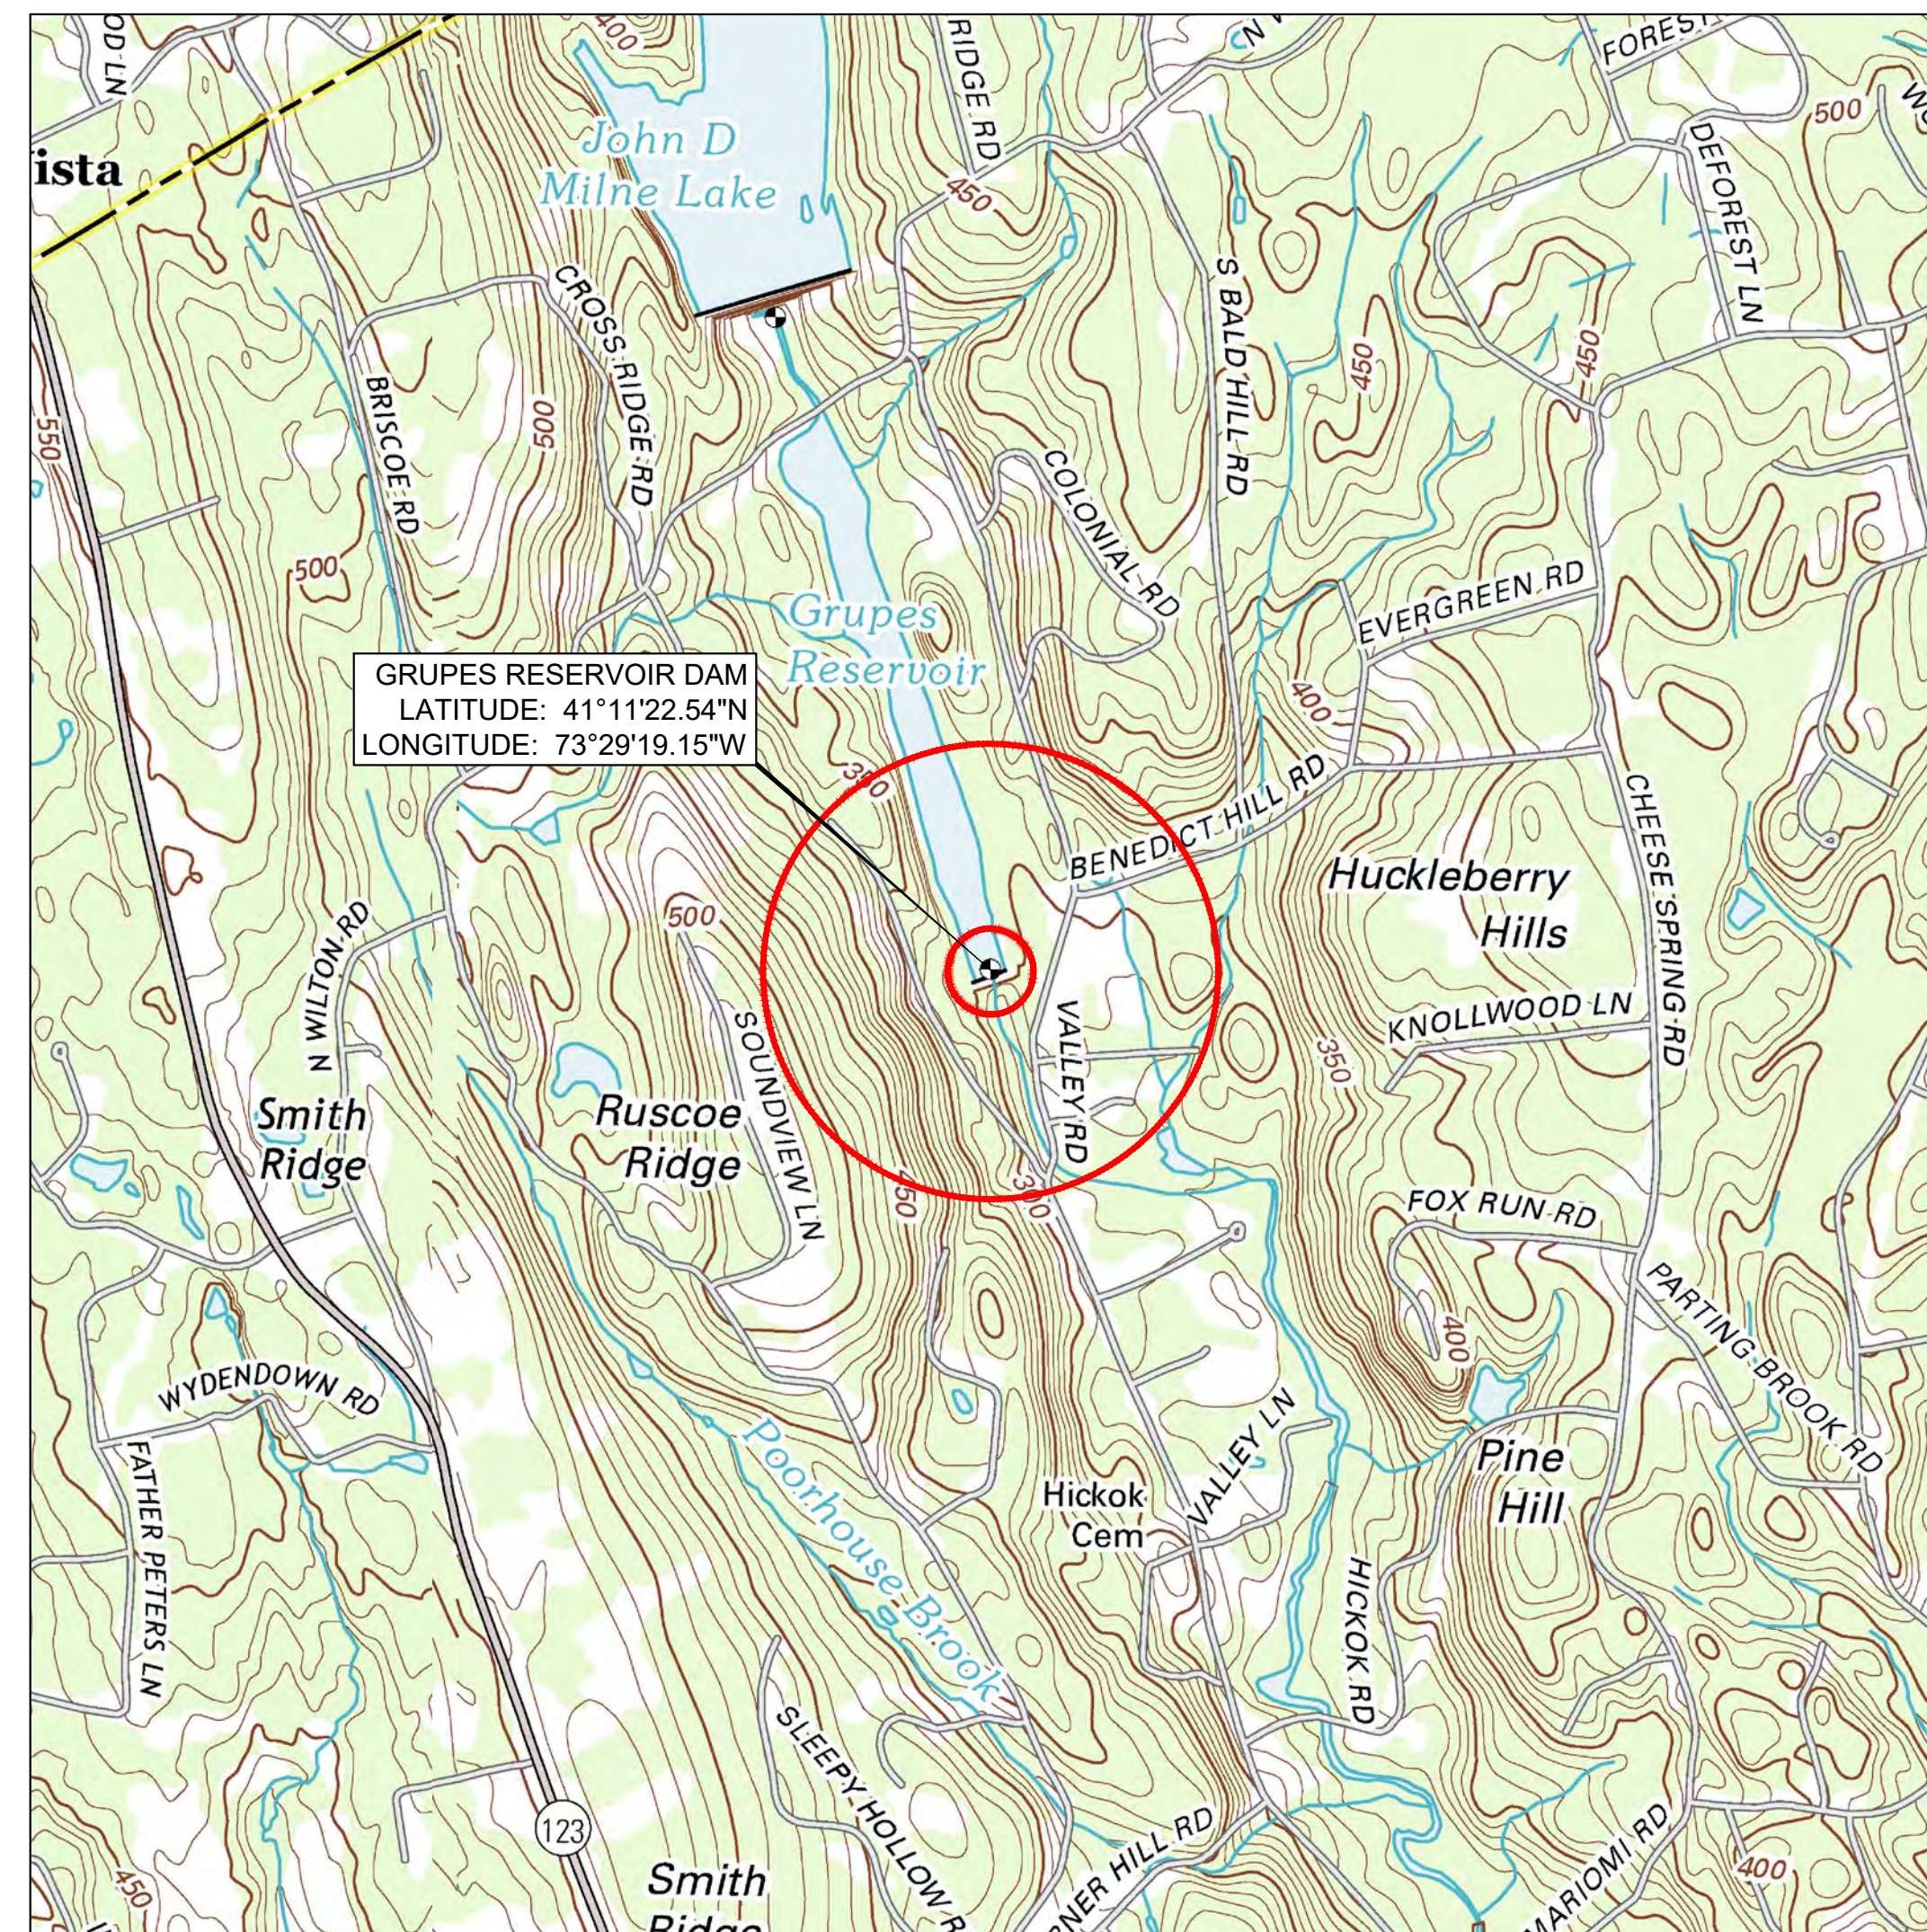

## PROJECT SITE LOCUS PLAN

SOURCE: DIGITAL TOPOGRAPHIC MAPS PROVIDED BY USGS  
NORTH AMERICAN VERTICAL DATUM OF 1988  
CONTOUR INTERVAL 10 FEET  
SHOWING 500 FOOT AND HALF-MILE RADII



## INDEX OF DRAWINGS

**SHEET:**

- G0 COVER SHEET AND INDEX OF DRAWINGS
- G1 GENERAL NOTES
- G2 EXISTING CONDITIONS SITE PLAN
- G3-G5 EXISTING CONDITIONS AND SEDIMENTATION AND EROSION CONTROL PLAN (3 SHEETS)
- G6 SEDIMENTATION AND EROSION NOTES
- G7 SEDIMENTATION AND EROSION DETAILS
- G8 TEMPORARY ACCESS AND STAGING AREA PLAN
- C1 DEMOLITION PLAN
- C2-C4 PROPOSED CONDITIONS PLAN (3 SHEETS)
- C5-C8 EAST SERVICE ROAD TYPICAL SECTIONS (4 SHEETS)
- C9 AUXILIARY SPILLWAY IMPROVEMENTS
- C10 TYPICAL DETAILS AND PROPOSED ABUTMENT MODIFICATIONS
- C11 CHAINLINK FENCE LOCATION PLAN
- S1-S2 EXISTING CONDITIONS AND DEMOLITION AT GATEHOUSE (2 SHEETS)
- S3 GATEHOUSE CONSTRUCTION/MAINTENANCE ACCESS BRACKET DETAILS
- S4 GATEHOUSE FLOOR RAISING PLAN AND DETAILS
- S5 GATEHOUSE FLOOR RAISING DETAILS
- S6 GATEHOUSE CONCRETE WALL & BRIDGE SEAT REINFORCING PLAN AND DETAILS
- S7 POST-TENSIONED ANCHOR LAYOUT PLAN
- S8 POST-TENSIONED ANCHOR LAYOUT SECTIONS
- S9 POST-TENSIONED STRAND ANCHOR DETAILS
- S10-S11 CAST-IN-PLACE CONCRETE SECTIONS & DETAILS (2 SHEETS)
- S12 FOOTBRIDGE DETAILS AND NOTES
- S13-S14 GATE HOUSE OPERATOR IMPROVEMENTS (2 SHEETS)
- WM1-WM2 WATER MAIN PLAN (2 SHEETS)
- WM3-WM4 WATER MAIN DETAILS (2 SHEETS)
- E0 ELECTRICAL SYMBOLS, NOTES, ABBREVIATIONS AND SCHEDULES
- E1 ELECTRICAL SITE PLAN
- E2 ELECTRICAL DETAILS AND ONE LINE POWER, COMMUNICATIONS AND RISER DIAGRAM
- E3 ELECTRICAL DETAILS
- A1 PLANS, ELEVATIONS & SECTIONS
- A2-A3 DETAILS (2 SHEETS)

UNLESS SPECIFICALLY STATED BY WRITTEN AGREEMENT, THIS DRAWING IS THE SOLE PROPERTY OF GZA GEOENVIRONMENTAL, INC. (GZA). THE INFORMATION SHOWN ON THE DRAWING IS SOLELY FOR USE BY GZA'S CLIENT OR THE CLIENT'S DESIGNATED REPRESENTATIVE FOR THE SPECIFIC PROJECT AND LOCATION IDENTIFIED ON THE DRAWING. THE DRAWING SHALL NOT BE TRANSFERRED, REUSED, COPIED, OR ALTERED IN ANY MANNER FOR USE AT ANY OTHER LOCATION OR FOR ANY OTHER PURPOSE WITHOUT THE PRIOR WRITTEN CONSENT OF GZA. ANY TRANSFER, REUSE, OR MODIFICATION TO THE DRAWING BY THE CLIENT OR OTHERS, WITHOUT THE PRIOR WRITTEN EXPRESS CONSENT OF GZA, WILL BE AT THE USER'S SOLE RISK AND WITHOUT ANY RISK OR LIABILITY TO GZA.

**GRUPES RESERVOIR DAM  
REHABILITATION PROJECT  
NEW CANAAN, CONNECTICUT**

**COVER SHEET AND INDEX OF DRAWINGS**

<b>PREPARED BY:</b> GZA GeoEnvironmental, Inc. Engineers and Scientists www.gza.com		<b>PREPARED FOR:</b> FIRST TAXING DISTRICT OF THE CITY OF NORWALK, WATER DEPARTMENT 12 NEW CANAAN AVENUE NORWALK, CONNECTICUT 06852 (203) 847-7387	
<b>DESIGNED BY:</b> JGD <b>DATE:</b> OCTOBER 2017	<b>REVIEWED BY:</b> MAT <b>DRAWN BY:</b> ADP/SMW <b>PROJECT NO:</b> 01.0171312.10	<b>CHECKED BY:</b> PHB <b>SCALE:</b> N.T.S. <b>REVISION NO.:</b>	<b>FIGURE</b> <b>GO</b> SHEET NO. 1 OF 44

**PROGRESS PRINT  
OCTOBER 2017**