

PHILIP M. SMALL
ATTORNEY-AT-LAW

Direct: 860-509-6575
Fax: 860-509-6675
psmall@brownrudnick.com



185 Asylum
Street
Hartford
Connecticut
06103
tel 860.509.6500
fax 860.509.6501

March 25, 2016

VIA ELECTRONIC MAIL AND OVERNIGHT DELIVERY

Mr. Robert Stein, Chairman
Connecticut Siting Council
Ten Franklin Square
New Britain, CT 06051

Re: Petition No. 1192 - SolarCity Corporation Petition for a Declaratory Ruling that no Certificate of Environmental Compatibility and Public Need is Required for the Proposed Construction and Operation of a 2.74 Megawatt Community-Shared Solar Photovoltaic Electric Generating Facility Located on Rogers Road in Norwich, Connecticut--Notifications

Dear Chairman Stein:

Pursuant to the Connecticut Siting Council's ("Council") November 13, 2015 Development and Management Plan Approval Letter, SolarCity Corporation is providing the following notifications in accordance with the reporting requirements of Section 16-50j-62(b) of the Council's regulations:

1. Start of Site Work on MP2 and MP3 (beginning on MP2): March 30, 2016;
2. Estimated Completion of Site Work on MP2 and MP3: April 25, 2016;
3. Estimated Start of Facility Construction on MP2 and MP3: April 25, 2016; and
4. Staging Area Logistics Figure for MP2 and MP3 (attached).

Please note that the dates provided above pertain only to areas MP2 and MP3 as noted on the site plans. Please contact me with any questions or if you need additional information.



Very truly yours,

BROWN RUDNICK LLP

By: 
Philip M. Small
Counsel for SolarCity Corporation

PMS/jmb
Enclosures

62433677 v1-WorksiteUS-031819/0001

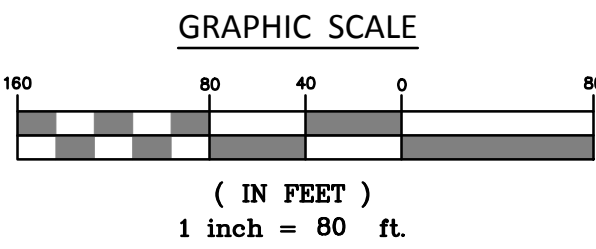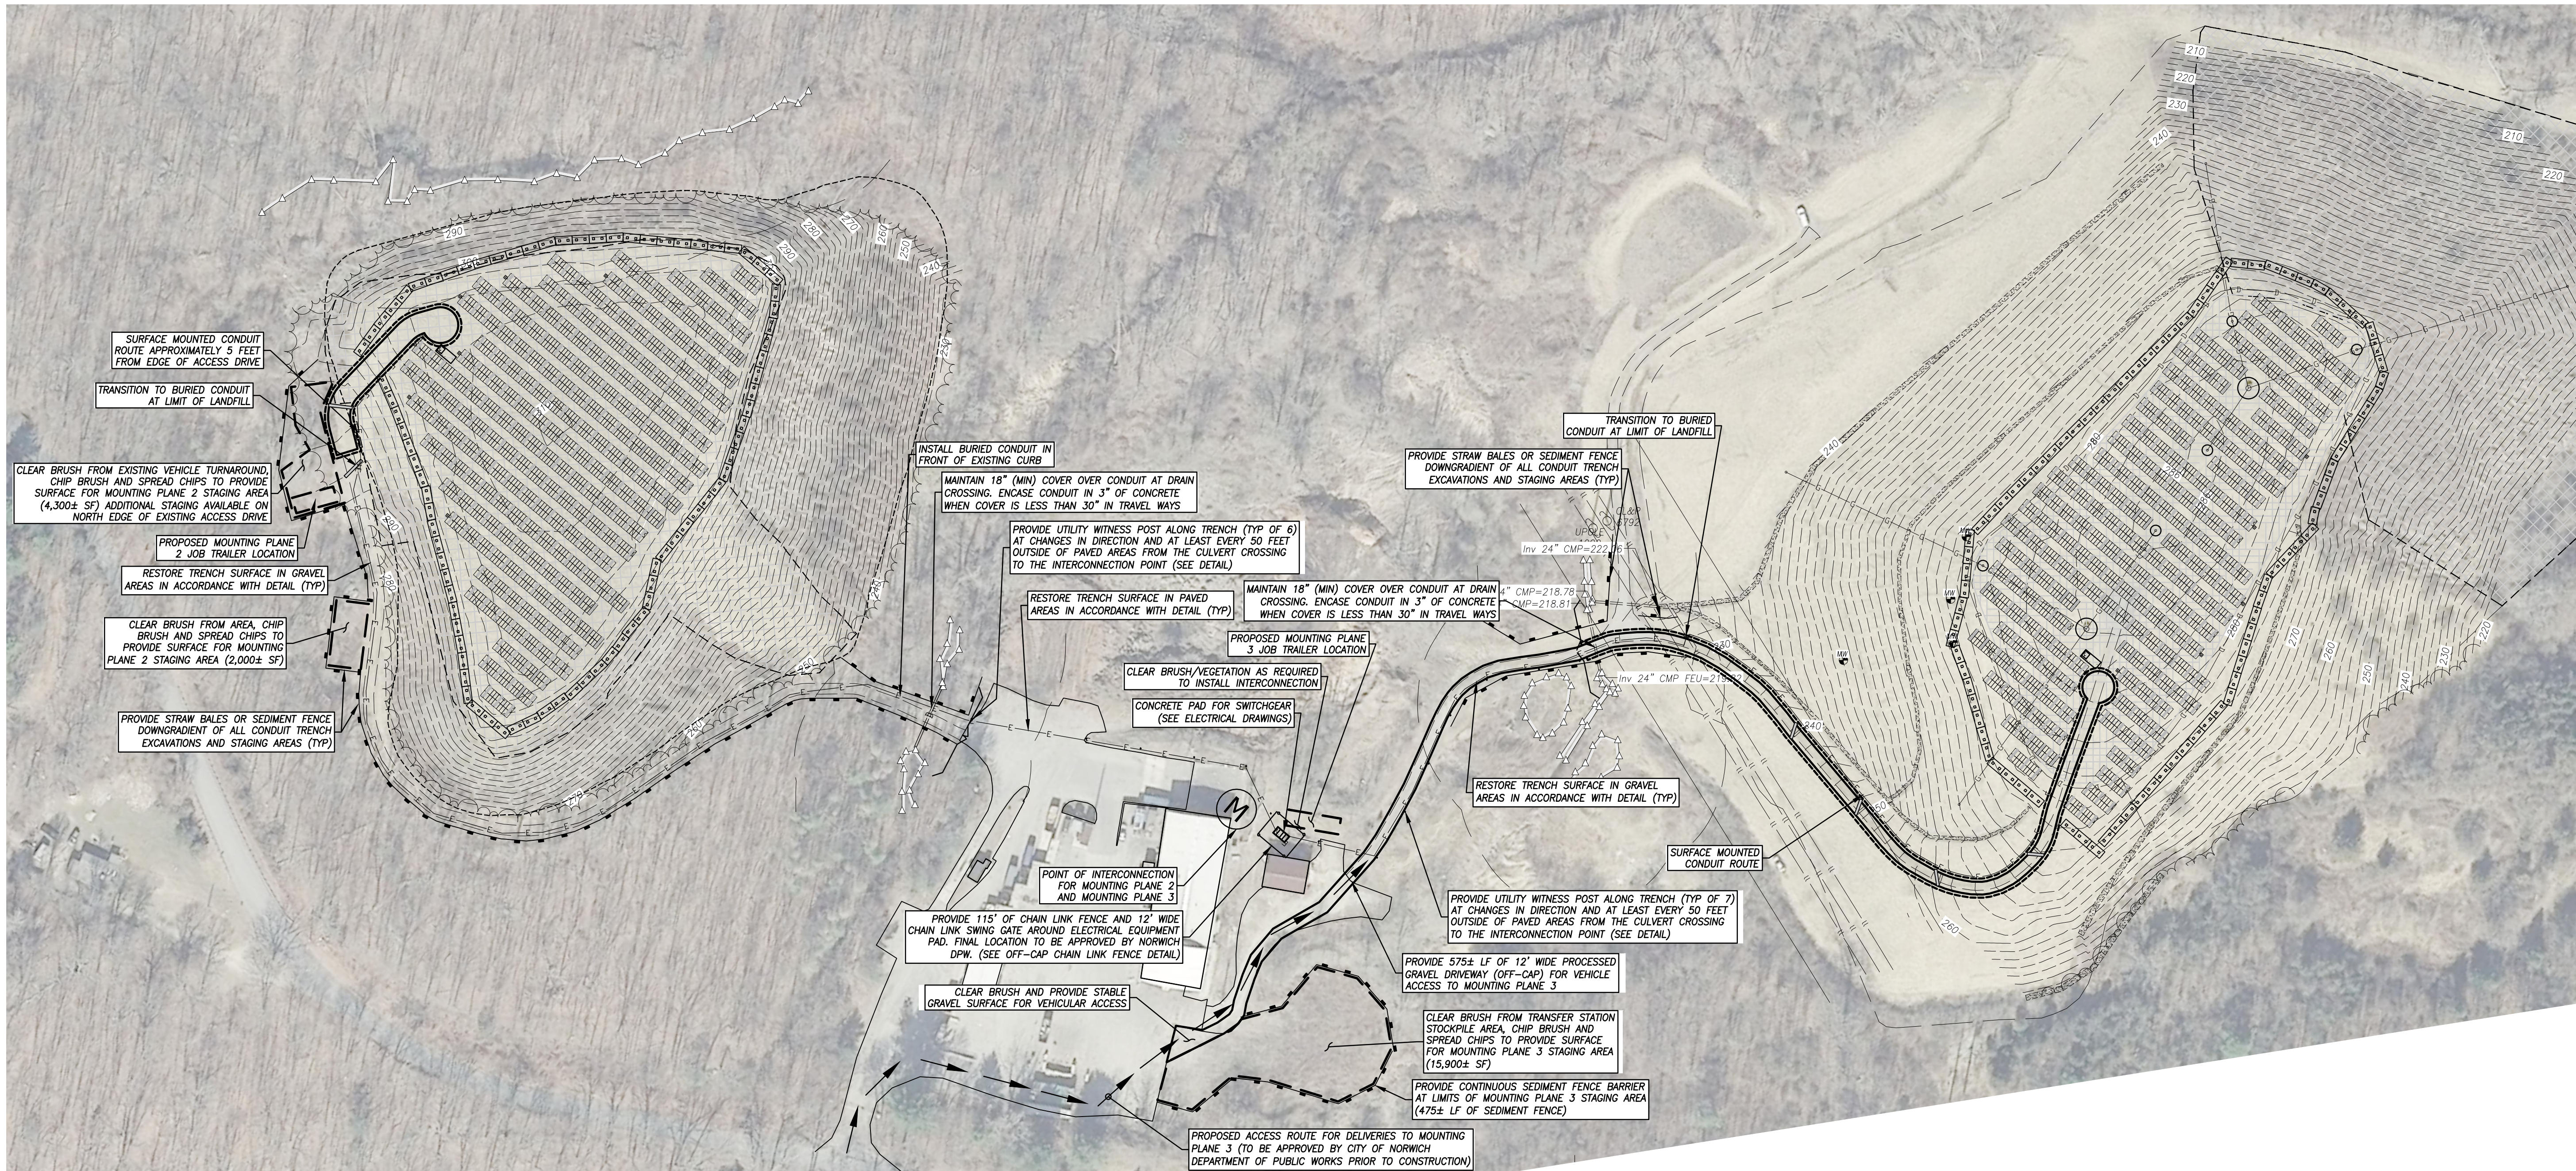

LEGEND & ABBREVIATIONS

TYP	TYPICAL
RCP	REINFORCED CONCRETE PIPE
HDPE	HIGH DENSITY POLYETHYLENE PIPE
INV	INVERT
IWC #1	INTERMITTENT WATERCOURSE FLAG
WF #1	WETLAND FLAG
SNET	SOUTHERN NEW ENGLAND TELEPHONE
CL&P	CONNECTICUT LIGHT AND POWER
AT&T	AMERICAN TELEPHONE AND TELEGRAPH
— 248 —	EXISTING CONTOUR
○	IRON PIN
○	UTILITY POLE
—	GUY WIRE
—	SIGN
△	WETLAND FLAG
—	SEDIMENT FENCE
—	STRAW WATTLE
—	CHAIN LINK FENCE
—	ELECTRICAL CONDUIT
—	OVERHEAD ELECTRICAL LINE

SolarCity Corporation
Rogers Road Landfill Solar Project
82 Rogers Road - Norwich, Connecticut
Mounting Planes 2 & 3
Overall Site Utility Plan

SCALE:	1" = 80'
DATE:	September 2015
JOB I.D. NO.	14-2302
Revisions	
Rev. A - Equipment Pad Details	9/29/15
Rev. B - Development and Management Plan	11/02/15
Rev. C - Staging Areas	3/02/16
Rev. D - GameChange Racking and Walkthrough	3/23/16
SHEET NO.	
8	12

